








 

 






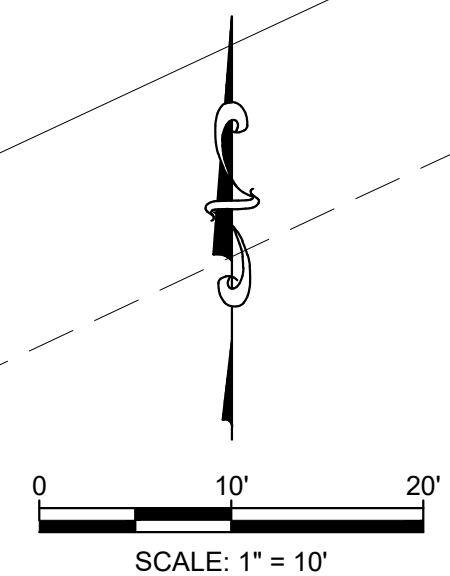
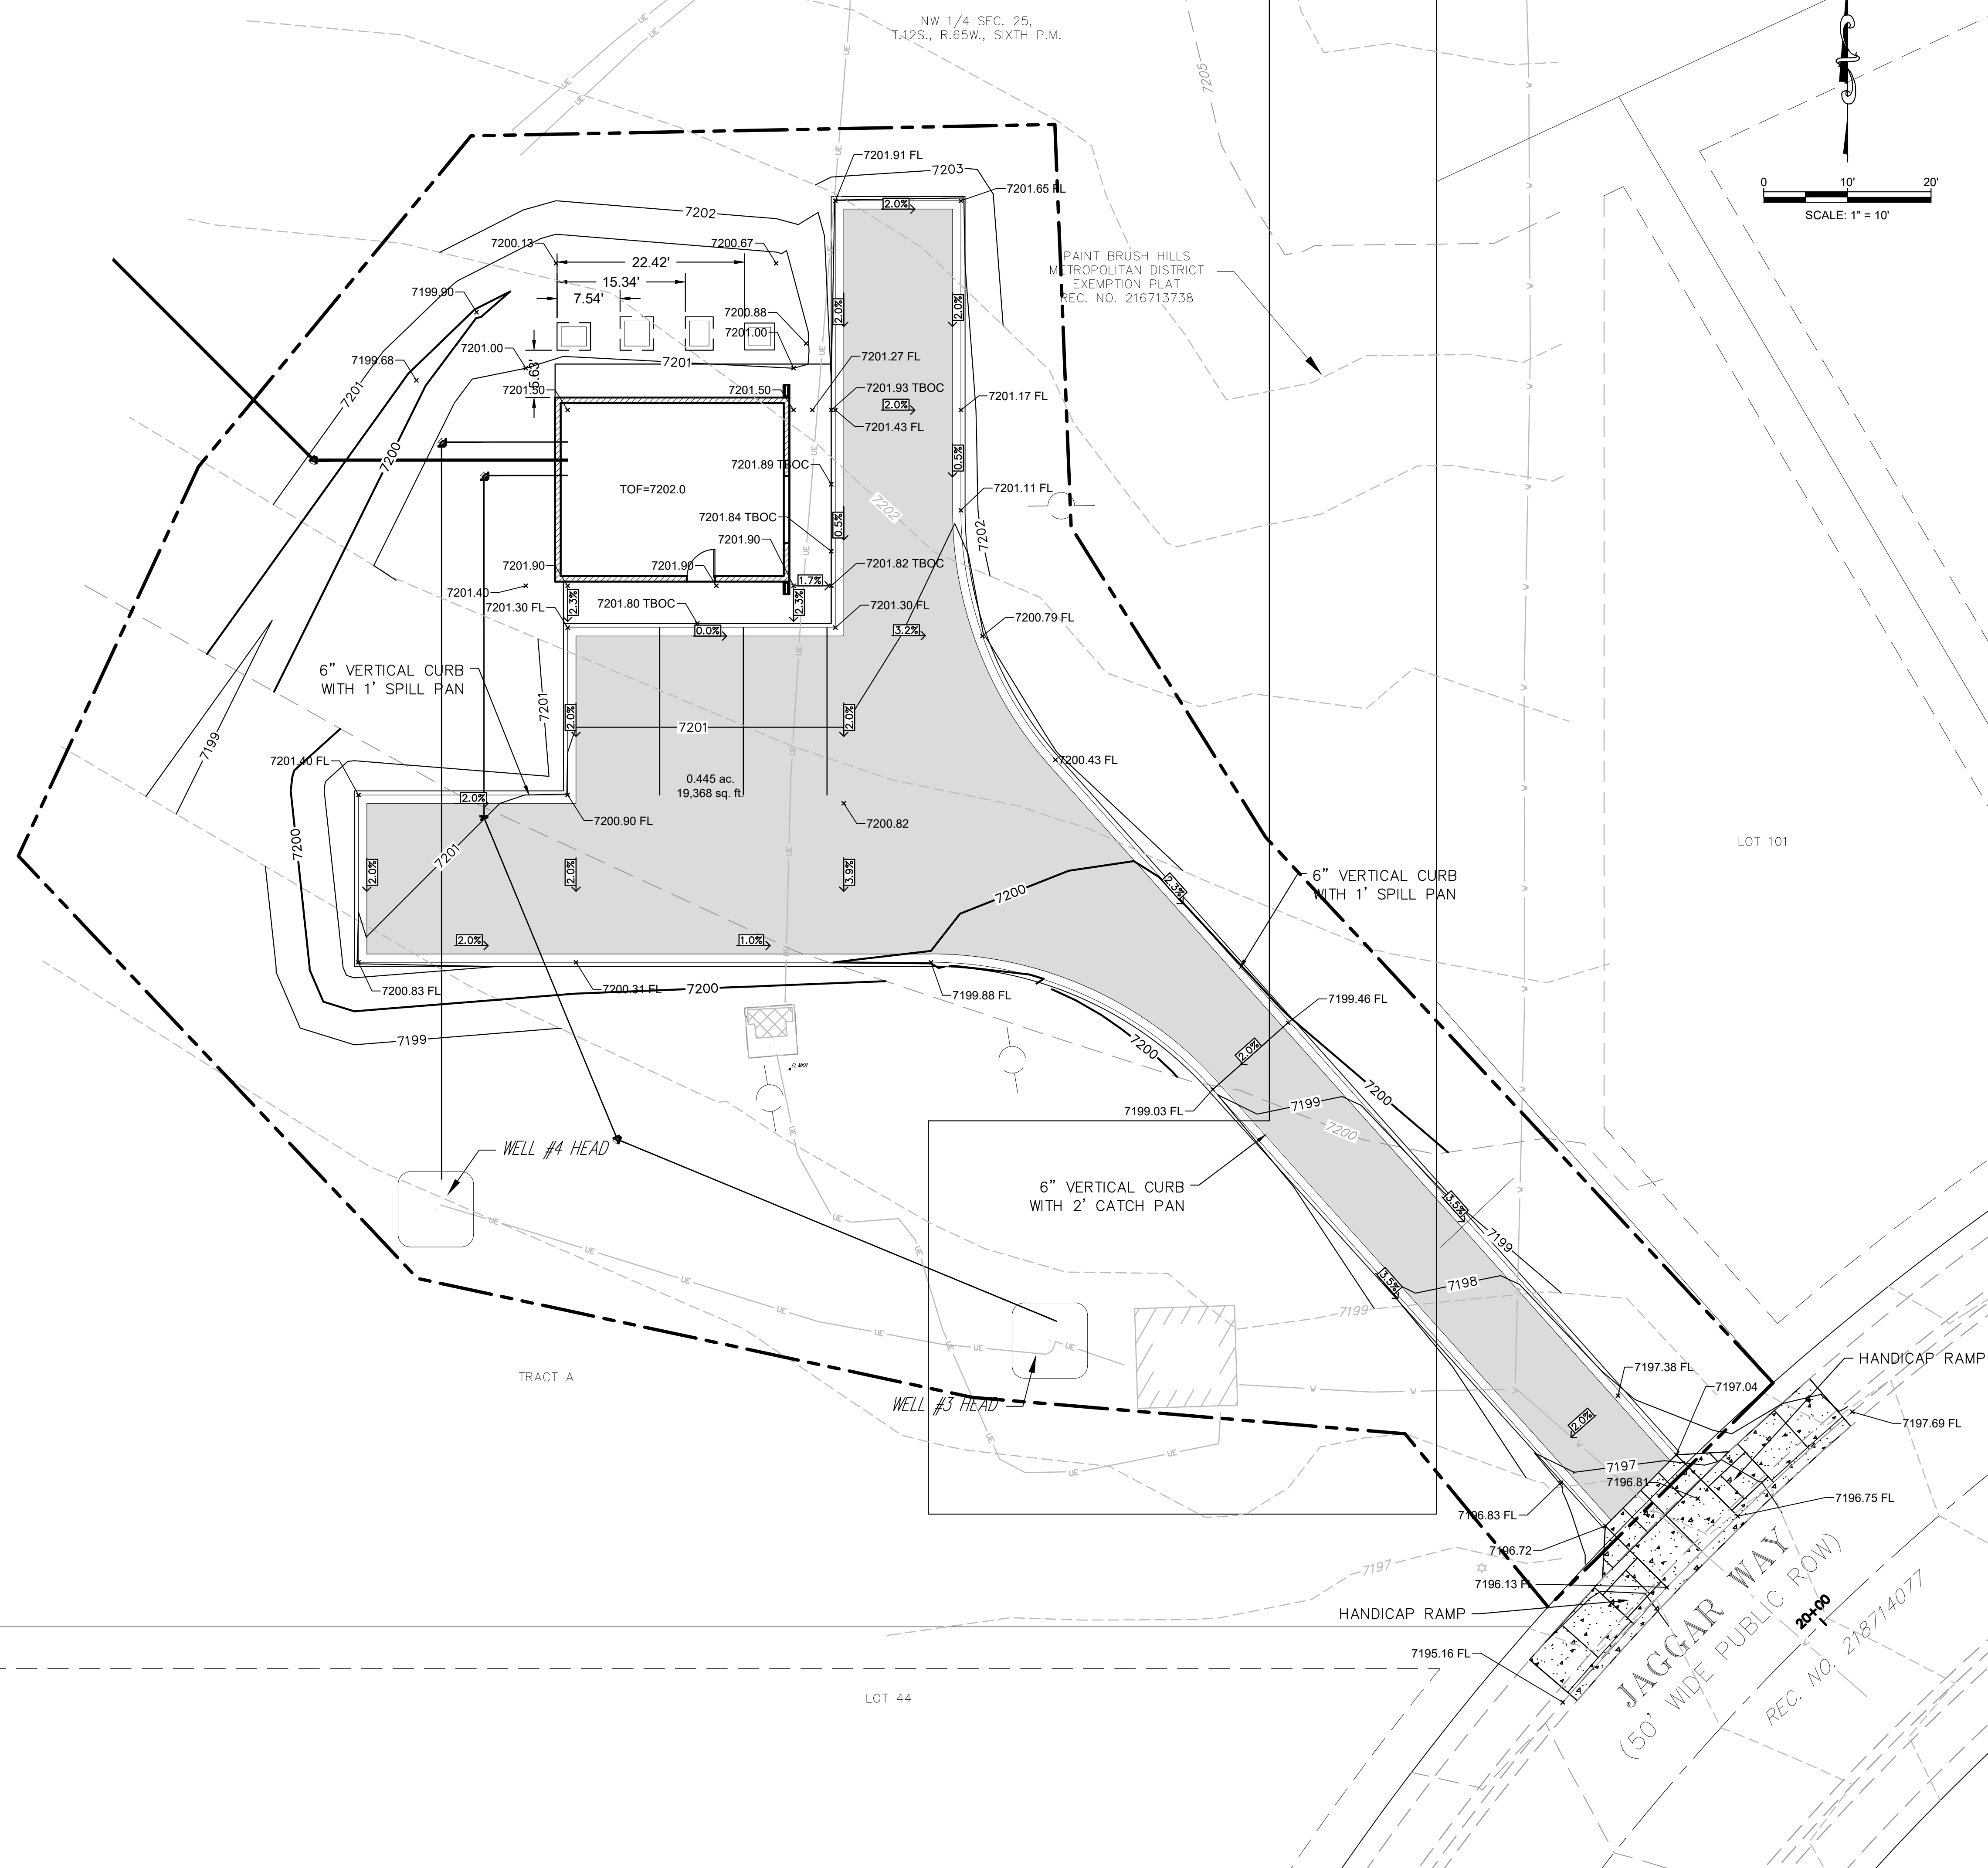


LEGEND

-  EX WATER LINE UNDERGROUND
-  EX WATER VALVE
-  EX ELECTRIC MH
-  EX ELECTRIC MKR
-  EX ELECTRIC TRANSFORMER
-  EX ELECTRIC UNDERGROUND
-  EX LIGHT POLE
-  EX FIBER OPTIC UNDERGROUND
-  EX CABLE TV UNDERGROUND
-  EX GAS LINE UNDERGROUND
-  EX EDGE CONCRETE
-  EX BUILDING
-  EX CONT-MJR
-  EX CONT-MNR
-  PR CONT-MJR
-  PR CONT-MNR
-  EX. ELECTRICAL POLE LOCATION
-  PR CONCRETE



48 hours before you dig. CALL UTILITY NOTIFICATION CENTER OF COLORADO (UNCC) **811**
 Go to: Electric, Telephone, Cable, and Gas. Locate. Mark. Excavate. Eastern Pipeline Locations
SCALE VERIFICATION
 BAR IS ONE INCH ON ORIGINAL DRAWING
 IF NOT ONE INCH ON THIS SHEET SCALE ACCORDINGLY

NO.	REVISIONS	DESCRIPTION	DATE	BY

RG AND ASSOCIATES, LLC
 4885 Ward Road, Suite 100 • Wheat Ridge, CO 80033
 Del Norte • Gypsum • Wheat Ridge
 303-293-8107 • www.rgengineers.com



PAINT BRUSH HILLS PUMP HOUSE
 description
GRADING PLAN
 prepared for
PAINT BRUSH HILLS METROPOLITAN DISTRICT

DRAWN BY:	DESIGNED BY:
JOB NUMBER: 1070.0010	DATE: MARCH, 2019
SCALE: 1" = 10'	DRAWING NAME:
SHEET NO: 5	of 8