


LEGEND

	EX WATER LINE UNDERGROUND
	EX WATER VALVE
	EX ELECTRIC MH
	EX ELECTRIC MKR
	EX ELECTRIC TRANSFORMER
	EX ELECTRIC UNDERGROUND
	EX LIGHT POLE
	EX FIBER OPTIC UNDERGROUND
	EX CABLE TV UNDERGROUND
	EX GAS LINE UNDERGROUND
	EX EDGE CONCRETE
	EX BUILDING
	EX CONT-MJR
	EX CONT-MNR
	PR CONT-MJR
	PR CONT-MNR
	EX. ELECTRICAL POLE LOCATION
	PR CONCRETE
	PR SILT FENCE
	PR VEHICLE TRACKING CONTROL
	PR ROCK SOCK
	PR CHECK DAM
	PR CONCRETE WASHOUT
	PR ASPHALT ROADWAY
	PR 4" PVC WATERLINE

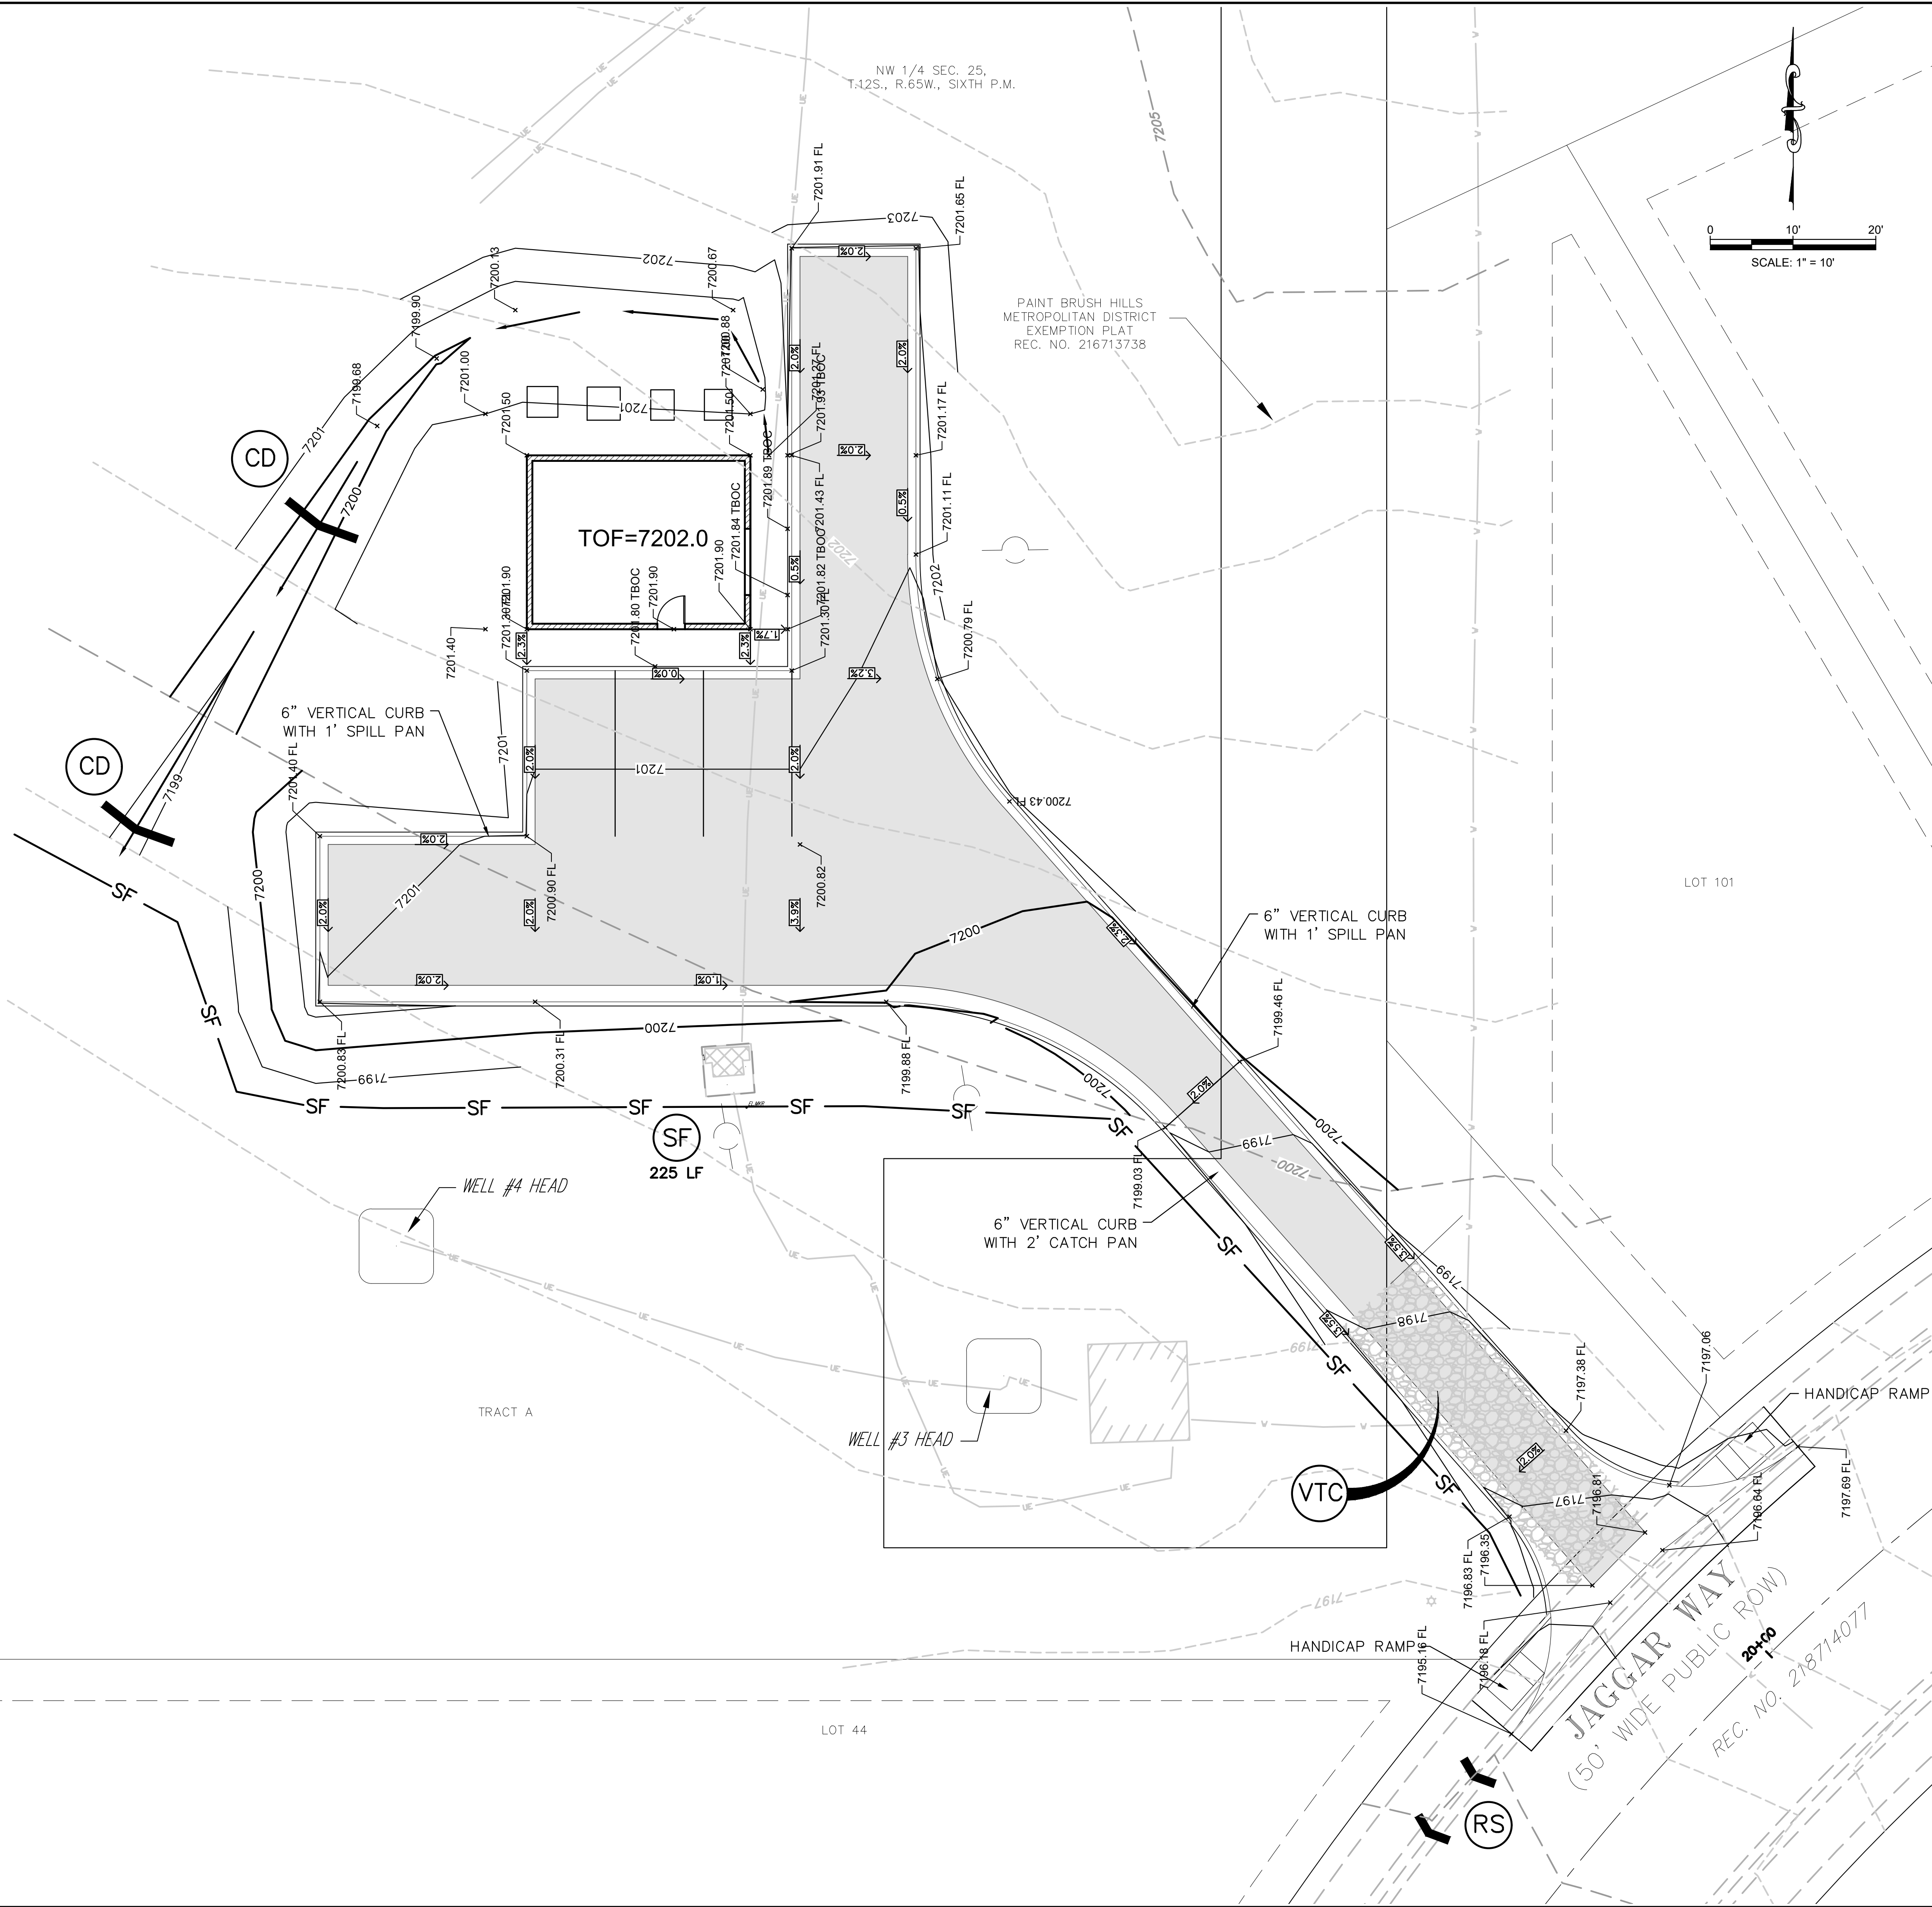

48 hours before you dig. CALL UTILITY NOTIFICATION CENTER OF COLORADO (UNCC)		811		Gas, Electric, Telephone, CATV, and Penetration Eastern Pipeline Locations		SCALE VERIFICATION		BAR IS ONE INCH ON ORIGINAL DRAWING		IF NOT ONE INCH ON THIS SHEET SCALE ACCORDINGLY	
REVISIONS		BY		DATE		DESCRIPTION		NO.			
DRAWN BY:		DESIGNED BY:		JOB NUMBER:		DATE:		SCALE:		DRAWING NAME:	
1070.0010		MARCH, 2019		1"=10'				SHEET NO:		of	
5		8									

RG AND ASSOCIATES, LLC
4885 Ward Road, Suite 100 • Wheat Ridge, CO 80033
Del Norte • Gypsum • Wheat Ridge
303-293-8307 • www.rgengineers.com

PAINT BRUSH HILLS PUMP HOUSE
GRADING PLAN AND EROSION CONTROL PLAN
prepared for
PAINT BRUSH HILLS METROPOLITAN DISTRICT