 


1. THE BASIS OF THE MERIDIANS AND THE COORDINATES FOR THIS PLAT IS THE COLORADO STATE PLAN COORDINATE SYSTEM, NORTH AMERICAN DATUM (NAD 83/2011), BASED ON DIFFERENTIAL GPS OBSERVATIONS PERFORMED ON 04/02/2026 BY RLF CONSULTING.
2. VERTICAL INFORMATION SHOWN, BASED ON THE NORTH AMERICAN VERTICAL DATUM OF 1988 (NAVD '88) IN FEET
3. THE LEASE AREA IS LOCATED IN ZONE "X" DETERMINED TO BE OUTSIDE THE 0.2% ANNUAL CHANCE FLOOD HAZARD, ACCORDING TO FEMA COMMUNITY PANEL #08041C07546, DATED 12/07/2018.
4. ALL DISTANCES ARE GROUND UNLESS OTHERWISE NOTED.
5. CONTRACTOR TO ENSURE POSITIVE DRAINAGE ACROSS COMPOUND.
6. CONTRACTOR SHALL MAINTAIN A MAXIMUM OF 5% SLOPE ACROSS THE COMPOUND.
7. CONTRACTOR SHALL MAINTAIN A MAXIMUM OF 18% SLOPE ACROSS THE ACCESS DRIVE.
8. STORMWATER RUNOFF FROM PROPOSED ANTENNAS WILL NOT ADVERSELY IMPACT DOWNSTREAM/NEIGHBORING PARCELS.



EXISTING SITE PLAN
SCALE: 1" = 60'



TEP IS A FAMILY OF COMPANIES LICENSED TO PROVIDE DIFFERENT SERVICES IN DIFFERENT JURISDICTIONS, DEPENDING ON THE JURISDICTION, PROFESSIONAL ENGINEERING AND LAND SURVEYING SERVICES ARE PROVIDED BY TEP OPCO LLC, A DELAWARE LIMITED LIABILITY COMPANY, TEP ENGINEERING, LLC, A NORTH CAROLINA PROFESSIONAL LIMITED LIABILITY COMPANY, OR M&H ENGINEERING, LLC, A NEW YORK PROFESSIONAL LIMITED LIABILITY COMPANY. GENERAL CONTRACTOR SERVICES ARE PROVIDED BY TEP OPCO LLC, A DELAWARE LIMITED LIABILITY COMPANY. WE ACQUIRE THE REQUISITE LICENSES IN EACH STATE. ADDITIONAL INFORMATION CAN BE OBTAINED FROM THE COMPANY.



NOTES:

1. THE BASIS OF THE MERIDIANS AND THE COORDINATES FOR THIS PLAT IS THE COLORADO STATE PLAN COORDINATE SYSTEM, NORTH AMERICAN DATUM (NAD 83/2011), BASED ON DIFFERENTIAL GPS OBSERVATIONS PERFORMED ON 04/02/2026 BY RLF CONSULTING.
2. VERTICAL INFORMATION SHOWN, BASED ON THE NORTH AMERICAN VERTICAL DATUM OF 1988 (NAVD '88) IN FEET
3. THE LEASE AREA IS LOCATED IN ZONE "X" DETERMINED TO BE OUTSIDE THE 0.2% ANNUAL CHANCE FLOOD HAZARD, ACCORDING TO FEMA COMMUNITY PANEL #08041C0754G, DATED 12/07/2018.
4. ALL DISTANCES ARE GROUND UNLESS OTHERWISE NOTED.
5. CONTRACTOR TO ENSURE POSITIVE DRAINAGE ACROSS COMPOUND.
6. CONTRACTOR SHALL MAINTAIN A MAXIMUM OF 5% SLOPE ACROSS THE COMPOUND.
7. CONTRACTOR SHALL MAINTAIN A MAXIMUM OF 18% SLOPE ACROSS THE ACCESS DRIVE.
8. STORMWATER RUNOFF FROM PROPOSED ANTENNAS WILL NOT ADVERSELY IMPACT DOWNSTREAM/NEIGHBORING PARCELS.

LEGEND	
	PROPOSED EASEMENT
	EXIST. PROPERTY LINE
	ADJ. PROPERTY LINE
	EXIST. UTILITY POLE
	EXIST. TELCO PEDESTAL
	EXIST. FIRE HYDRANT
	EXIST. TRANSFORMER
	EXIST. SEWER DRAIN MAN HOLE
	EXIST. WATER VALVE
	PROPERTY CORNER
	LEASE/EASE. CORNER
	EXIST. CONTOUR LINE
	EDGE OF PAVEMENT
	OVERHEAD WIRE
	RIGHT-OF-WAY
	CHAIN LINK FENCE
	EXISTING TREE LINE
	EXISTING WATER LINE
	EXISTING FIBER LINE
	EXISTING STORM DRAIN LINE
	EXISTING UNDERGROUND ELECTRICAL LINE
	EXISTING UTILITY EASEMENT

PROPOSED SITE PLAN

 SCALE: 1" = 60'

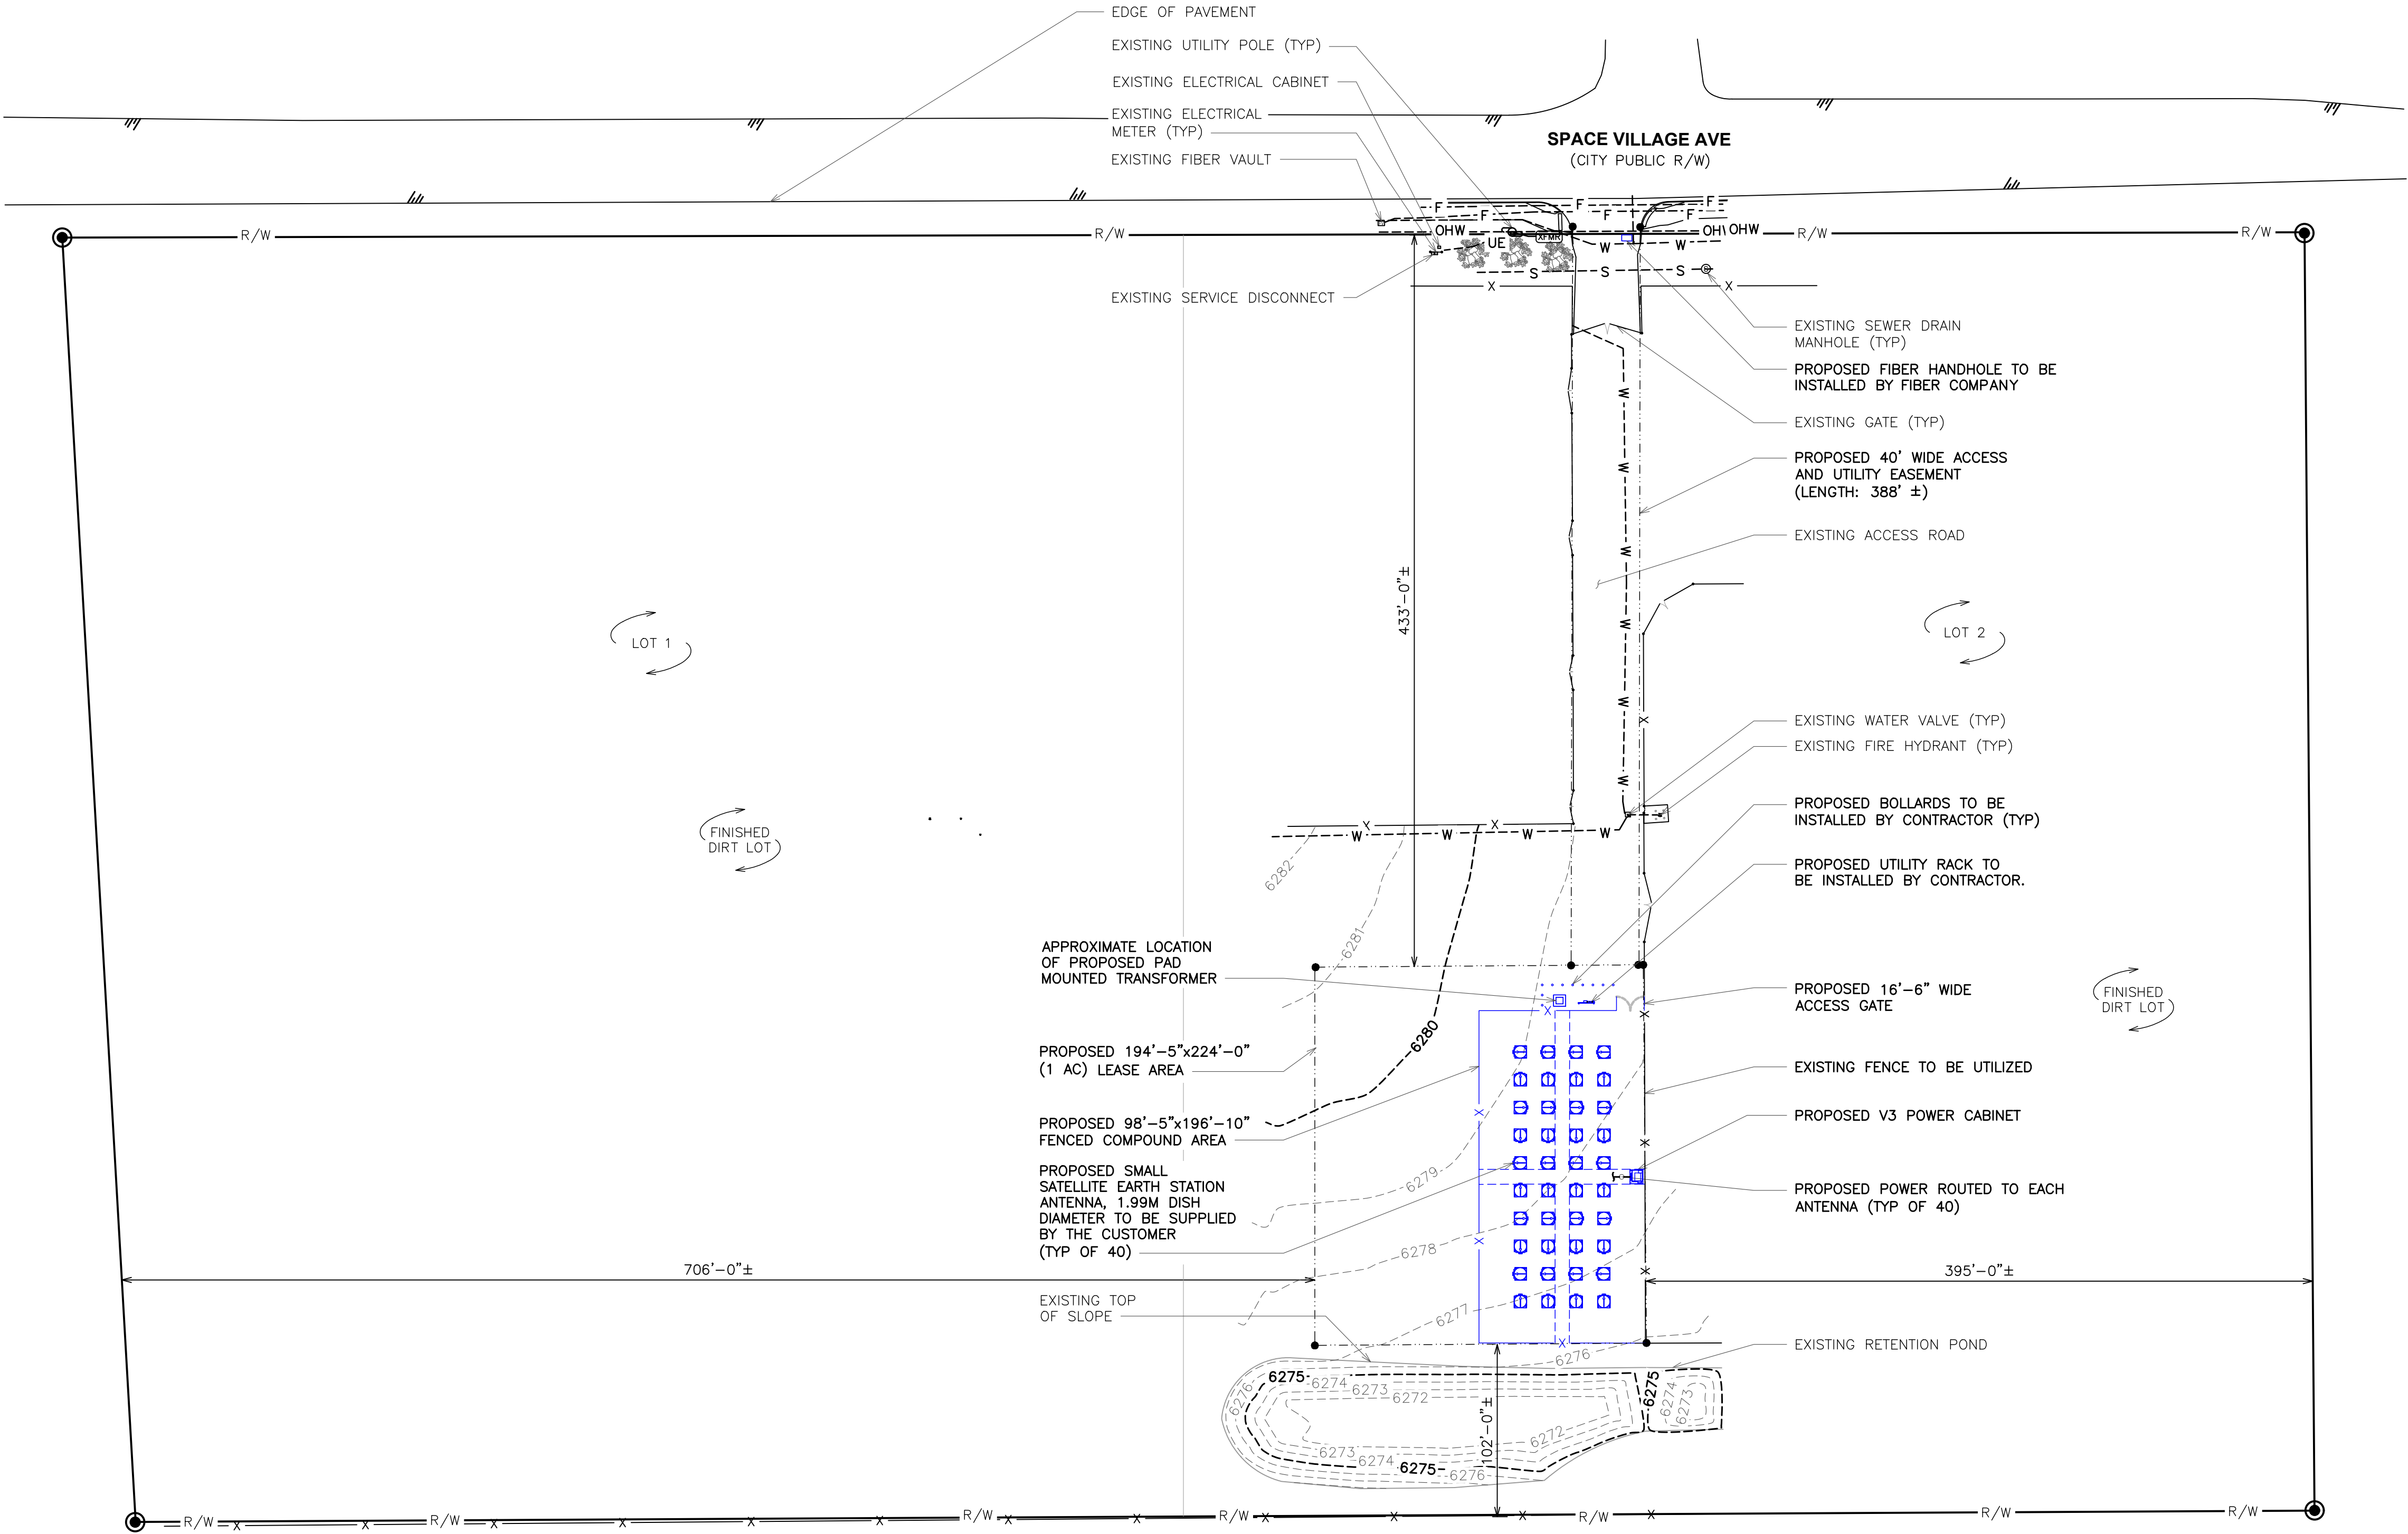

PLANS PREPARED BY:

4	08-05-26	CONSTRUCTION
3	06-09-26	CONSTRUCTION
2	06-03-26	CONSTRUCTION
1	05-15-26	CONSTRUCTION
0	04-01-26	CONSTRUCTION
B	03-30-26	PRELIMINARY
REV	DATE	ISSUED FOR:
DRAWN BY: OJK	CHECKED BY: JFJ	

PROJECT INFORMATION:

SITE NAME:
COLORADO SPRINGS,
CO - 100KM
7233 SPACE VILLAGE AVE.
COLORADO SPRINGS, CO 80914
(EL PASO COUNTY)

SEAL:



08-05-26

PROPOSED SITE PLAN

 
REVISION: 4

SHEET NUMBER: **C-1.2**

TEP IS A FAMILY OF COMPANIES LICENSED TO PROVIDE DIFFERENT SERVICES IN DIFFERENT JURISDICTIONS, DEPENDING ON THE JURISDICTION, PROFESSIONAL ENGINEERING AND LAND SURVEYING SERVICES ARE PROVIDED BY TEP OPKO LLC, A DELAWARE LIMITED LIABILITY COMPANY, TEP ENGINEERING, LLC, A NORTH CAROLINA PROFESSIONAL LIMITED LIABILITY COMPANY, OR M&H ENGINEERING, LLC, A NEW YORK PROFESSIONAL LIMITED LIABILITY COMPANY. GENERAL CONTRACTOR SERVICES ARE PROVIDED BY TEP OPKO LLC, A DELAWARE LIMITED LIABILITY COMPANY. WE ACQUIRE THE REQUISITE LICENSES IN EACH STATE. ADDITIONAL INFORMATION CAN BE OBTAINED FROM THE COMPANY.

NOTES:

1. THE BASIS OF THE MERIDIANS AND THE COORDINATES FOR THIS PLAT IS THE COLORADO STATE PLAN COORDINATE SYSTEM, NORTH AMERICAN DATUM (NAD 83/2011), BASED ON DIFFERENTIAL GPS OBSERVATIONS PERFORMED ON 04/02/2026 BY RLF CONSULTING.
2. VERTICAL INFORMATION SHOWN, BASED ON THE NORTH AMERICAN VERTICAL DATUM OF 1988 (NAVD '88) IN FEET
3. THE LEASE AREA IS LOCATED IN ZONE "X" DETERMINED TO BE OUTSIDE THE 0.2% ANNUAL CHANCE FLOOD HAZARD, ACCORDING TO FEMA COMMUNITY PANEL #08041C0754G, DATED 12/07/2018.
4. ALL DISTANCES ARE GROUND UNLESS OTHERWISE NOTED.
5. CONTRACTOR TO ENSURE POSITIVE DRAINAGE ACROSS COMPOUND.
6. CONTRACTOR SHALL MAINTAIN A MAXIMUM OF 5% SLOPE ACROSS THE COMPOUND.
7. CONTRACTOR SHALL MAINTAIN A MAXIMUM OF 18% SLOPE ACROSS THE ACCESS DRIVE.
8. STORMWATER RUNOFF FROM PROPOSED ANTENNAS WILL NOT ADVERSELY IMPACT DOWNSTREAM/NEIGHBORING PARCELS.



326 TRYON ROAD
RALEIGH, NC 27603-3330
OFFICE (919) 861-6331
FAX (919) 861-6350



PLANS PREPARED BY:

CONSTRUCTION	08-05-26	4
CONSTRUCTION	06-09-26	3
CONSTRUCTION	06-03-26	2
CONSTRUCTION	05-15-26	1
CONSTRUCTION	04-01-26	0
PRELIMINARY	03-30-26	B
ISSUED FOR:	DATE	REV
CHECKED BY:	DATE	REV
JFJ		

PROJECT INFORMATION:

SITE NAME:
COLORADO SPRINGS,
CO - 100KM
7233 SPACE VILLAGE AVE.
COLORADO SPRINGS, CO 80914
(EL PASO COUNTY)

SEAL:



08-05-26


SHEET TITLE:

PROPOSED
COMPOUND LAYOUT

SHEET NUMBER:
C-2.1

REVISION:
4

TEP IS A FAMILY OF COMPANIES LICENSED TO PROVIDE DIFFERENT SERVICES IN DIFFERENT JURISDICTIONS. DEPENDING ON THE JURISDICTION, PROFESSIONAL ENGINEERING AND LAND SURVEYING SERVICES ARE PROVIDED BY TEP OPCO LLC, A DELAWARE LIMITED LIABILITY COMPANY, TEP ENGINEERING, LLC, A NORTH CAROLINA PROFESSIONAL LIMITED LIABILITY COMPANY, OR M&H ENGINEERING, LLC, A NEW YORK PROFESSIONAL LIMITED LIABILITY COMPANY. GENERAL CONTRACTOR SERVICES ARE PROVIDED BY TEP OPCO LLC, A DELAWARE LIMITED LIABILITY COMPANY. WE ACQUIRE THE REQUISITE LICENSES IN EACH STATE. ADDITIONAL INFORMATION CAN BE OBTAINED FROM THE COMPANY.

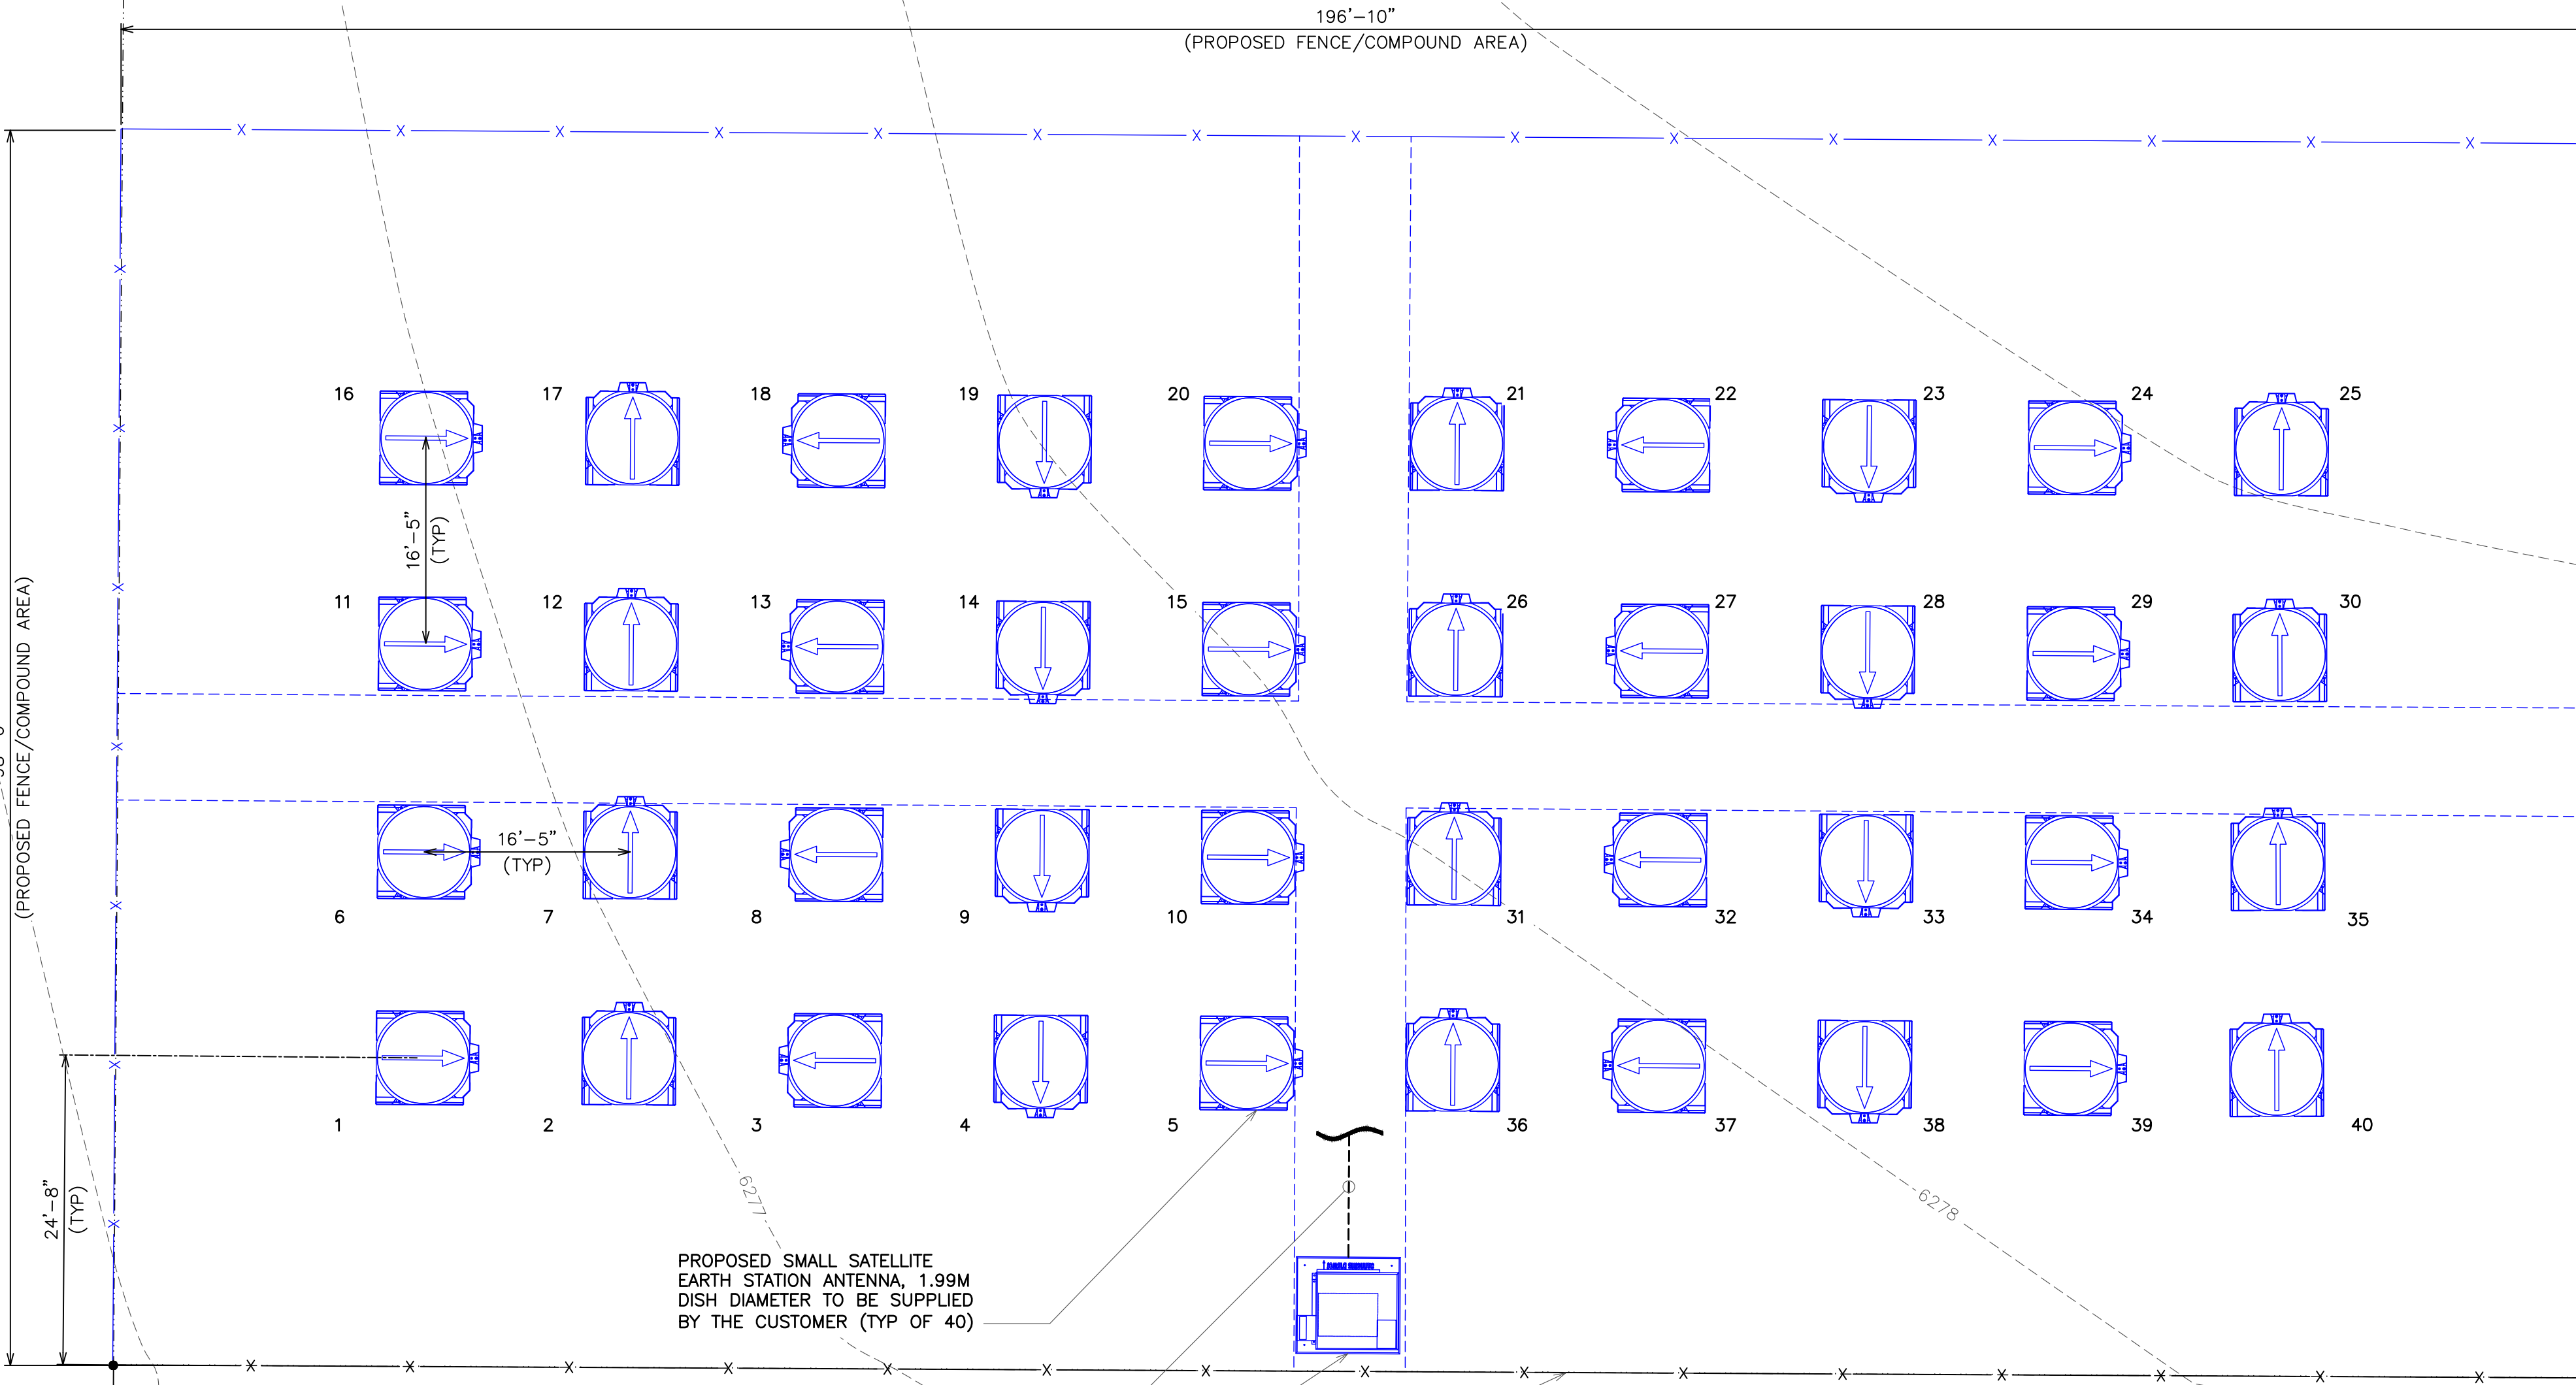

PROPOSED 194'-5"x224'-0"
(1 AC) LEASE AREA

PROPOSED 98'-5"x196'-10"
FENCED COMPOUND AREA

APPROXIMATE LOCATION
OF PROPOSED PAD
MOUNTED TRANSFORMER

PROPOSED BOLLARDS
TO BE INSTALLED BY
THE CONTRACTOR (TYP)

PROPOSED UTILITY RACK TO BE
INSTALLED BY CONTRACTOR.

PROPOSED 16'-6" WIDE
ACCESS GATE

PROPOSED SMALL SATELLITE
EARTH STATION ANTENNA, 1.99M
DISH DIAMETER TO BE SUPPLIED
BY THE CUSTOMER (TYP OF 40)

 
PROPOSED POWER ROUTED TO
EACH ANTENNA (TYP OF 40)

PROPOSED V3
POWER CABINET

EXISTING FENCE TO BE UTILIZED



PROPOSED COMPOUND LAYOUT

SCALE: 1" = 10'



PROPOSED COMPOUND ELEVATION

 SCALE: 1/8" = 1'-0"

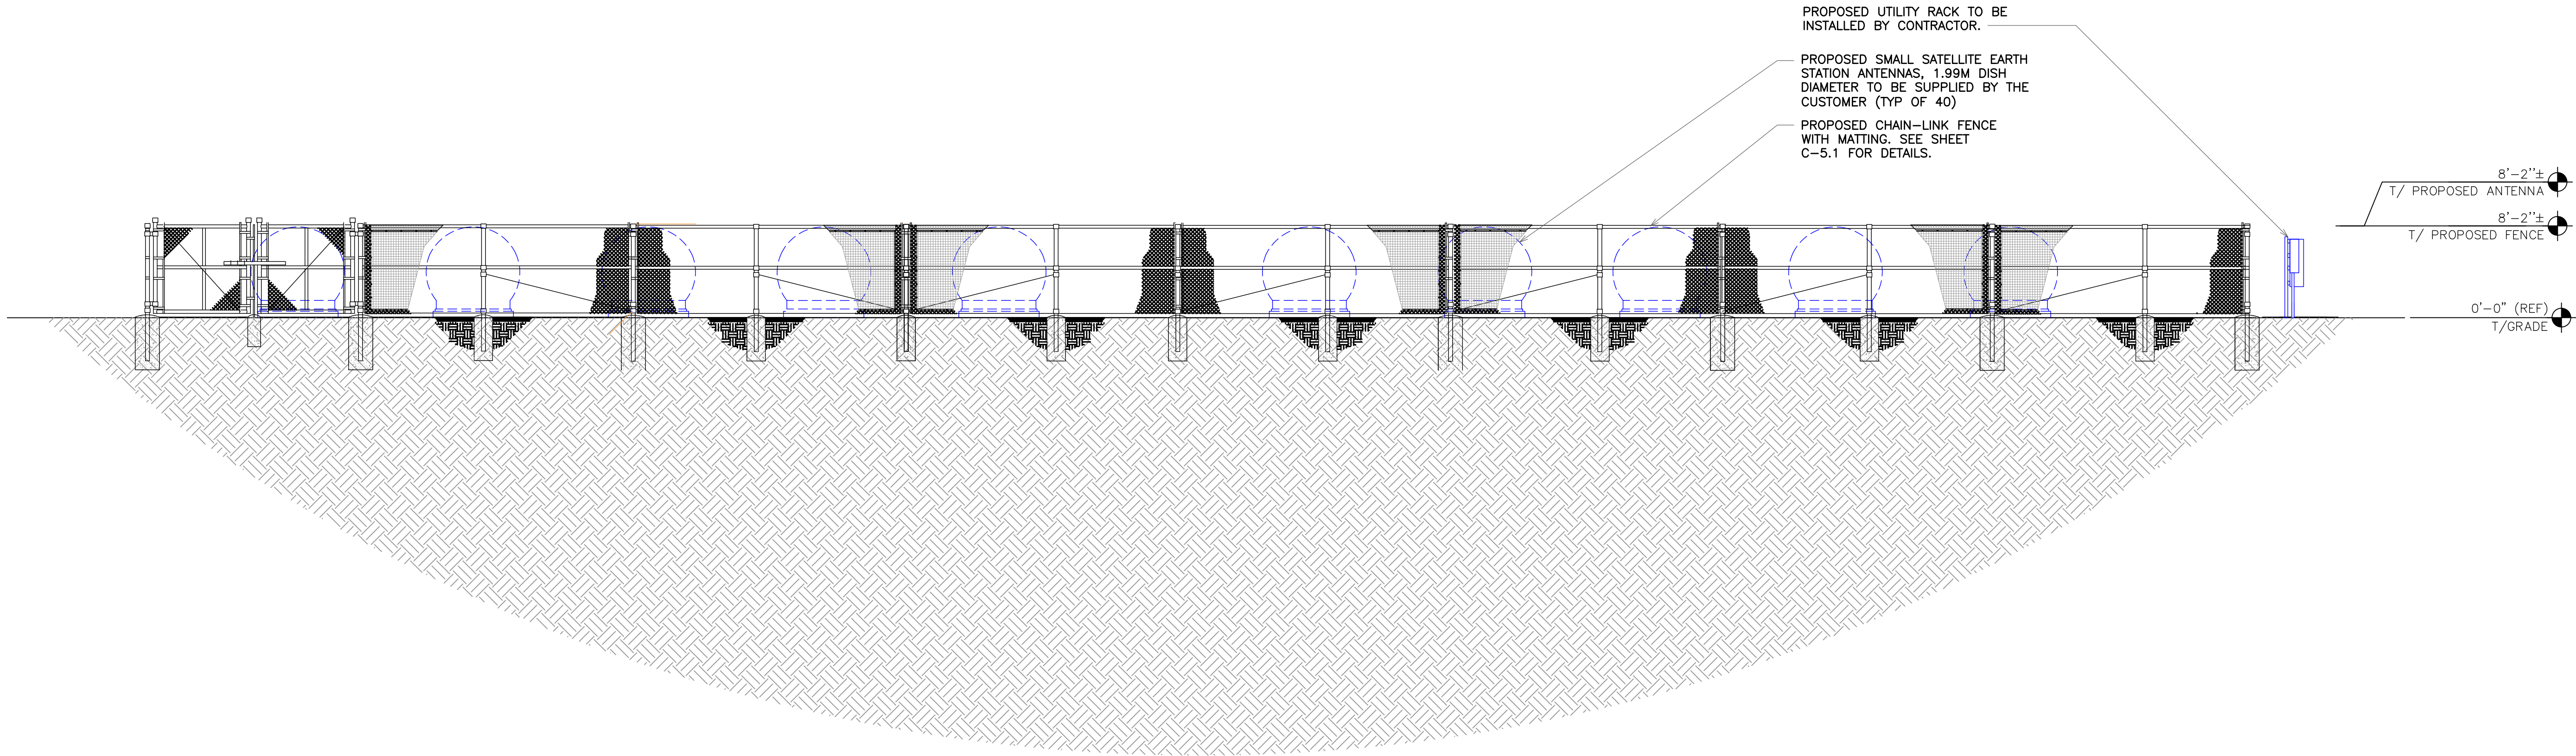

SHEET TITLE:

COMPOUND
ELEVATION

SHEET NUMBER:

C-3.1

REVISION:

4

TEP # 353465.490368

SEAL:



08-05-26


PROJECT INFORMATION:

SITE NAME:
COLORADO SPRINGS,
CO - 100KM

7233 SPACE VILLAGE AVE,
COLORADO SPRINGS, CO 80914
(EL PASO COUNTY)

PLANS PREPARED BY:

4	08-05-26	CONSTRUCTION
3	06-09-26	CONSTRUCTION
2	06-03-26	CONSTRUCTION
1	05-15-26	CONSTRUCTION
0	04-01-26	CONSTRUCTION
B	03-30-26	PRELIMINARY
REV	DATE	ISSUED FOR:
DRAWN BY:	OJK	CHECKED BY: JFJ

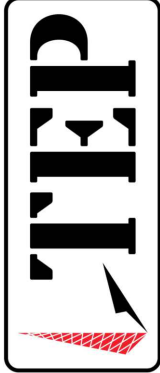


326 TRYON ROAD
RALEIGH, NC 27603-3530
OFFICE (919) 861-6351
FAX (919) 861-6350

TEP IS A FAMILY OF COMPANIES LICENSED TO PROVIDE DIFFERENT SERVICES IN DIFFERENT JURISDICTIONS, DEPENDING ON THE JURISDICTION, PROFESSIONAL ENGINEERING AND LAND SURVEYING SERVICES ARE PROVIDED BY TEP OPCO LLC, A DELAWARE LIMITED LIABILITY COMPANY, TEP ENGINEERING, LLC, A NORTH CAROLINA PROFESSIONAL LIMITED LIABILITY COMPANY, OR M&H ENGINEERING, LLC, A NEW YORK PROFESSIONAL LIMITED LIABILITY COMPANY. GENERAL CONTRACTOR SERVICES ARE PROVIDED BY TEP OPCO LLC, A DELAWARE LIMITED LIABILITY COMPANY. WE ACQUIRE THE REQUISITE LICENSES IN EACH STATE. ADDITIONAL INFORMATION CAN BE OBTAINED FROM THE COMPANY.

NOTES:


1. FILTER FABRIC SHALL CONFORM TO THE REQUIREMENTS LISTED IN ASTM D 6461.
2. ENDS OF INDIVIDUAL FILTER FABRIC SHALL BE SECURELY FASTENED AT A SUPPORT POST WITH 4 FEET MINIMUM OVERLAP TO THE NEXT POST.
3. PLACE 10 INCHES OF FABRIC ALONG THE BOTTOM AND SIDE OF THE TRENCH.
4. INSPECT SEDIMENT FENCE(S) AT LEAST ONCE A WEEK AND AFTER EACH RAINFALL.
5. REMOVE SEDIMENT DEPOSITS AS NECESSARY TO PROVIDE ADEQUATE STORAGE VOLUME FOR THE NEXT RAIN AND TO REDUCE PRESSURE ON THE FENCE.
6. AFTER CONSTRUCTION IS COMPLETE, THE CONTRACTOR SHALL REMOVE ALL FENCING MATERIALS AND UNSTABLE SEDIMENT DEPOSITS, BRING THE AREA TO GRADE AND PROPERLY STABILIZE THE SITE.

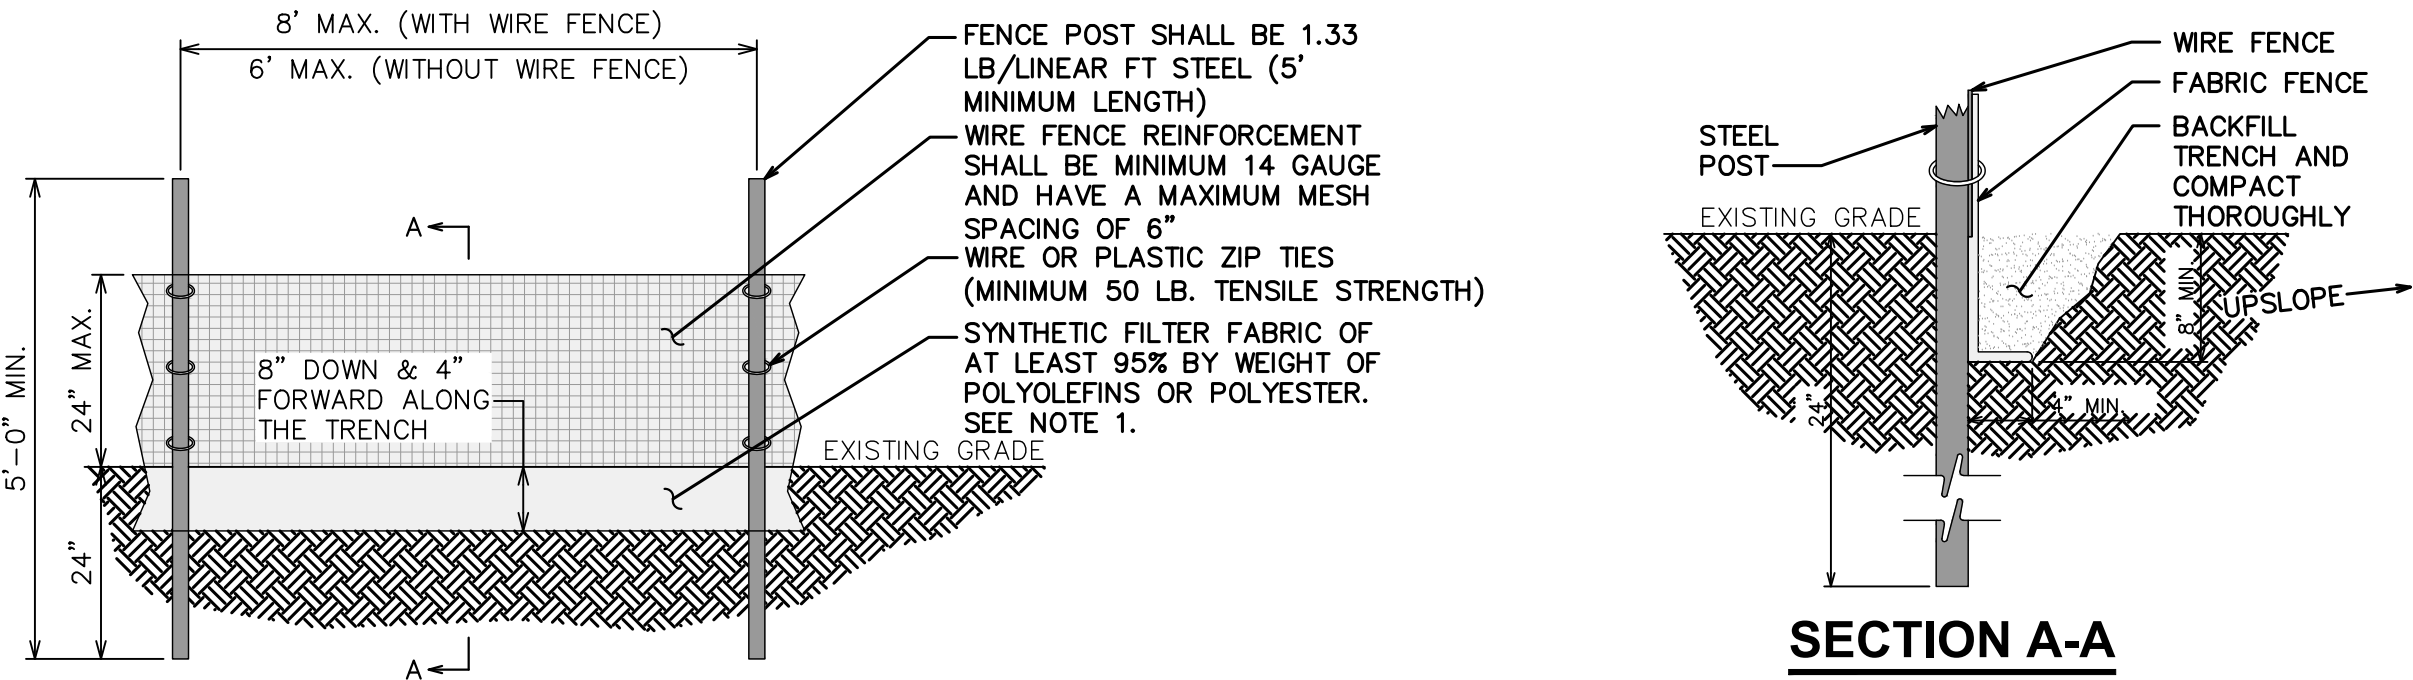

SILT FENCE DETAIL

SCALE: N.T.S.

SILT FENCE WATTLE BREAK DETAIL

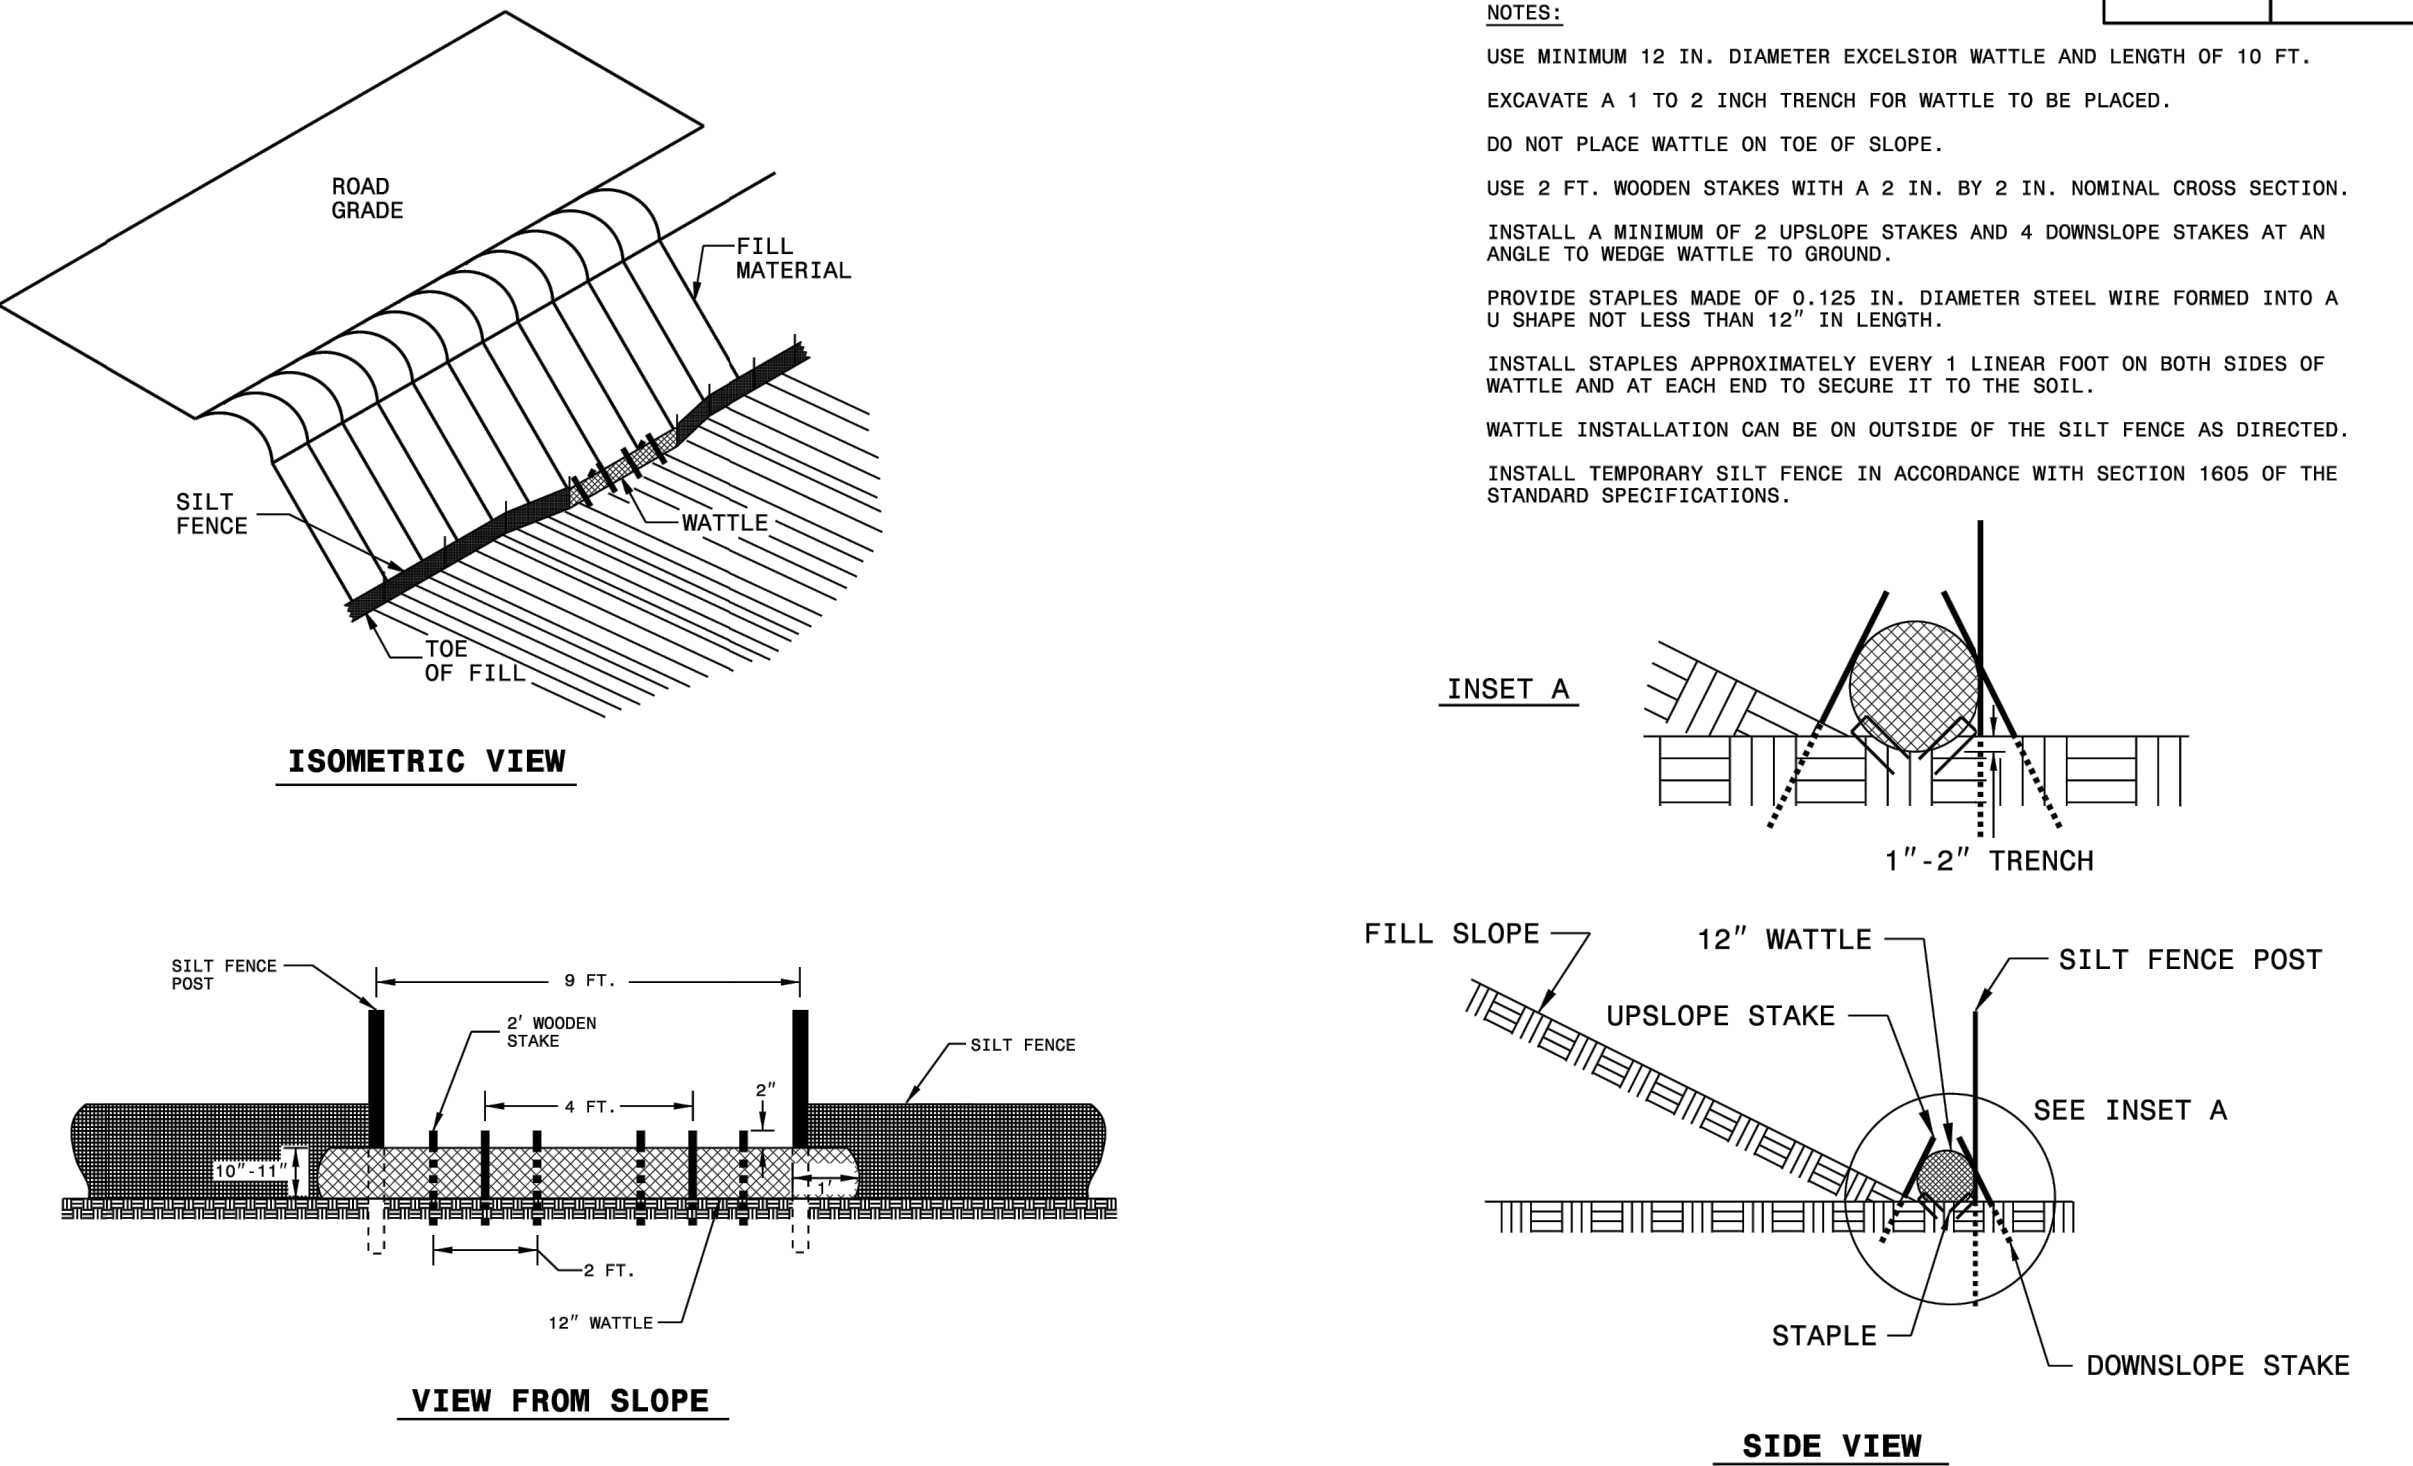

SILT FENCE WATTLE BREAK DETAIL

SCALE: N.T.S.

PLANS PREPARED BY:

08-05-26	CONSTRUCTION
06-08-26	CONSTRUCTION
06-03-26	CONSTRUCTION
05-15-26	CONSTRUCTION
04-01-26	CONSTRUCTION
03-30-26	PRELIMINARY
REV	DATE
ISSUED FOR:	
CHECKED BY: JFJ	

PROJECT INFORMATION:

SITE NAME:
COLORADO SPRINGS,
CO - 100KM
7233 SPACE VILLAGE AVE.
COLORADO SPRINGS, CO 80914
(EL PASO COUNTY)

SEAL:



08-05-26

SHEET TITLE:

SILT FENCE
DETAILS

SHEET NUMBER:

C-4.2

REVISION:

4

TEP IS A FAMILY OF COMPANIES LICENSED TO PROVIDE DIFFERENT SERVICES IN DIFFERENT JURISDICTIONS, DEPENDING ON THE JURISDICTION, PROFESSIONAL ENGINEERING AND LAND SURVEYING SERVICES ARE PROVIDED BY TEP OPCO LLC, A DELAWARE LIMITED LIABILITY COMPANY, TEP ENGINEERING, LLC, A NORTH CAROLINA PROFESSIONAL LIMITED LIABILITY COMPANY, OR M&H ENGINEERING, LLC, A NEW YORK PROFESSIONAL LIMITED LIABILITY COMPANY. GENERAL CONTRACTOR SERVICES ARE PROVIDED BY TEP OPCO LLC, A DELAWARE LIMITED LIABILITY COMPANY. WE ACQUIRE THE REQUISITE LICENSES IN EACH STATE. ADDITIONAL INFORMATION CAN BE OBTAINED FROM THE COMPANY.

NOTES:

1. CONTRACTOR TO ENSURE POSITIVE DRAINAGE ACROSS COMPOUND.
2. CONTRACTOR SHALL MAINTAIN A MAXIMUM OF 5% SLOPE ACROSS THE COMPOUND.
3. CONTRACTOR SHALL MAINTAIN A MAXIMUM OF 18% SLOPE ACROSS THE ACCESS DRIVE.
4. FIBER AND POWER NOT DOWN FOR CLARITY.
5. EQUIPMENT NOT SHOWN FOR CLARITY.
6. STORMWATER RUNOFF FROM PROPOSED ANTENNAS WILL NOT ADVERSELY IMPACT DOWNSTREAM/NEIGHBORING PARCELS.
7. THE PROPOSED CONCRETE FOUNDATIONS WILL NOT AFFECT THE FUNCTIONALITY OF THE EXISTING POND. SEE TABLES BELOW FOR DETAILS

EXISTING WEIGHTED RUNOFF COEFFICIENT

BASIN	COMM.	RESIDENTIAL	IND. LIGHT	GRAVEL	PAVED	LAWNS	TOTAL	I	C ₃	C ₁₀	C ₁₀₀
B1	0.00	0.00	0.0	8.12	0.08	1.25	9.45	70	0.52	0.57	0.66

PROPOSED WEIGHTED RUNOFF COEFFICIENT


BASIN	COMM.	RESIDENTIAL	IND. LIGHT	GRAVEL	PAVED	LAWNS	TOTAL	I	C ₃	C ₁₀	C ₁₀₀
B1	0.00	0.00	0.0	8.06	0.14	1.25	9.45	70	0.53	0.57	0.66

EXISTING SITE STORMWATER PEAK RUN OFF VALUES

STORM FREQUENCY	AREA	RUNOFF COEFFICIENT	TC	CA	I	Q
5-YEAR	9.45 AC	0.52	15	4.96	3.4	16.86
10-YEAR	9.45 AC	0.57	15	5.37	4.0	21.49
100-YEAR	9.45 AC	0.66	15	6.19	5.8	35.93

PROPOSED SITE STORMWATER PEAK RUN OFF VALUES

STORM FREQUENCY	AREA	RUNOFF COEFFICIENT	TC	CA	I	Q
5-YEAR	9.45 AC	0.53	15	5.00	3.4	17.02
10-YEAR	9.45 AC	0.57	15	5.37	4.0	21.49
100-YEAR	9.45 AC	0.66	15	6.19	5.8	35.93

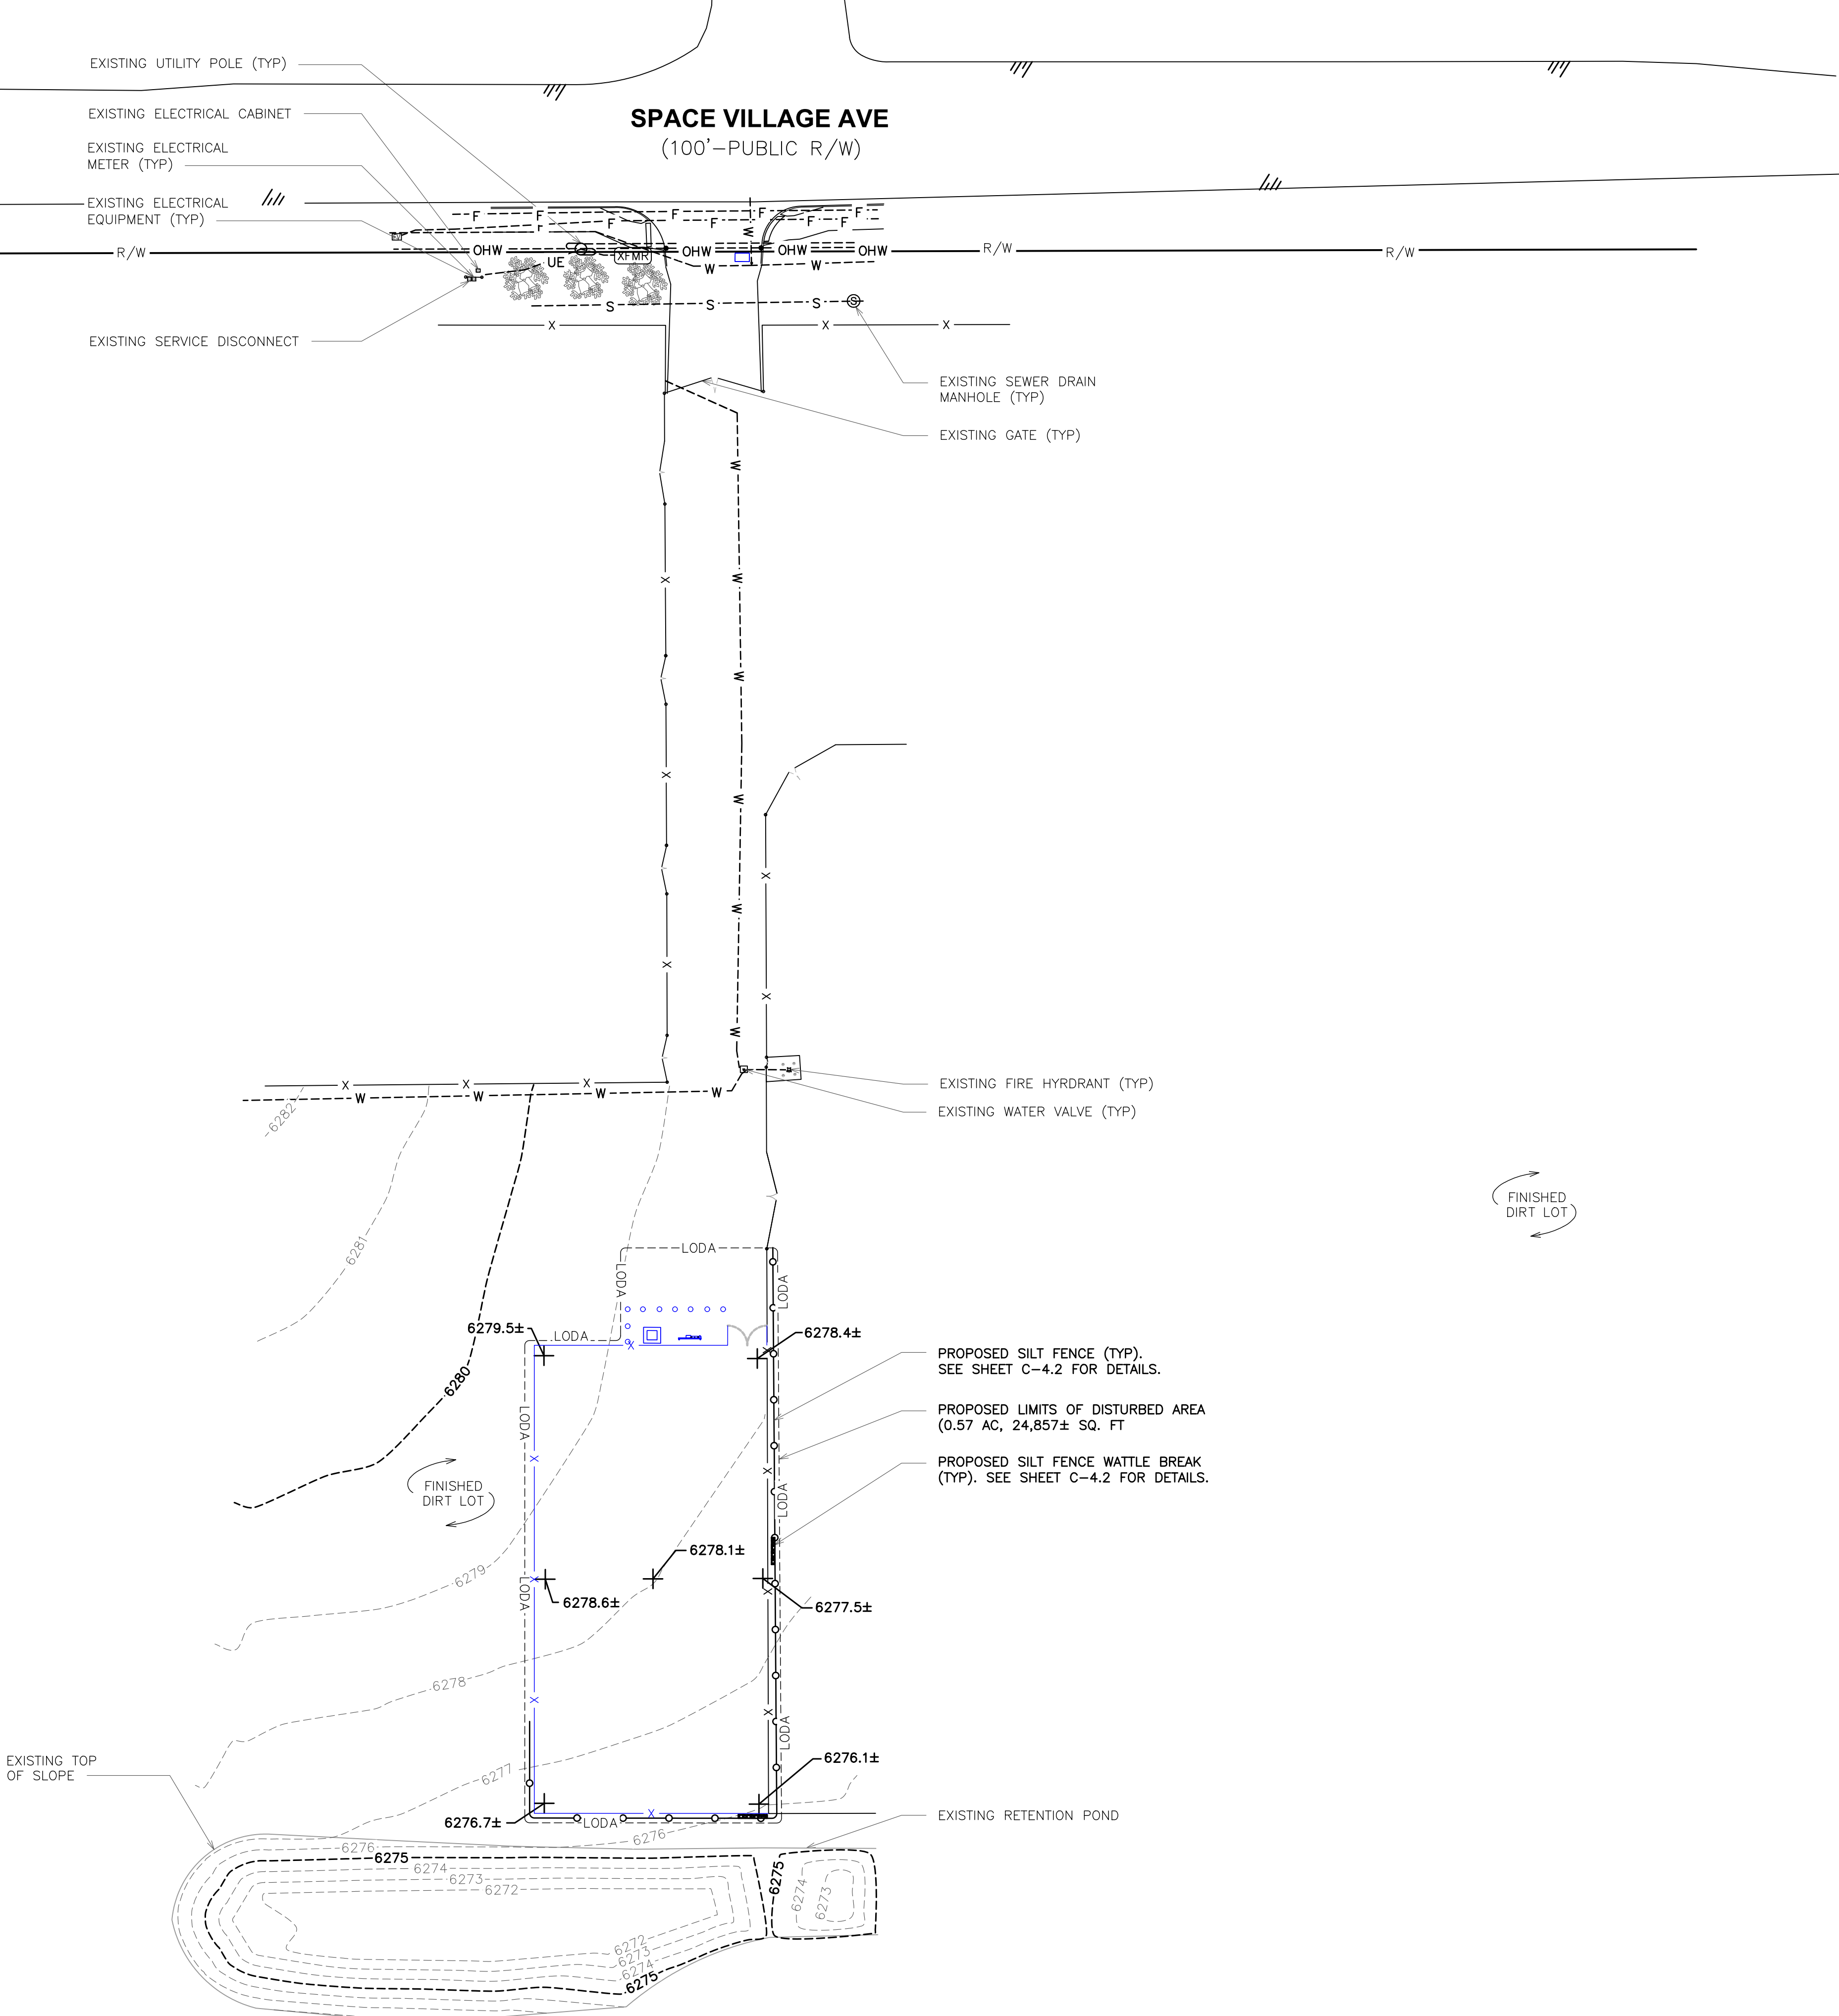

EROSION CONTROL PLAN

SCALE: 1" = 40'



PLANS PREPARED BY:

CONSTRUCTION	08-05-26
CONSTRUCTION	06-08-26
CONSTRUCTION	06-03-26
CONSTRUCTION	05-15-26
CONSTRUCTION	04-01-26
PRELIMINARY	03-30-26
ISSUED FOR:	DATE
CHECKED BY:	JFJ

PROJECT INFORMATION:

SITE NAME:
COLORADO SPRINGS,
CO - 100KM
7233 SPACE VILLAGE AVE,
COLORADO SPRINGS, CO 80914
(EL PASO COUNTY)

SEAL:



08-05-26

SHEET TITLE:

EROSION CONTROL PLAN

REVISION:

4


SHEET NUMBER:

C-4.1

TEP IS A FAMILY OF COMPANIES LICENSED TO PROVIDE DIFFERENT SERVICES IN DIFFERENT JURISDICTIONS, DEPENDING ON THE JURISDICTION, PROFESSIONAL ENGINEERING AND LAND SURVEYING SERVICES ARE PROVIDED BY TEP OP&C LLC, A DELAWARE LIMITED LIABILITY COMPANY, TEP ENGINEERING, LLC, A NORTH CAROLINA PROFESSIONAL LIMITED LIABILITY COMPANY, OR M&H ENGINEERING, LLC, A NEW YORK PROFESSIONAL LIMITED LIABILITY COMPANY. GENERAL CONTRACTOR SERVICES ARE PROVIDED BY TEP OP&C LLC, A DELAWARE LIMITED LIABILITY COMPANY. WE ACQUIRE THE REQUISITE LICENSES IN EACH STATE. ADDITIONAL INFORMATION CAN BE OBTAINED FROM THE COMPANY.


NOTES:

1. ALL STUB-UP CONDUITS INSIDE PULL BOXES WILL BE 6" FROM TOP OF BOX AND HAVE PULL STRING AND CAPS.
2. CONTRACTOR TO DETERMINE SIZE OF PULL BOX BASED ON FIELD CONDITIONS, NUMBER OF CONDUITS REQUIRED & NEC REQUIREMENTS.

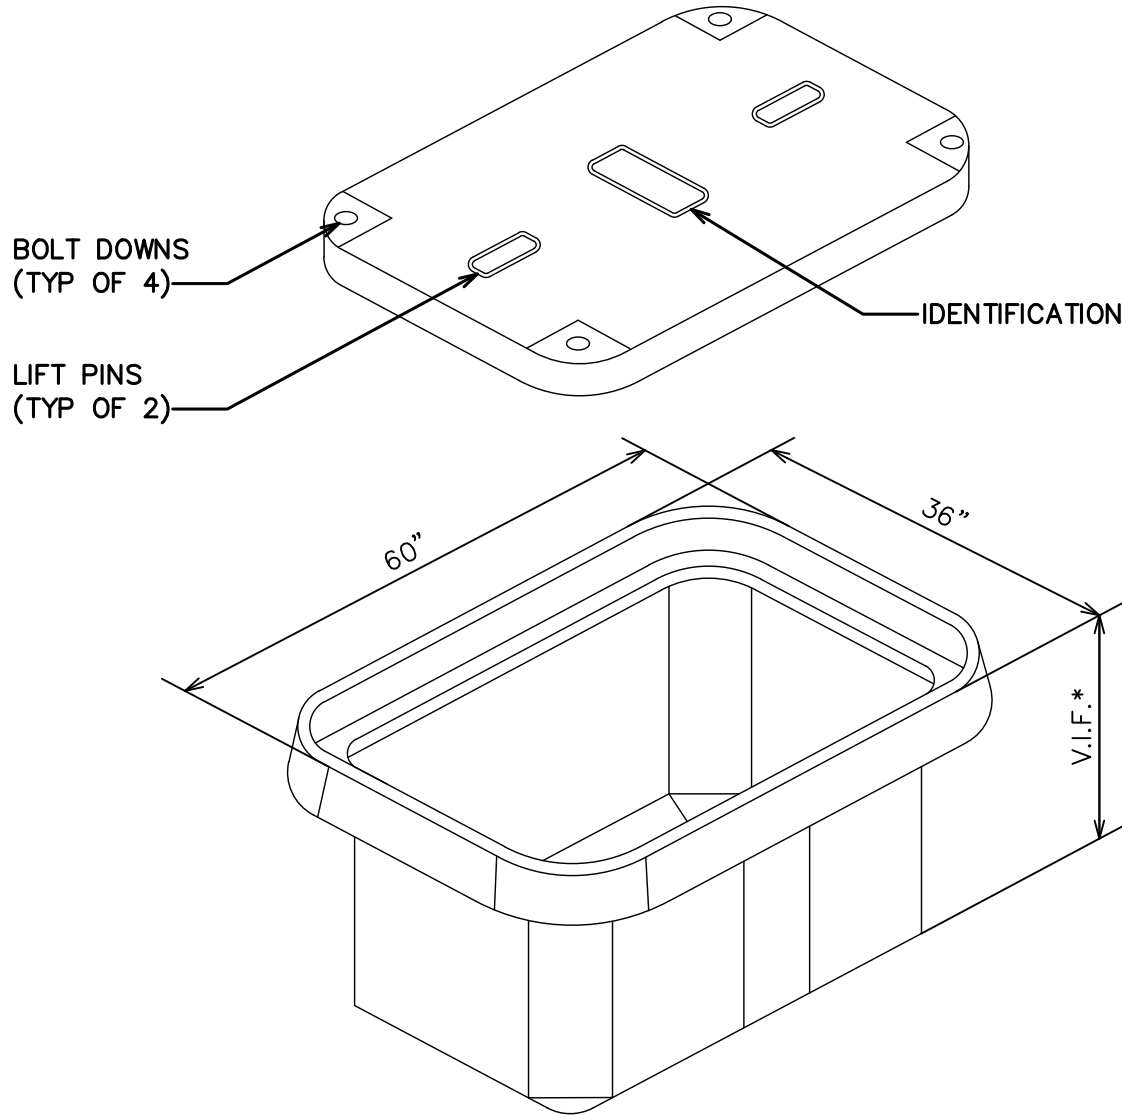


HAND HOLE/PULL BOX DETAIL

SCALE: N.T.S

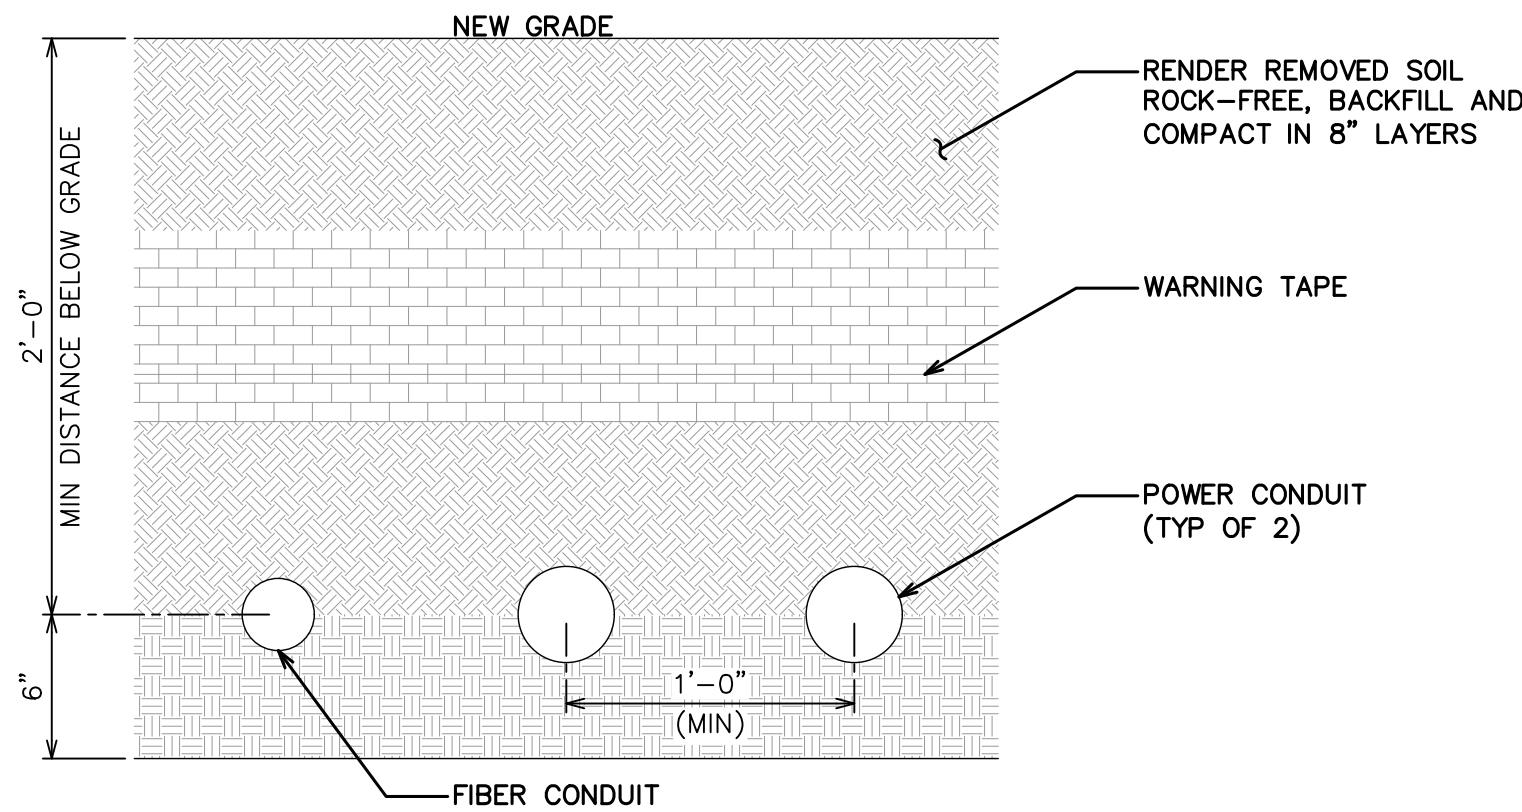


TRENCH DETAIL

SCALE: N.T.S

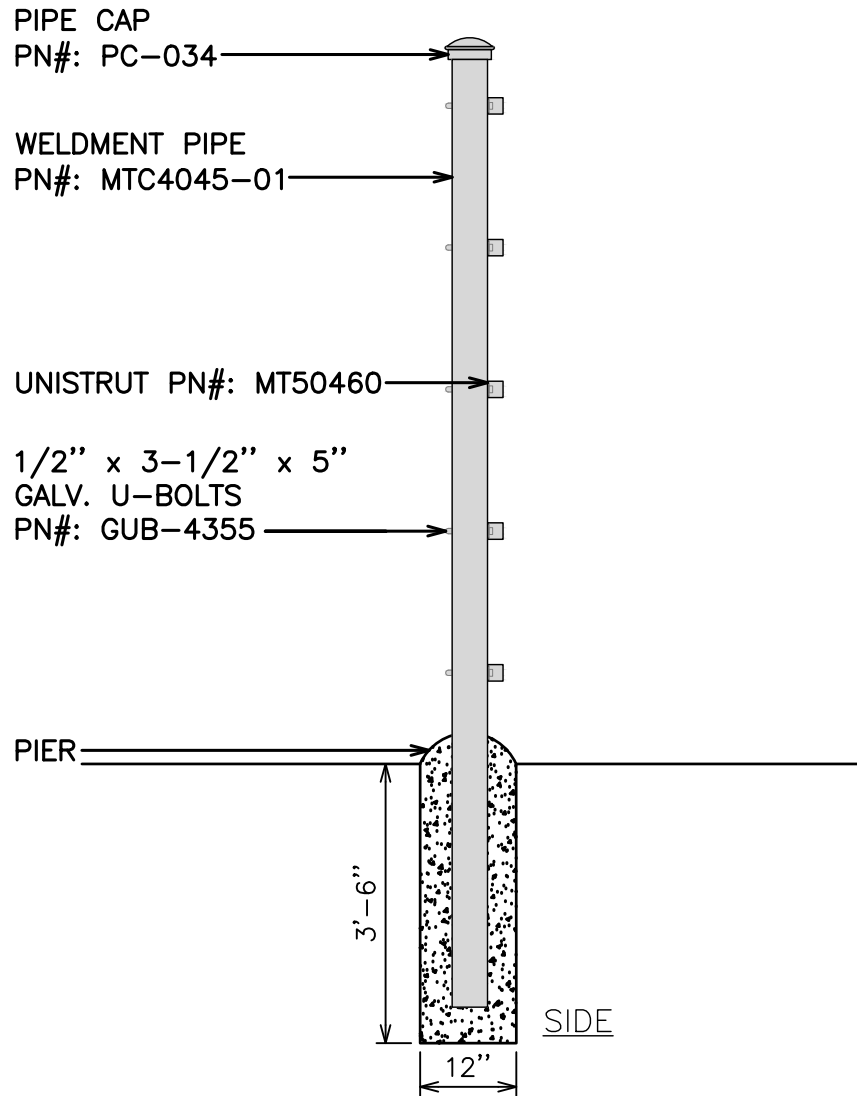

UNISTRUT CONNECTION DETAIL

SCALE: N.T.S

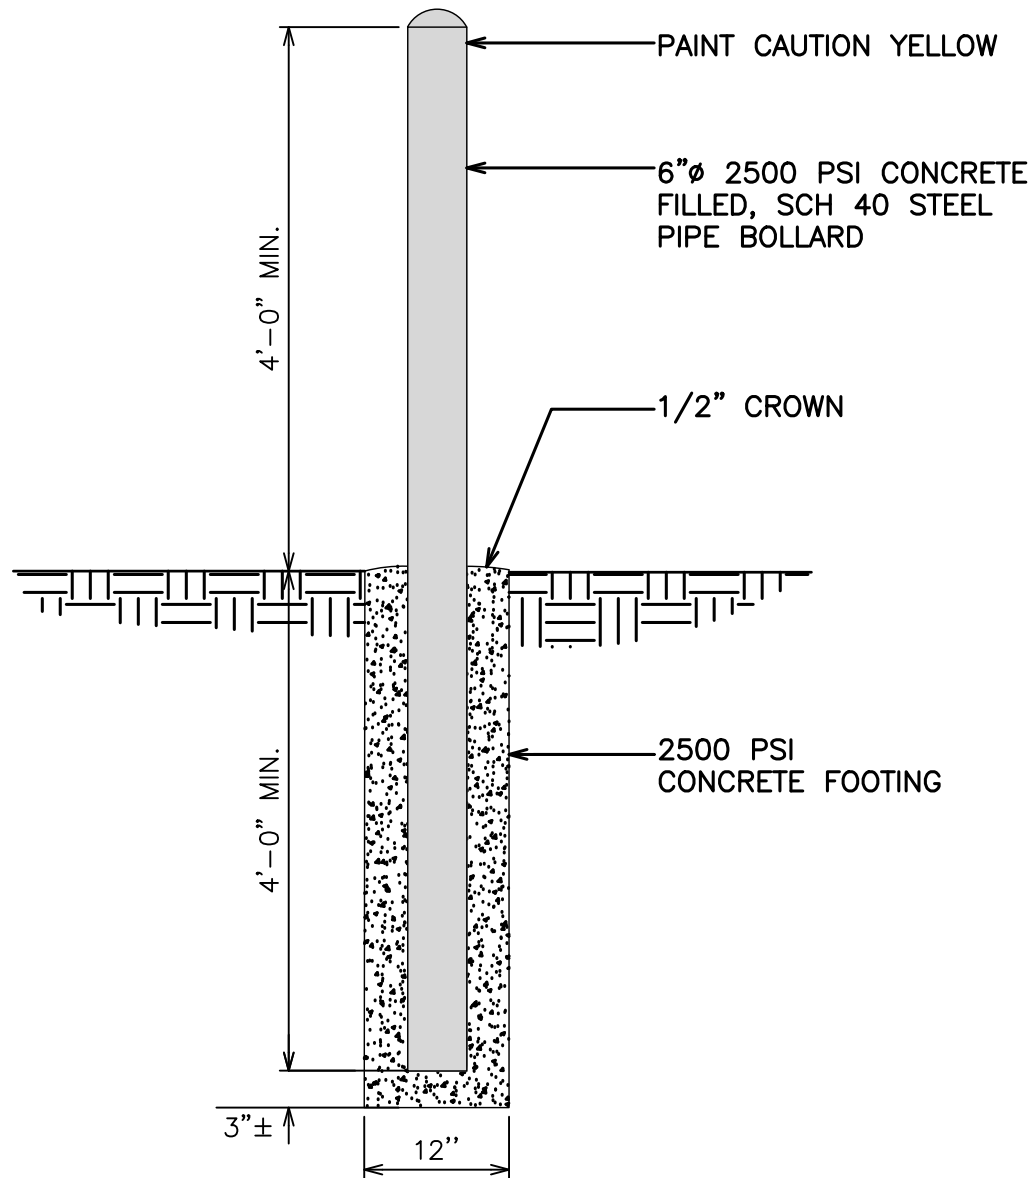


STANDARD BOLLARD DETAIL

SCALE: N.T.S

NOTES:

1. FENCE RATED TO 130 MPH WIND SPEED. REDUCE SPACING BY 0.3 M PER 10 MPH TO INCREASE RATING CMU FENCE REQUIRED ABOVE 150 MPH RATING.
2. POST DESIGN BASED ON 1,500 PSF SOIL BEARING CAPACITY. OPEN HOLE REQUIRED.
3. ALL BACKFILL SHALL BE THOROUGHLY COMPACTED TO A MINIMUM OF 95% DENSITY USING THE MODIFIED PROCTOR METHOD.
4. ALL CONCRETE WORK SHALL BE PERFORMED IN ACCORDANCE WITH ACI-318-14.

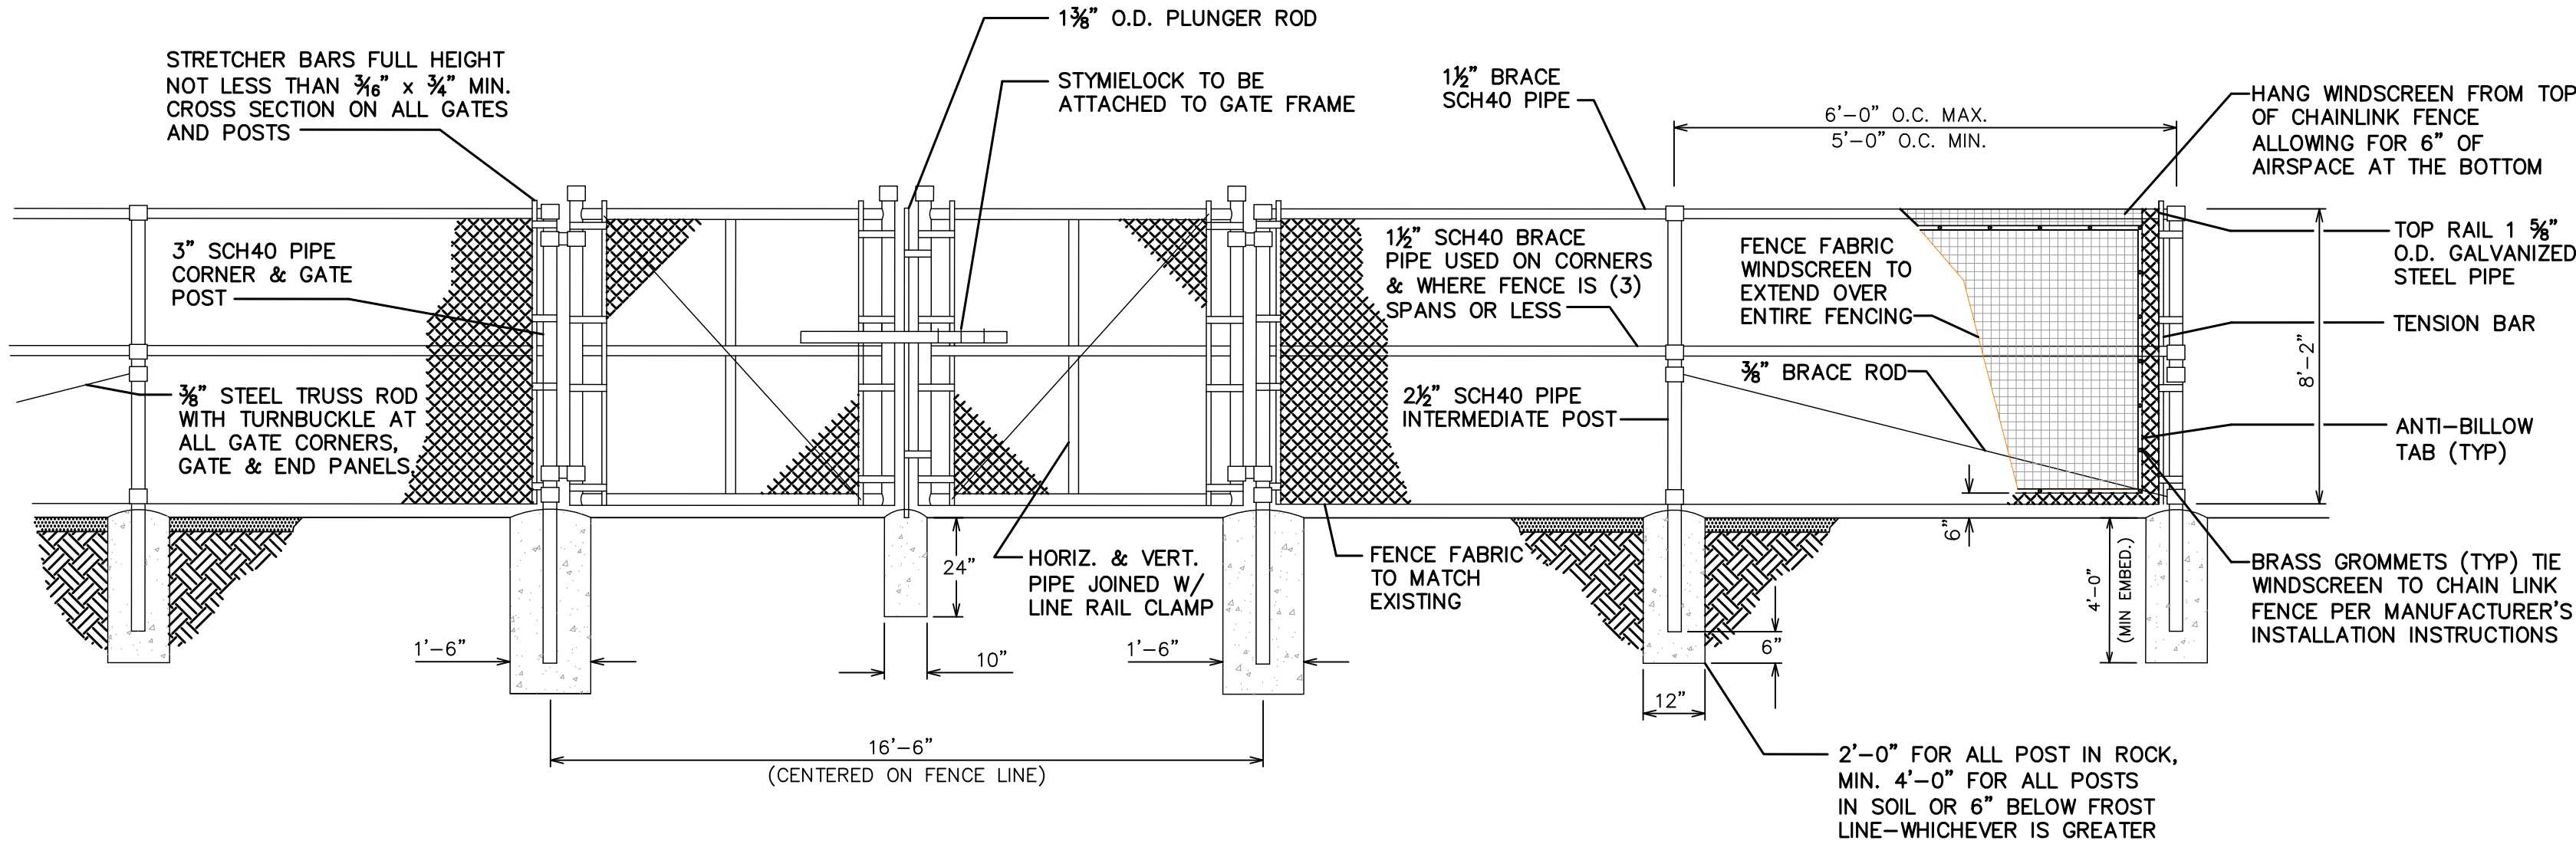

FENCE AND ACCESS GATE

SCALE: N.T.S.

NOTES:


1. SIGNS SHALL BE MADE OF ALUMINUM WITH 1/4" HOLES 1/2" FROM EACH CORNER TO HANG SIGNS ON FENCE.
2. SIGNS SHALL BE INSTALLED ON GATE
3. SIGNS SHALL BE INSTALLED WITH CENTER AT 5' ABOVE FINISHED GRADE.



SIZE = 12"x18" ALUMINUM SIGN

THICKNESS = 0.05" (1/16") OR CLOSEST STANDARD THICKNESS

QUANTITY = 1

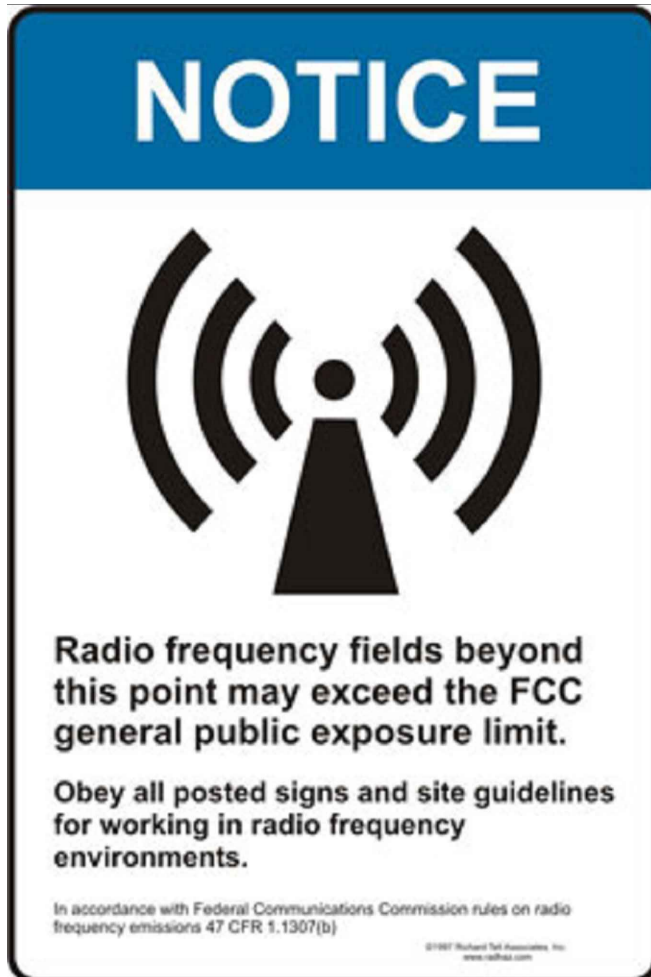

SIZE = 12"x18" ALUMINUM SIGN

THICKNESS = 0.05" (1/16") OR CLOSEST STANDARD THICKNESS

QUANTITY = 1



SIZE = 12"x16" ALUMINUM SIGN

THICKNESS = 0.05" (1/16") OR CLOSEST STANDARD THICKNESS

QUANTITY = 1

PLANS PREPARED BY:

CONSTRUCTION	08-05-26	4
CONSTRUCTION	06-09-26	3
CONSTRUCTION	06-03-26	2
CONSTRUCTION	05-15-26	1
CONSTRUCTION	04-01-26	0
PRELIMINARY	03-30-26	B
ISSUED FOR:	DATE	REV
CHECKED BY: JFJ	DRAWN BY: OJK	

PROJECT INFORMATION:

SITE NAME:
COLORADO SPRINGS,
CO - 100KM

7233 SPACE VILLAGE AVE.
COLORADO SPRINGS, CO 80914
(EL PASO COUNTY)

SEAL:



08-05-26

SHEET TITLE:

STRUCTURAL
DETAILS I

SHEET NUMBER:

C-5.1

REVISION:


4

NOT USED

SCALE: N.T.S

STANDARD BOLLARD DETAIL

SCALE: N.T.S

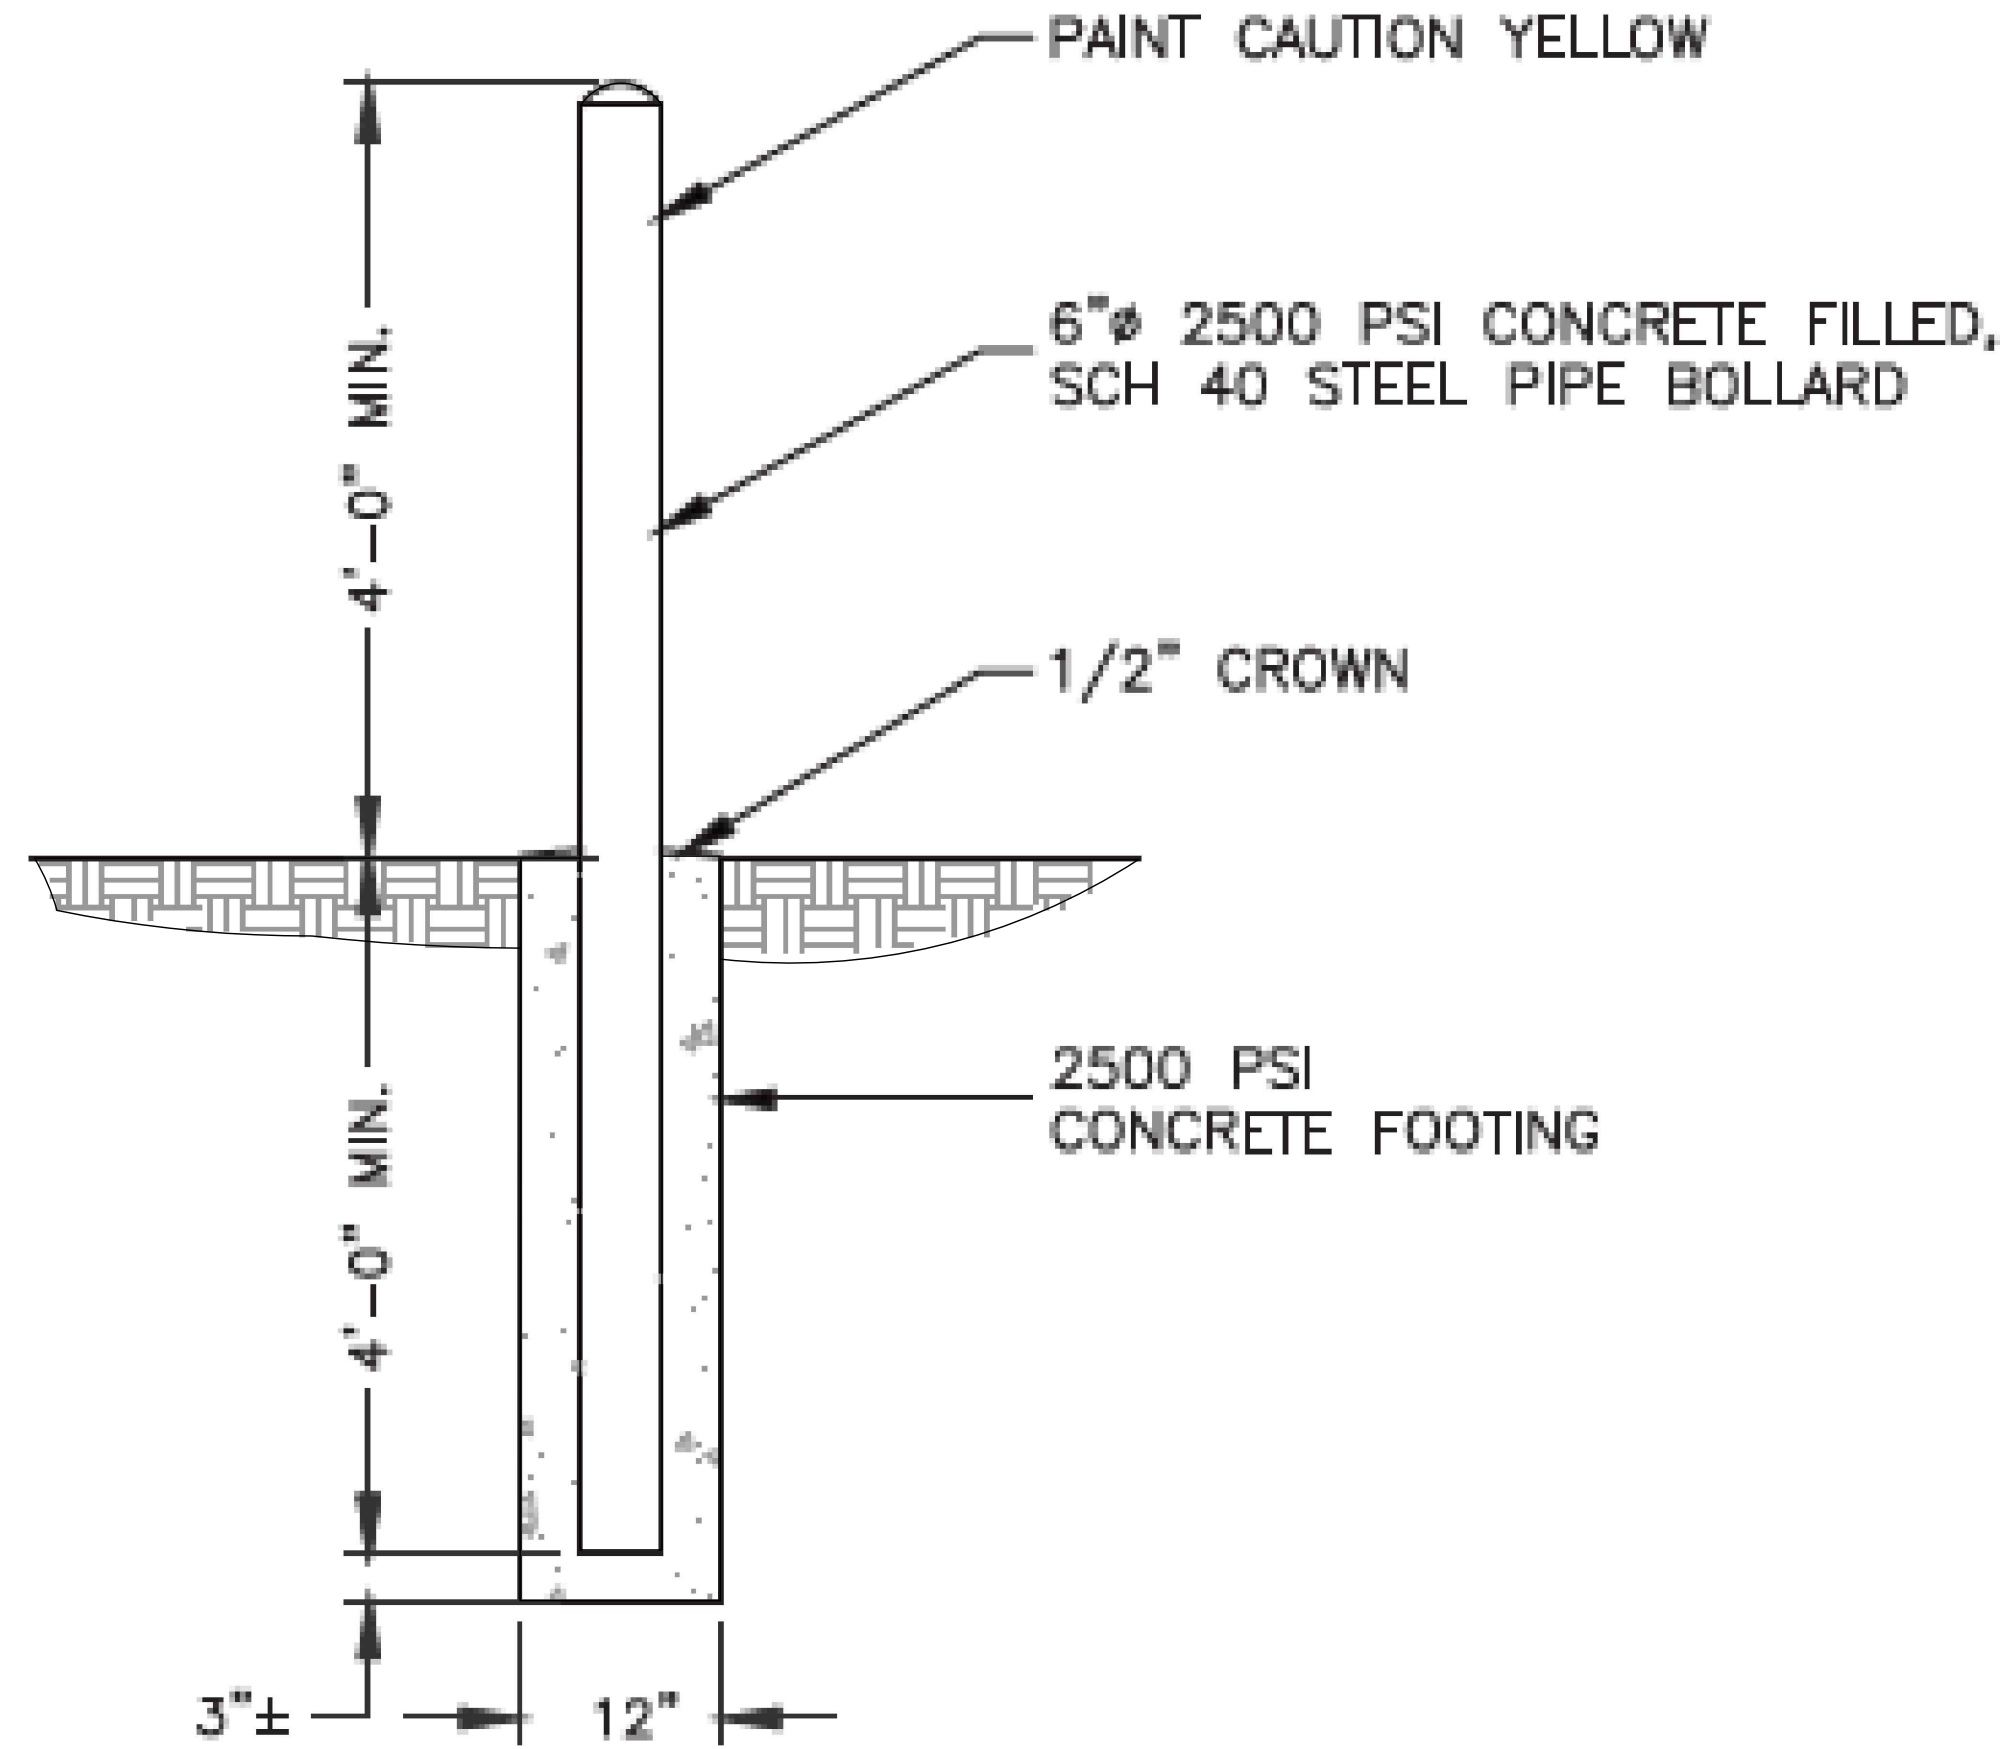

SHEET TITLE:

STRUCTURAL
DETAILS III

SHEET NUMBER:

C-5.3

REVISION:

4

SEAL:



08-05-26

PROJECT INFORMATION:

SITE NAME:
COLORADO SPRINGS,
CO - 100KM
7233 SPACE VILLAGE AVE.
COLORADO SPRINGS, CO 80914
(EL PASO COUNTY)

4

08-05-26

CONSTRUCTION

3

06-08-26

CONSTRUCTION

2

06-03-26

CONSTRUCTION

1

05-15-26

CONSTRUCTION

0

04-01-26

CONSTRUCTION

B

03-30-26

PRELIMINARY

ISSUED FOR:

CHECKED BY: JFJ

PLANS PREPARED BY:




326 TRYON ROAD
RALEIGH, NC 27603-3530
OFFICE (919) 861-6351
FAX (919) 861-6350

TEP IS A FAMILY OF COMPANIES LICENSED TO PROVIDE DIFFERENT SERVICES IN DIFFERENT JURISDICTIONS, DEPENDING ON THE JURISDICTION. PROFESSIONAL ENGINEERING AND LAND SURVEYING SERVICES ARE PROVIDED BY TEP OPCO LLC, A DELAWARE LIMITED LIABILITY COMPANY. TEP ENGINEERING, LLC, A NORTH CAROLINA PROFESSIONAL LIMITED LIABILITY COMPANY, OR M&H ENGINEERING, LLC, A NEW YORK PROFESSIONAL LIMITED LIABILITY COMPANY. GENERAL CONTRACTOR SERVICES ARE PROVIDED BY TEP OPCO LLC, A DELAWARE LIMITED LIABILITY COMPANY. WE ACQUIRE THE REQUISITE LICENSES IN EACH STATE. ADDITIONAL INFORMATION CAN BE OBTAINED FROM THE COMPANY.

NOTES:

- ELECTRICAL DESIGN HAS A MAXIMUM VOLTAGE DROP OF 5% PER C405.10 OF THE 2021 IECC.
- A FINAL COMMISSIONING REPORT SHALL BE DELIVERED TO THE COMPOUND OWNER PER SECTION C408.2.5 OF THE 2021 IECC.
- ALL UTILITY SOURCE INFORMATION, INCLUDING FINAL TRANSFORMER LOCATION, SERVICE ROUTING, AND AVAILABLE FAULT CURRENT, IS PENDING FINAL UTILITY COORDINATION WITH COLORADO SPRINGS UTILITIES.
- FINAL METER SOCKET TYPE & METERING CONDUCTORS TO BE VERIFIED WITH COLORADO SPRINGS UTILITIES FIELD ENGINEER PRIOR TO INSTALLATION.
- LISTED AVAILABLE FAULT CURRENT AT THE SECONDARY TERMINALS OF THE PROPOSED 500KVA, THREE-PHASE, PAD-MOUNTED, UTILITY TRANSFORMER PROVIDED BY COLORADO SPRINGS UTILITIES. CONTRACTOR TO VERIFY THE INCOMING UTILITY FAULT CURRENT WITH COLORADO SPRINGS UTILITIES PRIOR TO CONSTRUCTION AND TO CONTACT EOR IF THE FAULT CALUE IS LARGER THAN THE VALUE NOTED IN THESE DRAWINGS.
- CONTRACTOR TO ENSURE THAT ALL CONDUCTORS ARE A MINIMUM OF LISTED LENGTH NOTED IN THE FAULT CALCULATIONS TABLE FOR THESE CALCULATIONS TO BE VALID. TEP ASSUMES NO RESPONSIBILITY OR LIABILITY FOR DAMAGES, LOSS OF REVENUE, OR INJURY THAT OCCUR DUE TO FAILURE TO MEET THESE SPECIFICATIONS.

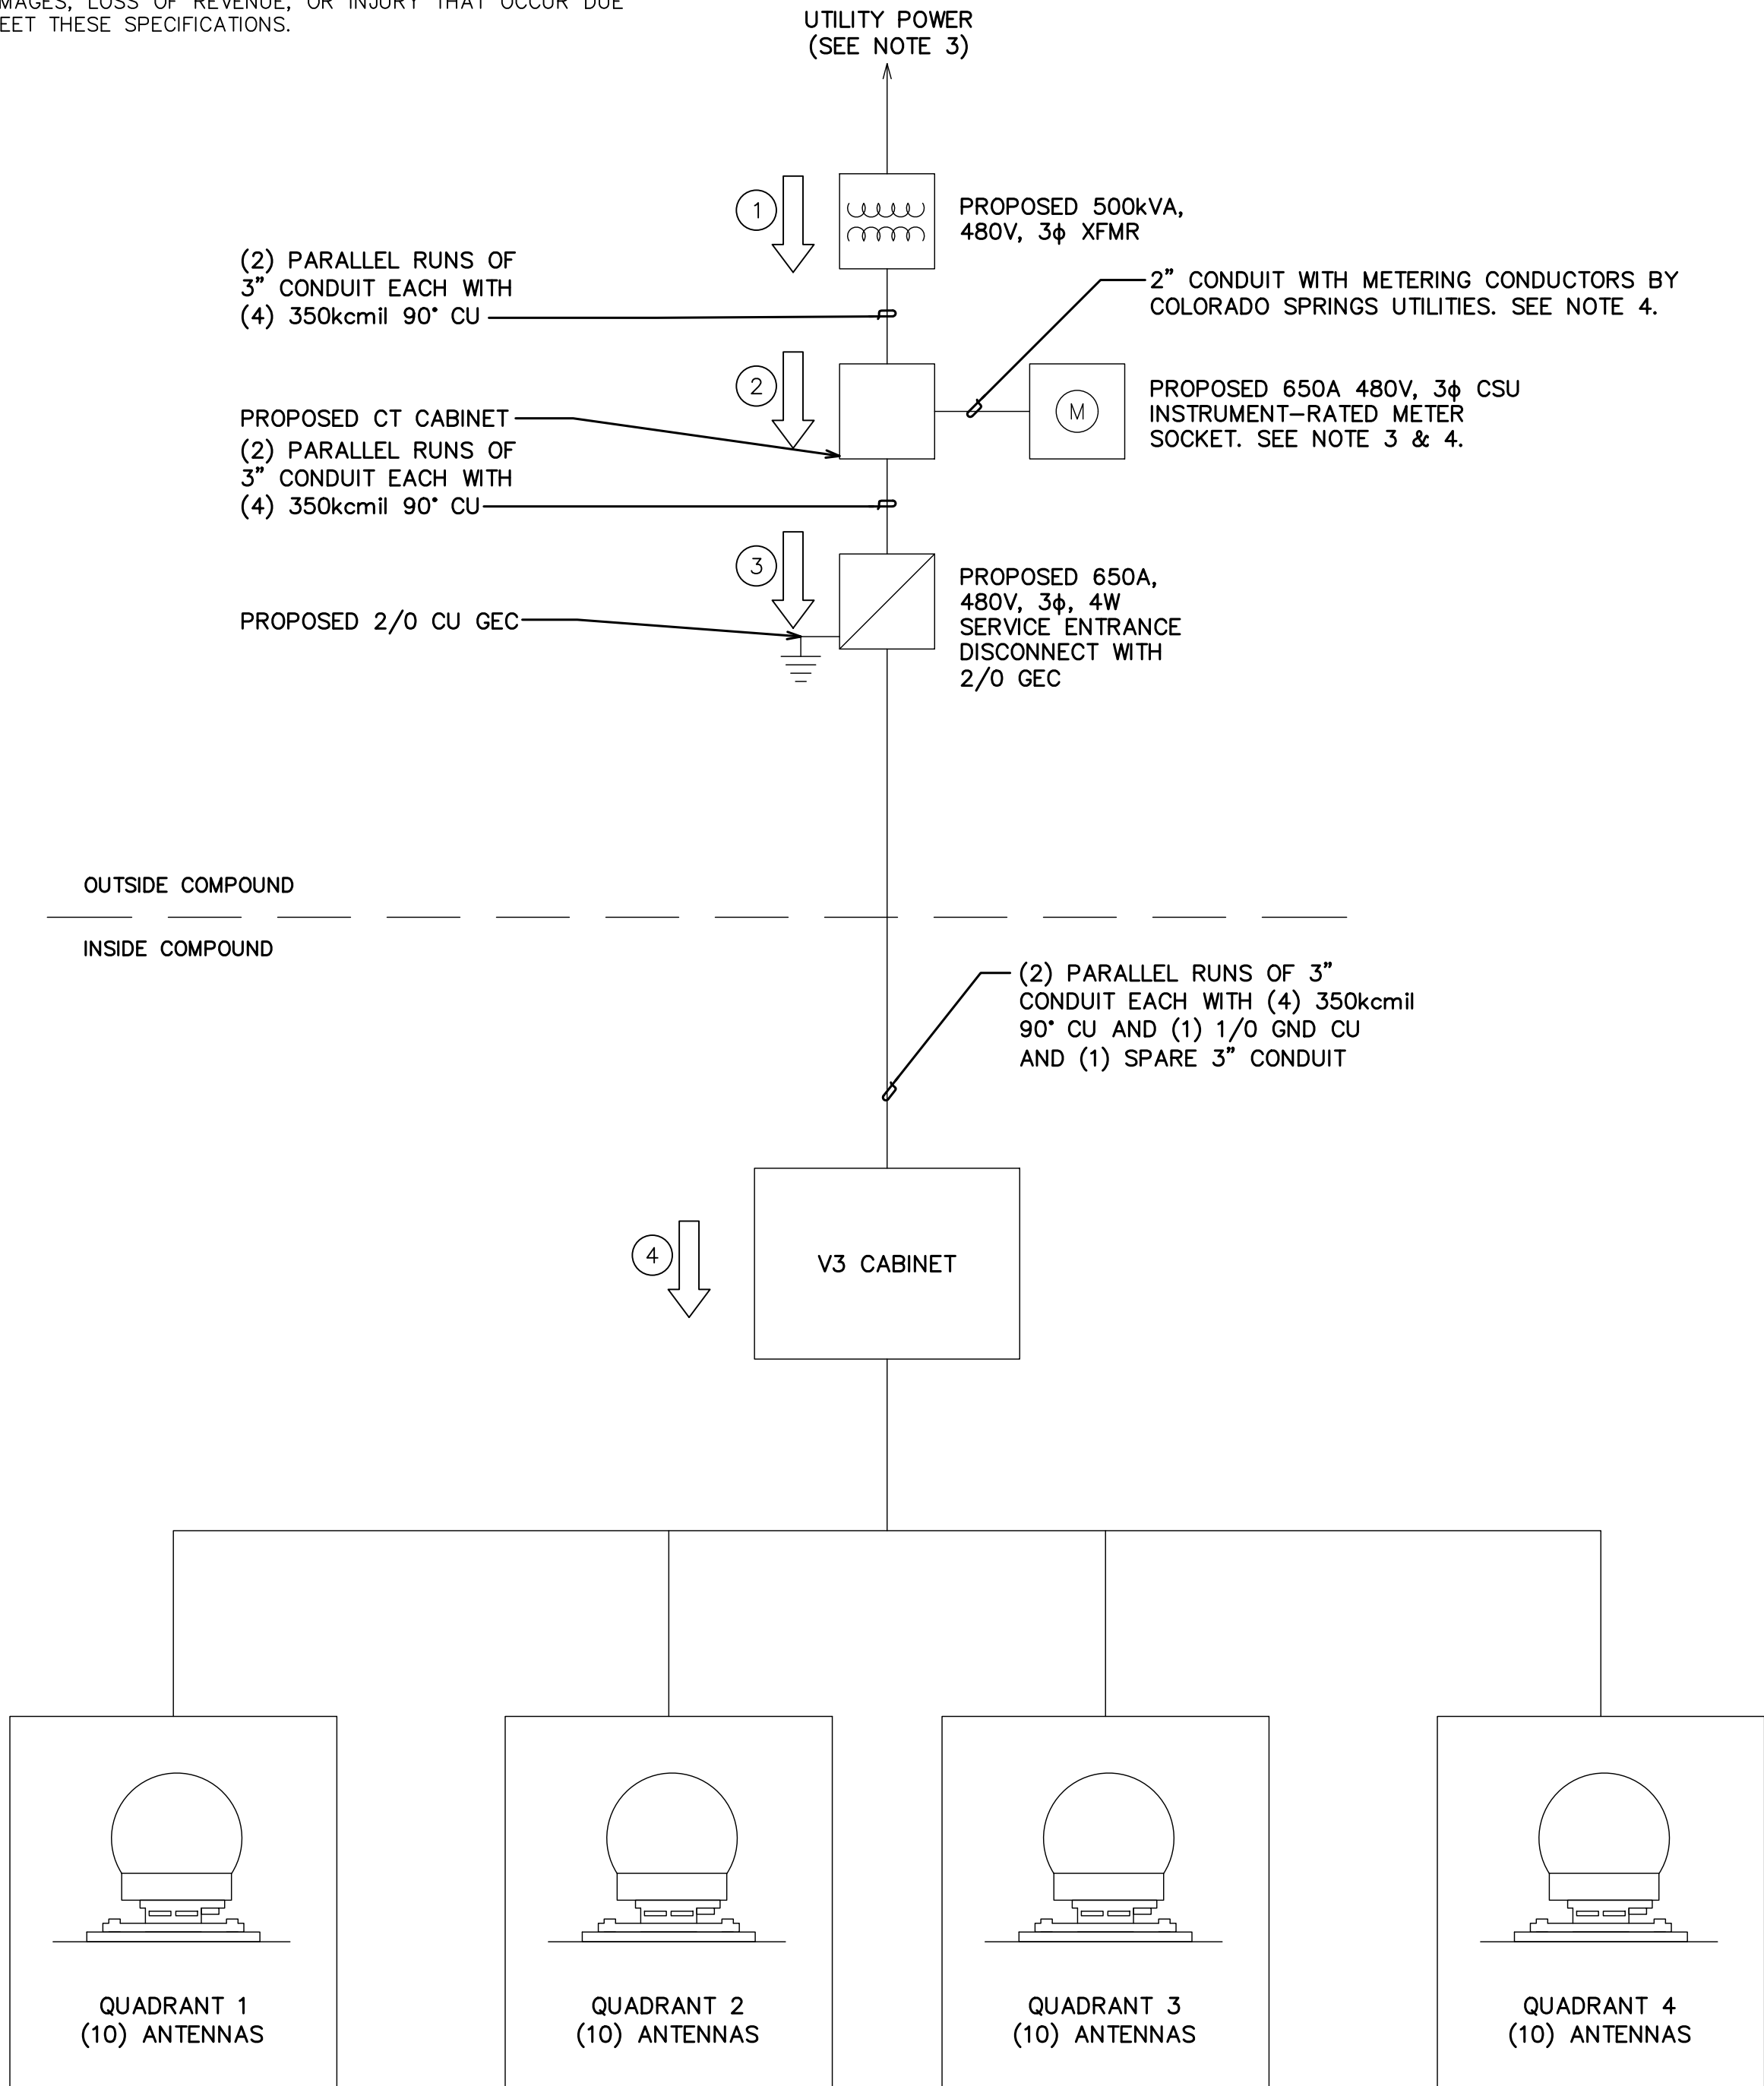

FAULT CURRENT AT EQUIPMENT			
#	EQUIPMENT	FAULT CURRENT	AIC RATING
①	UTILITY TRANSFORMER	43,000A	N/A
②	650A UTILITY METER	40,643A	MIN. 42k AIC
③	650A DISCONNECT	40,512A	MIN. 42k AIC
④	PROPOSED V3 CABINET	28,379A	MIN. 42k AIC

ONE-LINE DIAGRAM

SCALE: N.T.S.

NOTES:

- THE PANELBOARD SHALL HAVE A MINIMUM AMPERE INTERRUPTING CAPACITY (AIC) RATING OF 42,000 AMPS.
- LOAD INFORMATION FOR THIS PANEL IS BASED ON TYPICAL LOAD ITEMS ASSOCIATED WITH THIS CLASS/SIZE OF METERED MAIN BREAKER PANEL AS SUBMITTED TO THE UTILITY.

480V, 3Ø WYE, V3 POWER RACK AC DISTRIBUTION PANEL SCHEDULE												
LOAD SERVED	VOLT AMPERES (WATTS)			TRIP	CKT #	CKT #	TRIP	VOLT AMPERES (WATTS)			LOAD SERVED	
	L1	L2	L3					L1	L2	L3		
UPS #1	4711	4711	4711	30A	1,3,5	2,4,6	30A	3533	3533	3533	HVAC #1	
UPS #2	4711	4711	4711	30A	7,9,11	8,10,12	30A	3533	3533	3533	HVAC #2	
ANTENNA 1	3020	3020	3020	30A	13,15,17	14,16,18	30A	3020	3020	3020	ANTENNA 2	
ANTENNA 3	3020	3020	3020	30A	19,21,23	20,22,24	30A	3020	3020	3020	ANTENNA 4	
ANTENNA 5	3020	3020	3020	30A	25,27,29	26,28,30	30A	3020	3020	3020	ANTENNA 6	
ANTENNA 7	3020	3020	3020	30A	31,33,35	32,34,36	30A	3020	3020	3020	ANTENNA 8	
ANTENNA 9	3020	3020	3020	30A	37,39,41	38,40,42	30A	3020	3020	3020	ANTENNA 10	
ANTENNA 11	3020	3020	3020	30A	43,45,47	44,46,48	30A	3020	3020	3020	ANTENNA 12	
ANTENNA 13	3020	3020	3020	30A	49,51,53	50,52,54	30A	3020	3020	3020	ANTENNA 14	
ANTENNA 15	3020	3020	3020	30A	55,57,59	56,58,60	30A	3020	3020	3020	ANTENNA 16	
ANTENNA 17	3020	3020	3020	30A	61,63,65	62,64,66	30A	3020	3020	3020	ANTENNA 18	
ANTENNA 19	3020	3020	3020	30A	67,69,71	68,70,72	30A	3020	3020	3020	ANTENNA 20	
ANTENNA 21	3020	3020	3020	30A	73,75,77	74,76,78	30A	3020	3020	3020	ANTENNA 22	
ANTENNA 23	3020	3020	3020	30A	79,81,83	80,82,84	30A	3020	3020	3020	ANTENNA 24	
ANTENNA 25	3020	3020	3020	30A	85,87,89	86,88,90	30A	3020	3020	3020	ANTENNA 26	
ANTENNA 27	3020	3020	3020	30A	91,93,95	92,94,96	30A	3020	3020	3020	ANTENNA 28	
ANTENNA 29	3020	3020	3020	30A	97,99,101	98,100,102	30A	3020	3020	3020	ANTENNA 30	
ANTENNA 31	3020	3020	3020	30A	103,105,107	104,106,108	30A	3020	3020	3020	ANTENNA 32	
ANTENNA 33	3020	3020	3020	30A	109,111,113	110,112,114	30A	3020	3020	3020	ANTENNA 34	
ANTENNA 35	3020	3020	3020	30A	115,117,119	116,118,120	30A	3020	3020	3020	ANTENNA 36	
ANTENNA 37	3020	3020	3020	30A	121,123,125	122,124,126	30A	3020	3020	3020	ANTENNA 38	
ANTENNA 39	3020	3020	3020	30A	127,129,131	128,130,132	30A	3020	3020	3020	ANTENNA 40	
VOLT AMPS	69822	69822	69822					67466	67466	67466	VOLT AMPS	
L1 VOLT AMPERES				L1	L2	L3	L2, L3 VOLT AMPERES MAX VOLT AMPERES MAX AMPS MAX 3PH KVA					
				137288	137288	137288						
				137288								
				495.6								
				411.9								

- *INSTALL PER MARKET STANDARDS
- **ANTENNAS SHOWN AT MAXIMUM LOADING. POWER USAGE PROVIDED BY THE CUSTOMER
- ***ALL BREAKERS SHOWN IN THIS PANEL SCHEDULE ARE THREE POLE BREAKERS AND HAVE BEEN CONDENSED TO SINGLE LINES FOR SIMPLIFICATION
- ****PANEL AND BREAKERS SHOWN ARE COMPONENTS THAT ARE INSTALLED IN THE V3 CABINET BY THE MANUFACTURER


PANEL SCHEDULE

SCALE: N.T.S.

PLANS PREPARED BY:

CONSTRUCTION	08-05-26	4
CONSTRUCTION	06-08-26	3
CONSTRUCTION	06-03-26	2
CONSTRUCTION	05-15-26	1
CONSTRUCTION	04-01-26	0
PRELIMINARY	03-30-26	B
ISSUED FOR:	DATE	REV
CHECKED BY:	DATE	REV

PROJECT INFORMATION:
SITE NAME:
COLORADO SPRINGS,
CO - 100KM
7233 SPAGE VILLAGE AVE.
COLORADO SPRINGS, CO 80914
(EL PASO COUNTY)



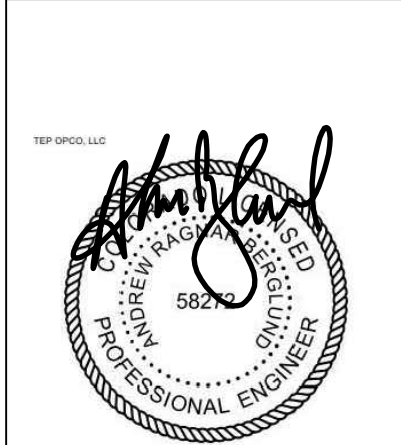


SEAL:

08-05-26

SHEET TITLE: ELECTRICAL DETAILS	SHEET NUMBER: E-1.1	REVISION: 4	TEP # 353465 490368

TEP IS A FAMILY OF COMPANIES LICENSED TO PROVIDE DIFFERENT SERVICES IN DIFFERENT JURISDICTIONS. DEPENDING ON THE JURISDICTION, PROFESSIONAL ENGINEERING AND LAND SURVEYING SERVICES ARE PROVIDED BY TEP OPCO LLC. A DELAWARE LIMITED LIABILITY COMPANY. TEP ENGINEERING, LLC, A NORTH CAROLINA PROFESSIONAL LIMITED LIABILITY COMPANY, OR M&H ENGINEERING, LLC, A NEW YORK PROFESSIONAL LIMITED LIABILITY COMPANY. GENERAL CONTRACTOR SERVICES ARE PROVIDED BY TEP OPCO LLC, A DELAWARE LIMITED LIABILITY COMPANY. WE ACQUIRE THE REQUISITE LICENSES IN EACH STATE. ADDITIONAL INFORMATION CAN BE OBTAINED FROM THE COMPANY.

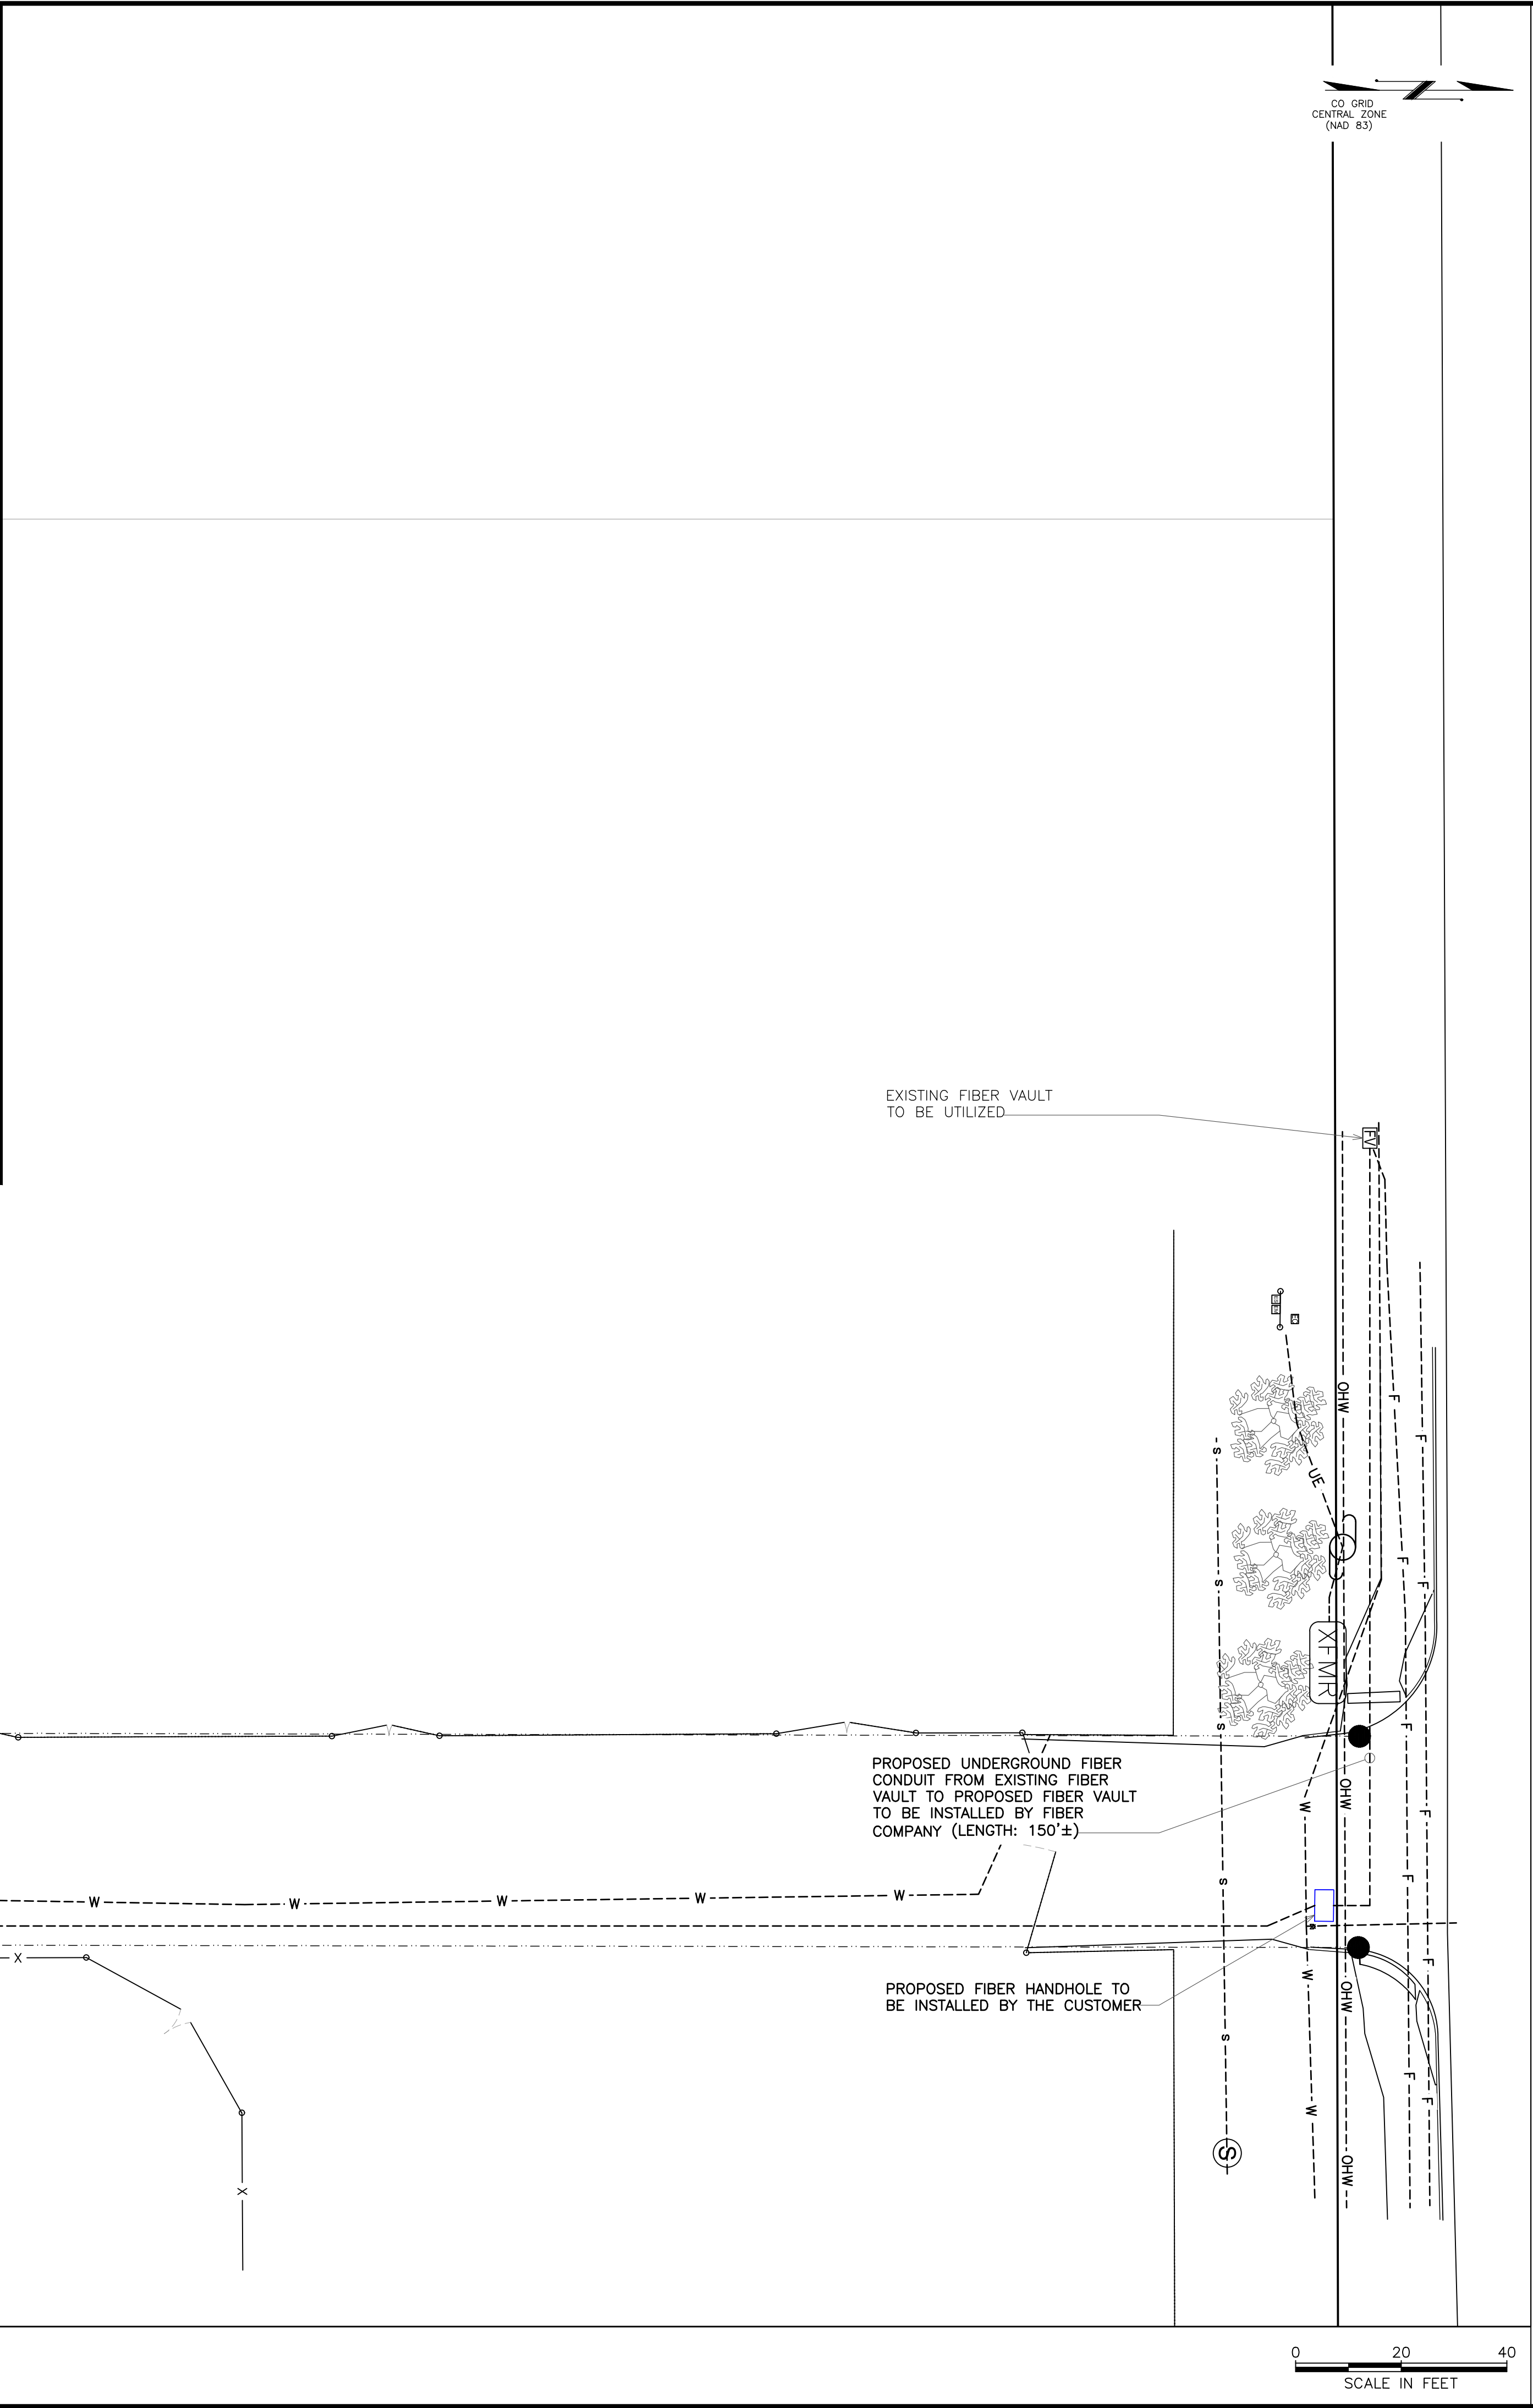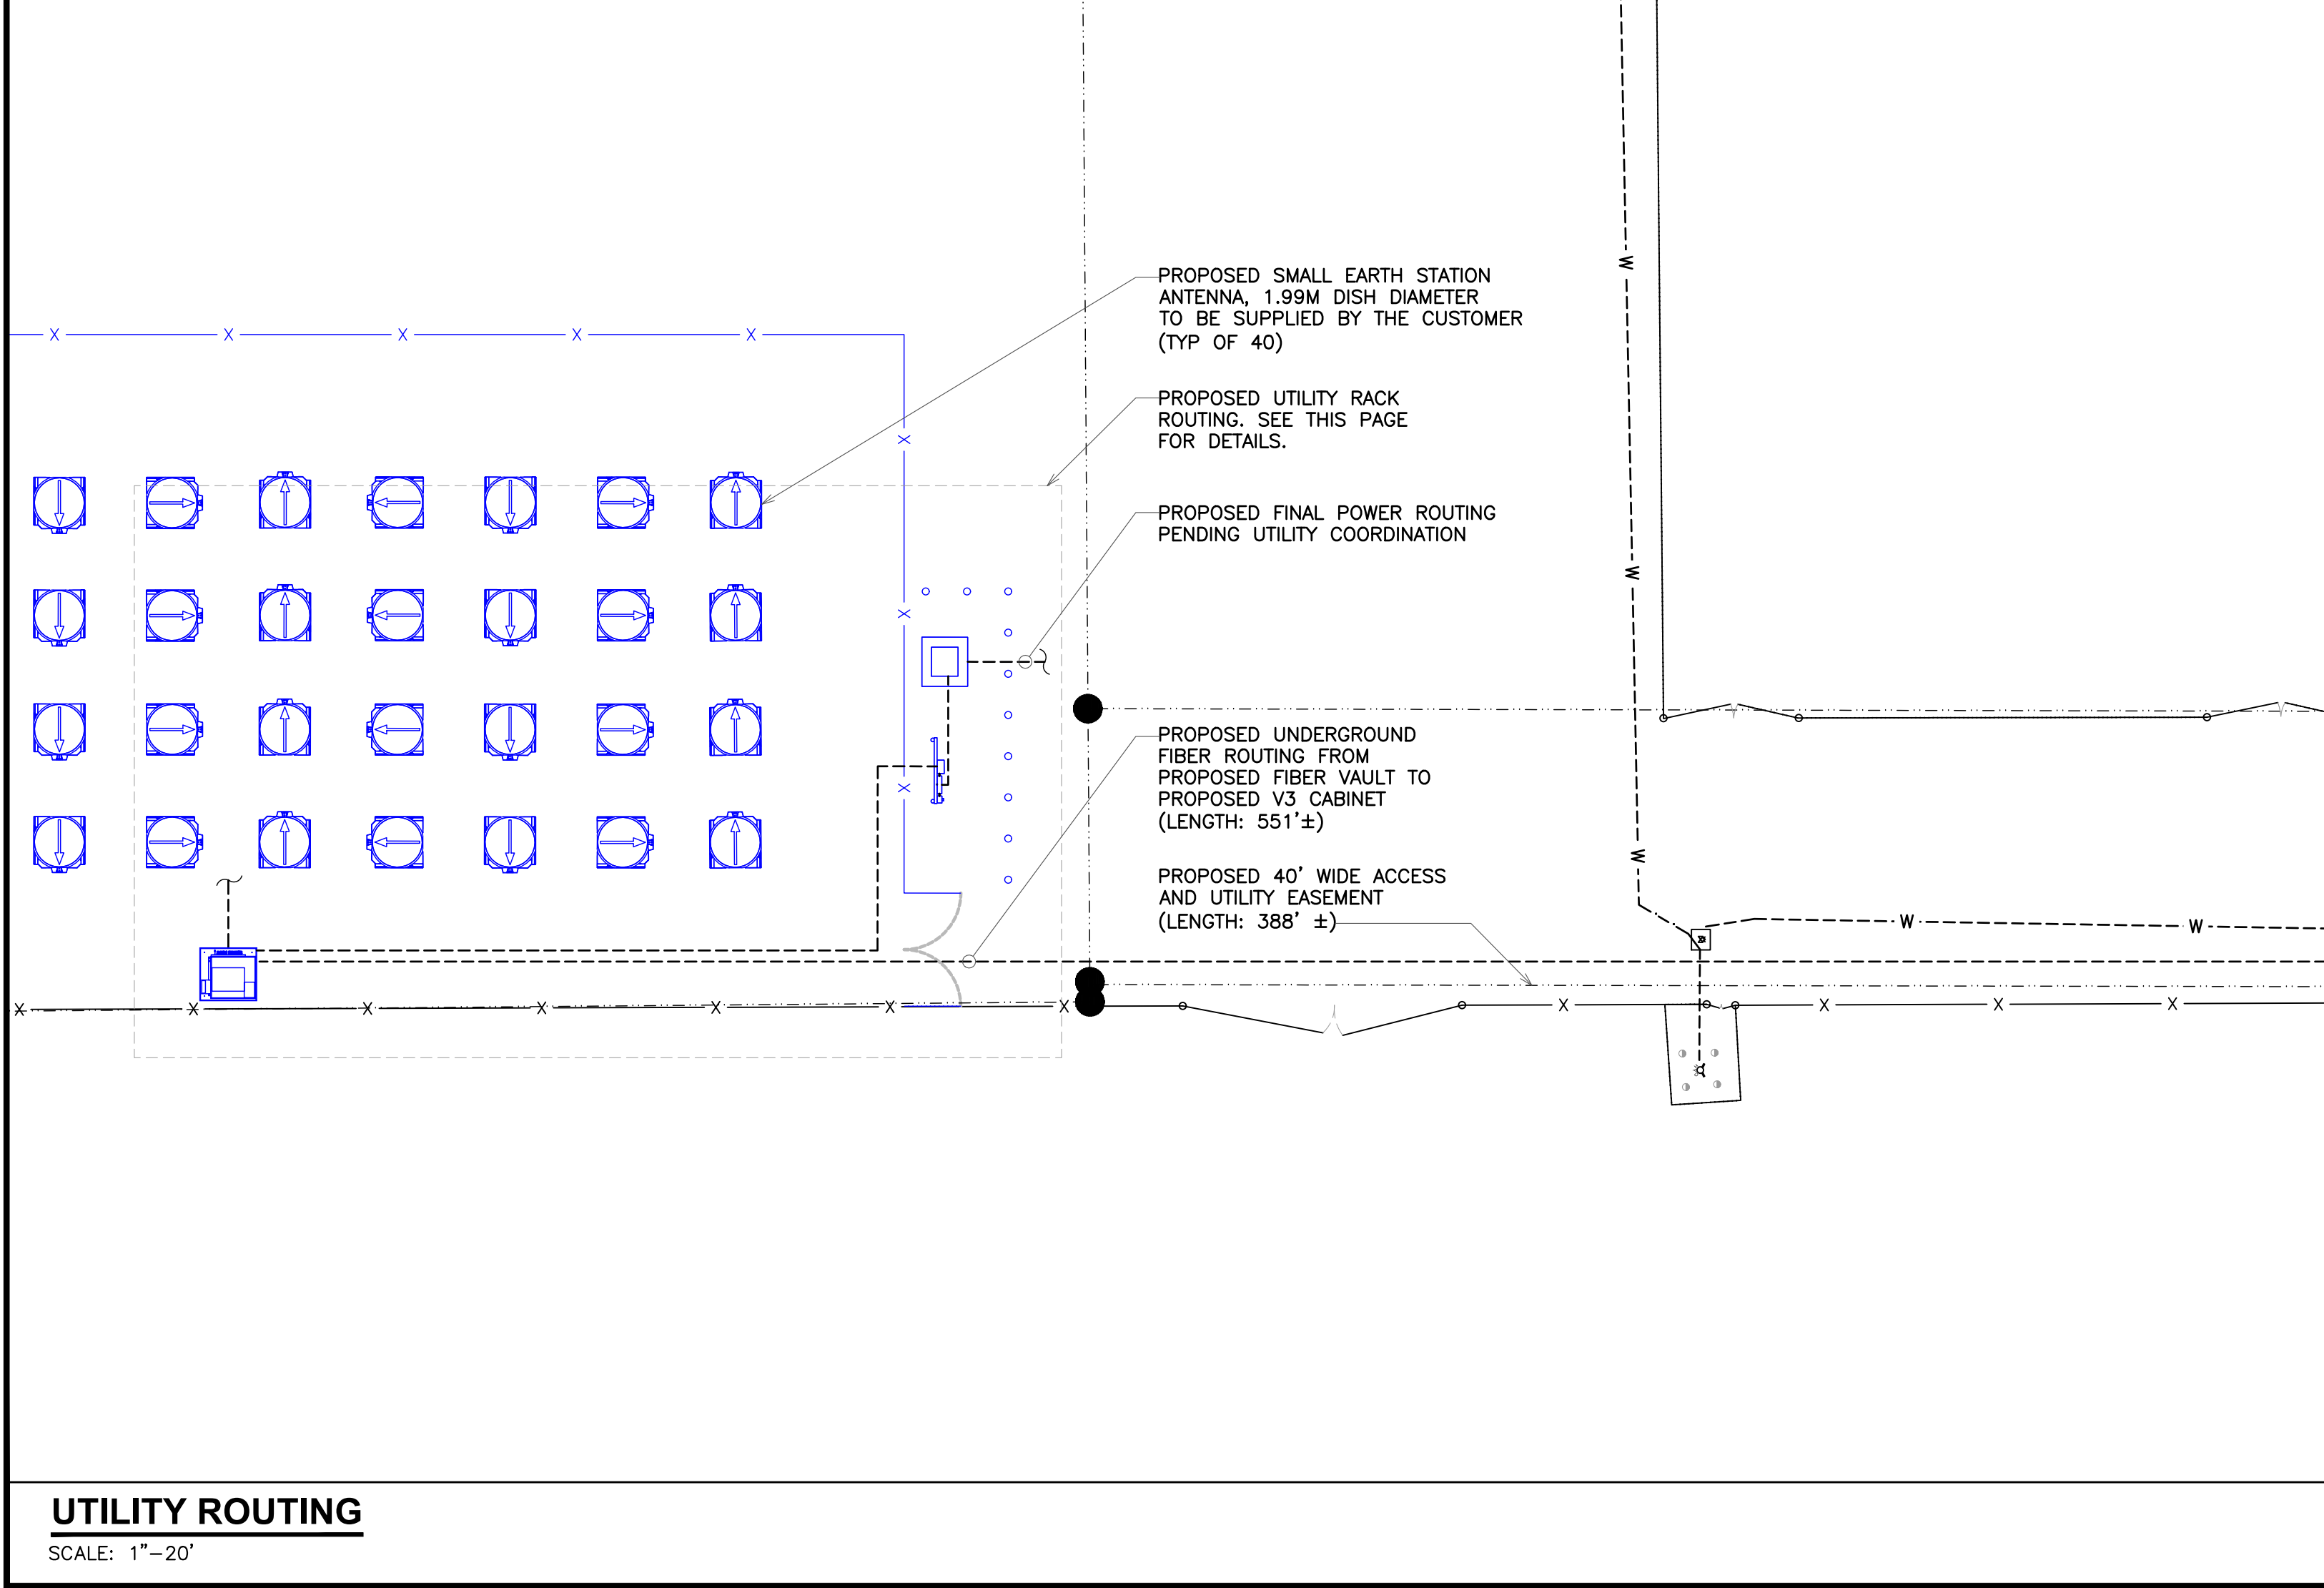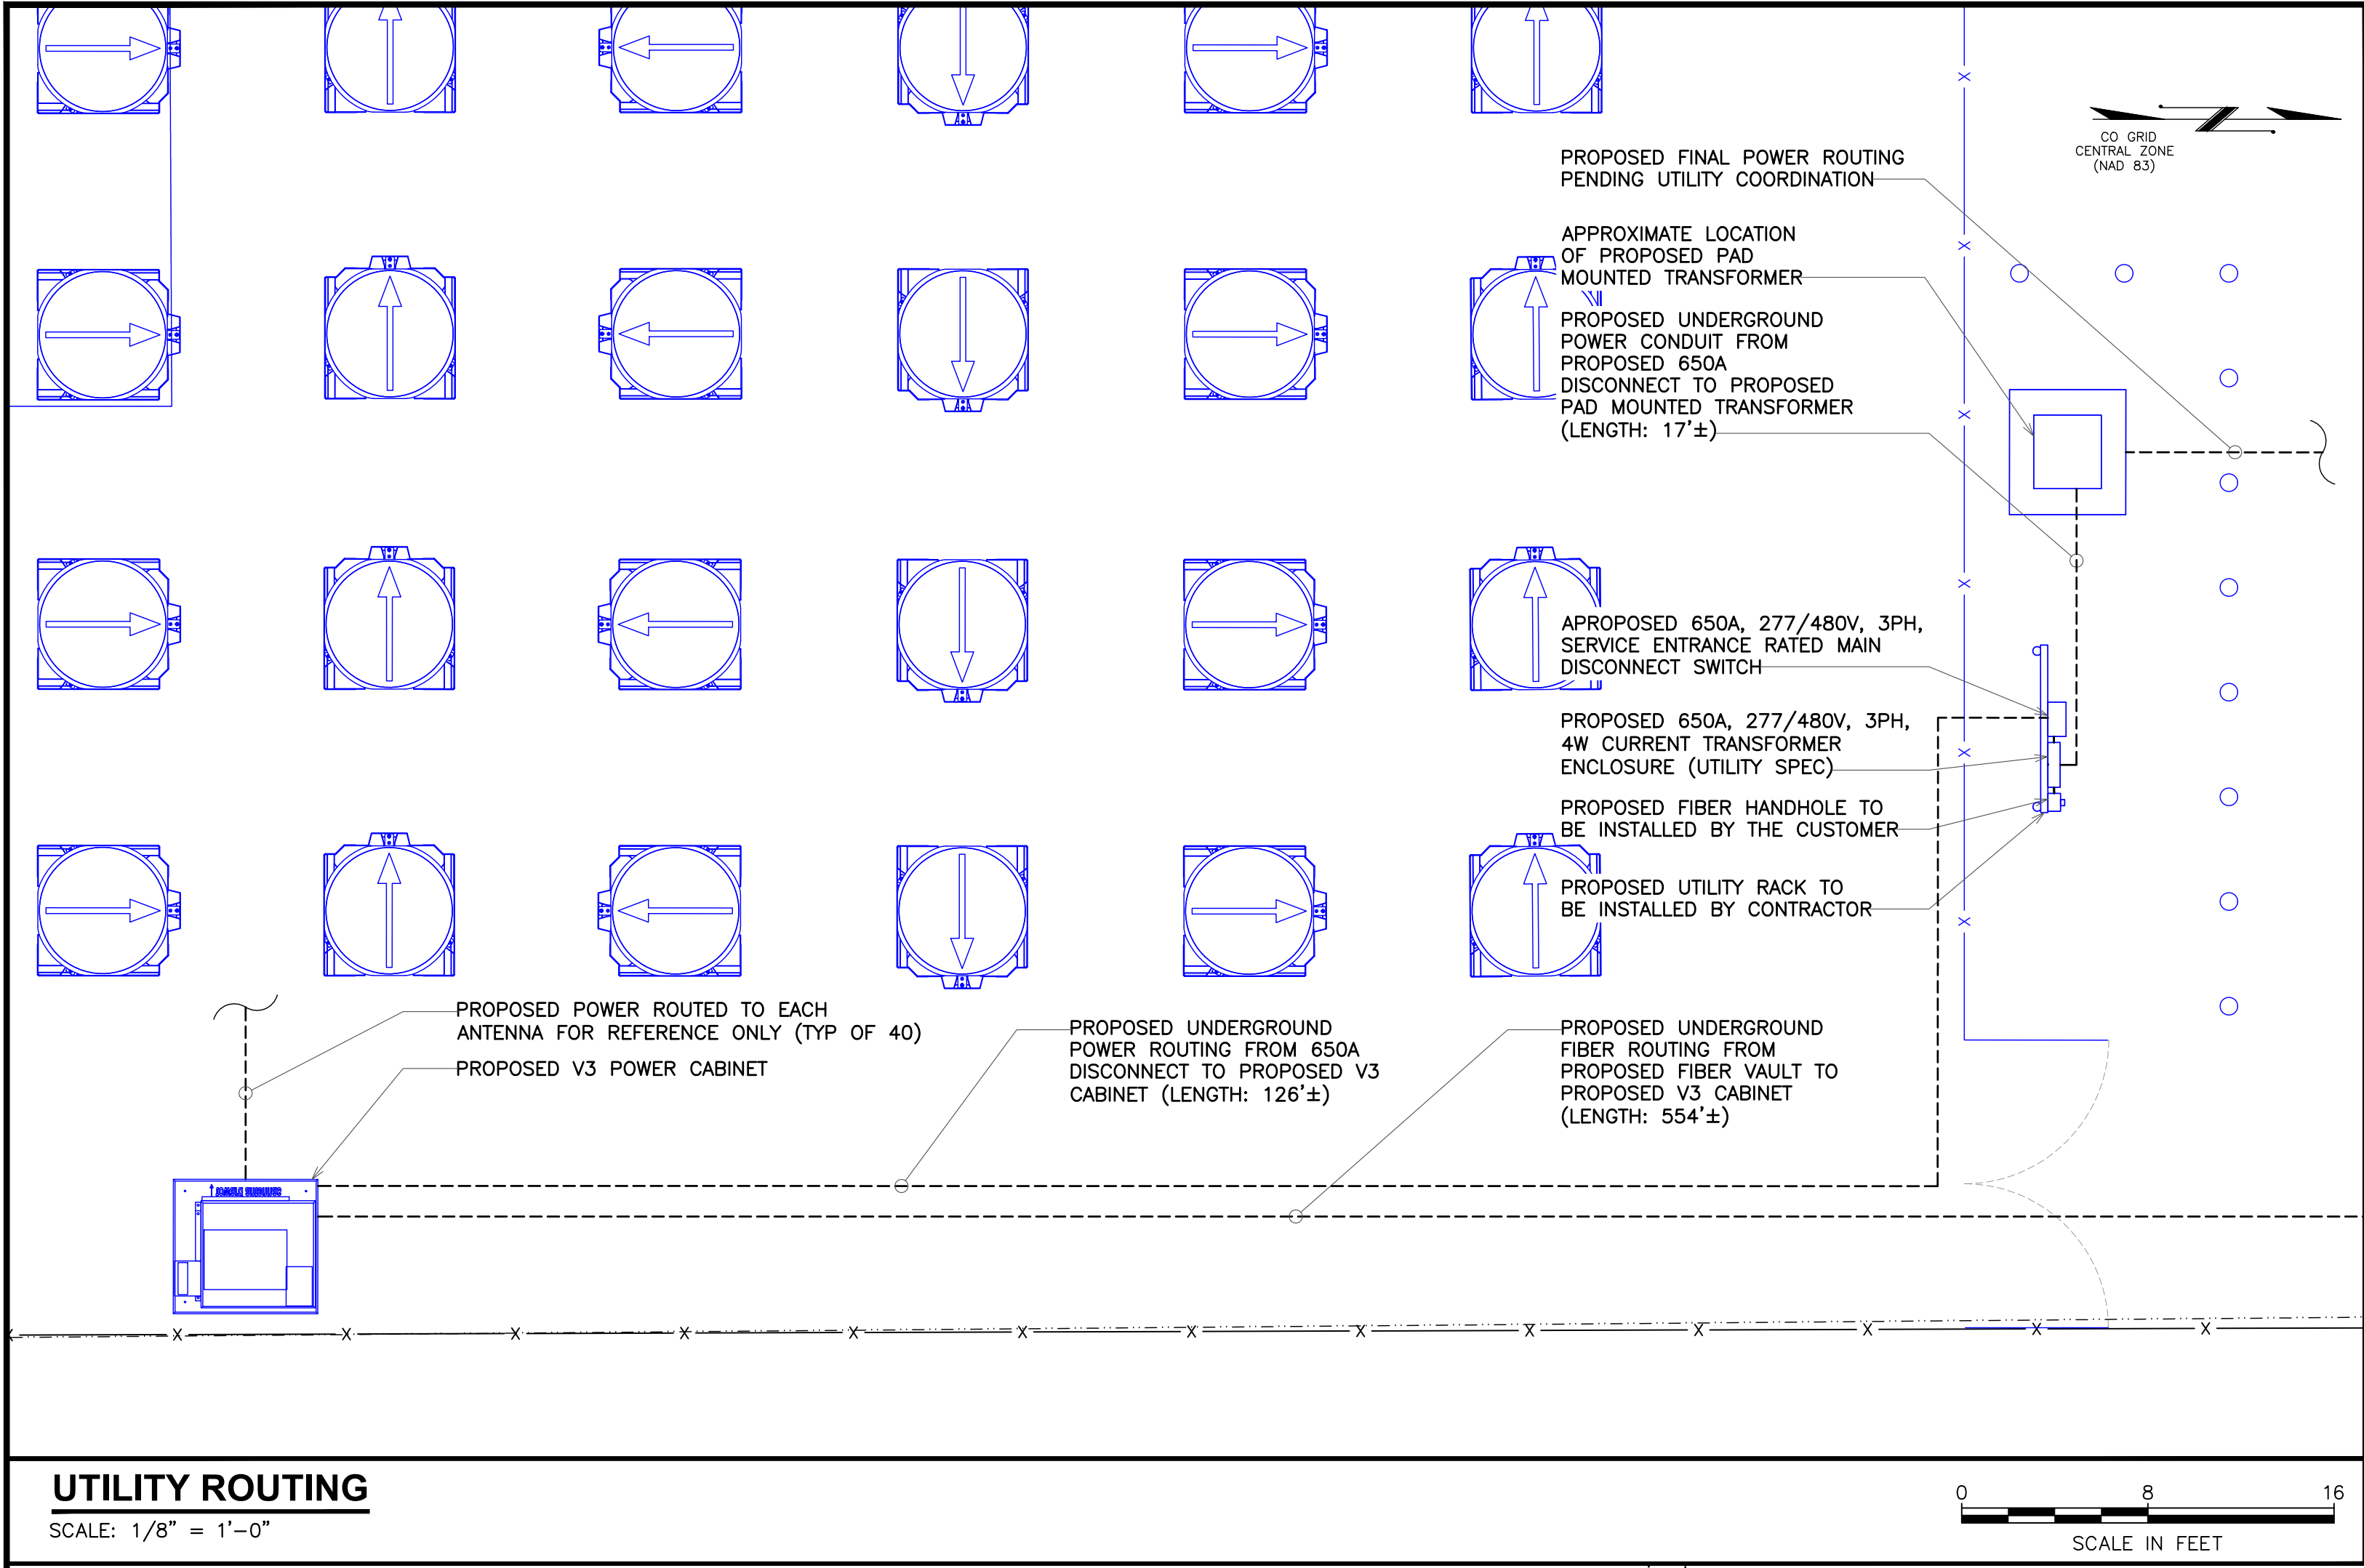

PLANS PREPARED BY:

CONSTRUCTION
CONSTRUCTION
CONSTRUCTION
CONSTRUCTION
PRELIMINARY
ISSUED FOR:

08-05-26
06-09-26
06-03-26
05-15-26
04-01-26
03-30-26

4
3
2
1
0
B
REV

CHECKED BY: JFJ

PROJECT INFORMATION:

SITE NAME:
COLORADO SPRINGS,
CO - 100KM
7233 SPACE VILLAGE AVE.
COLORADO SPRINGS, CO 80914
(EL PASO COUNTY)

SEAL:

08-05-26

UTILITY ROUTING

REVISION:
4

SHEET NUMBER:
E-1.2

TEP IS A FAMILY OF COMPANIES LICENSED TO PROVIDE DIFFERENT SERVICES IN DIFFERENT JURISDICTIONS. DEPENDING ON THE JURISDICTION, PROFESSIONAL ENGINEERING AND LAND SURVEYING SERVICES ARE PROVIDED BY TEP OPCO LLC, A DELAWARE LIMITED LIABILITY COMPANY. TEP ENGINEERING, LLC, A NORTH CAROLINA PROFESSIONAL LIMITED LIABILITY COMPANY, OR M&H ENGINEERING, LLC, A NEW YORK PROFESSIONAL LIMITED LIABILITY COMPANY. GENERAL CONTRACTOR SERVICES ARE PROVIDED BY TEP OPCO LLC, A DELAWARE LIMITED LIABILITY COMPANY. WE ACQUIRE THE REQUISITE LICENSES IN EACH STATE. ADDITIONAL INFORMATION CAN BE OBTAINED FROM THE COMPANY.