

SITE

THE CHURCH OF JESUS CHRIST OF LATTER-DAY SAINTS

PARKING ANNEX

950 CO-105
Monument, CO 80132

AGENCIES

OWNER:
LDS CHURCH - REAL EST DIV
50 E NORTH TEMPLE #509-8866
SALT LAKE CITY, UT 84150-9001
719-481-2909
CONTACT: SCOTT HOLLISTER
HollisterSJ@ChurchofJesusChrist.org

APPLICANT/ARCHITECT:
CRP ARCHITECTS
100 EAST ST. VRAIN STREET, SUITE 300
COLORADO SPRINGS, CO 80903
719-280-1033
CONTACT: BRUCE SMITH
bruce@crparchitects.com

ELECTRICAL/LIGHTING
ME ENGINEERS
1125 KELLY JOHNSON BLVD #301
COLORADO SPRINGS, CO 80920
719-536-0036
CONTACT: ERIC EIFELDT
eric.eifeldt@me-engineers.com



OWNERSHIP OF INSTRUMENTS OF SERVICE:
ALL REPORTS, PLANS, SPECIFICATIONS, COMPUTER FILES, FIELD DATA, NOTES AND OTHER DOCUMENTS AND INSTRUMENTS PREPARED BY DESIGN PROFESSIONAL AS INSTRUMENTS OF SERVICE SHALL REMAIN THE PROPERTY OF THE DESIGN PROFESSIONAL. THE DESIGN PROFESSIONAL SHALL RETAIN ALL COMMON LAW STATUTORY AND OTHER RESERVED RIGHTS INCLUDING THE COPYRIGHT THEREON.

CRP ARCHITECTS AIA
100 East St. Vrain, Suite 300
Colorado Springs, CO 80903

PARKING PLAN PHOTOMETRICS

SCALE: AS INDICATED

DATE: 04-26-2024
DRAWN BY: ELE
CHECKED: AM
REVISED: -

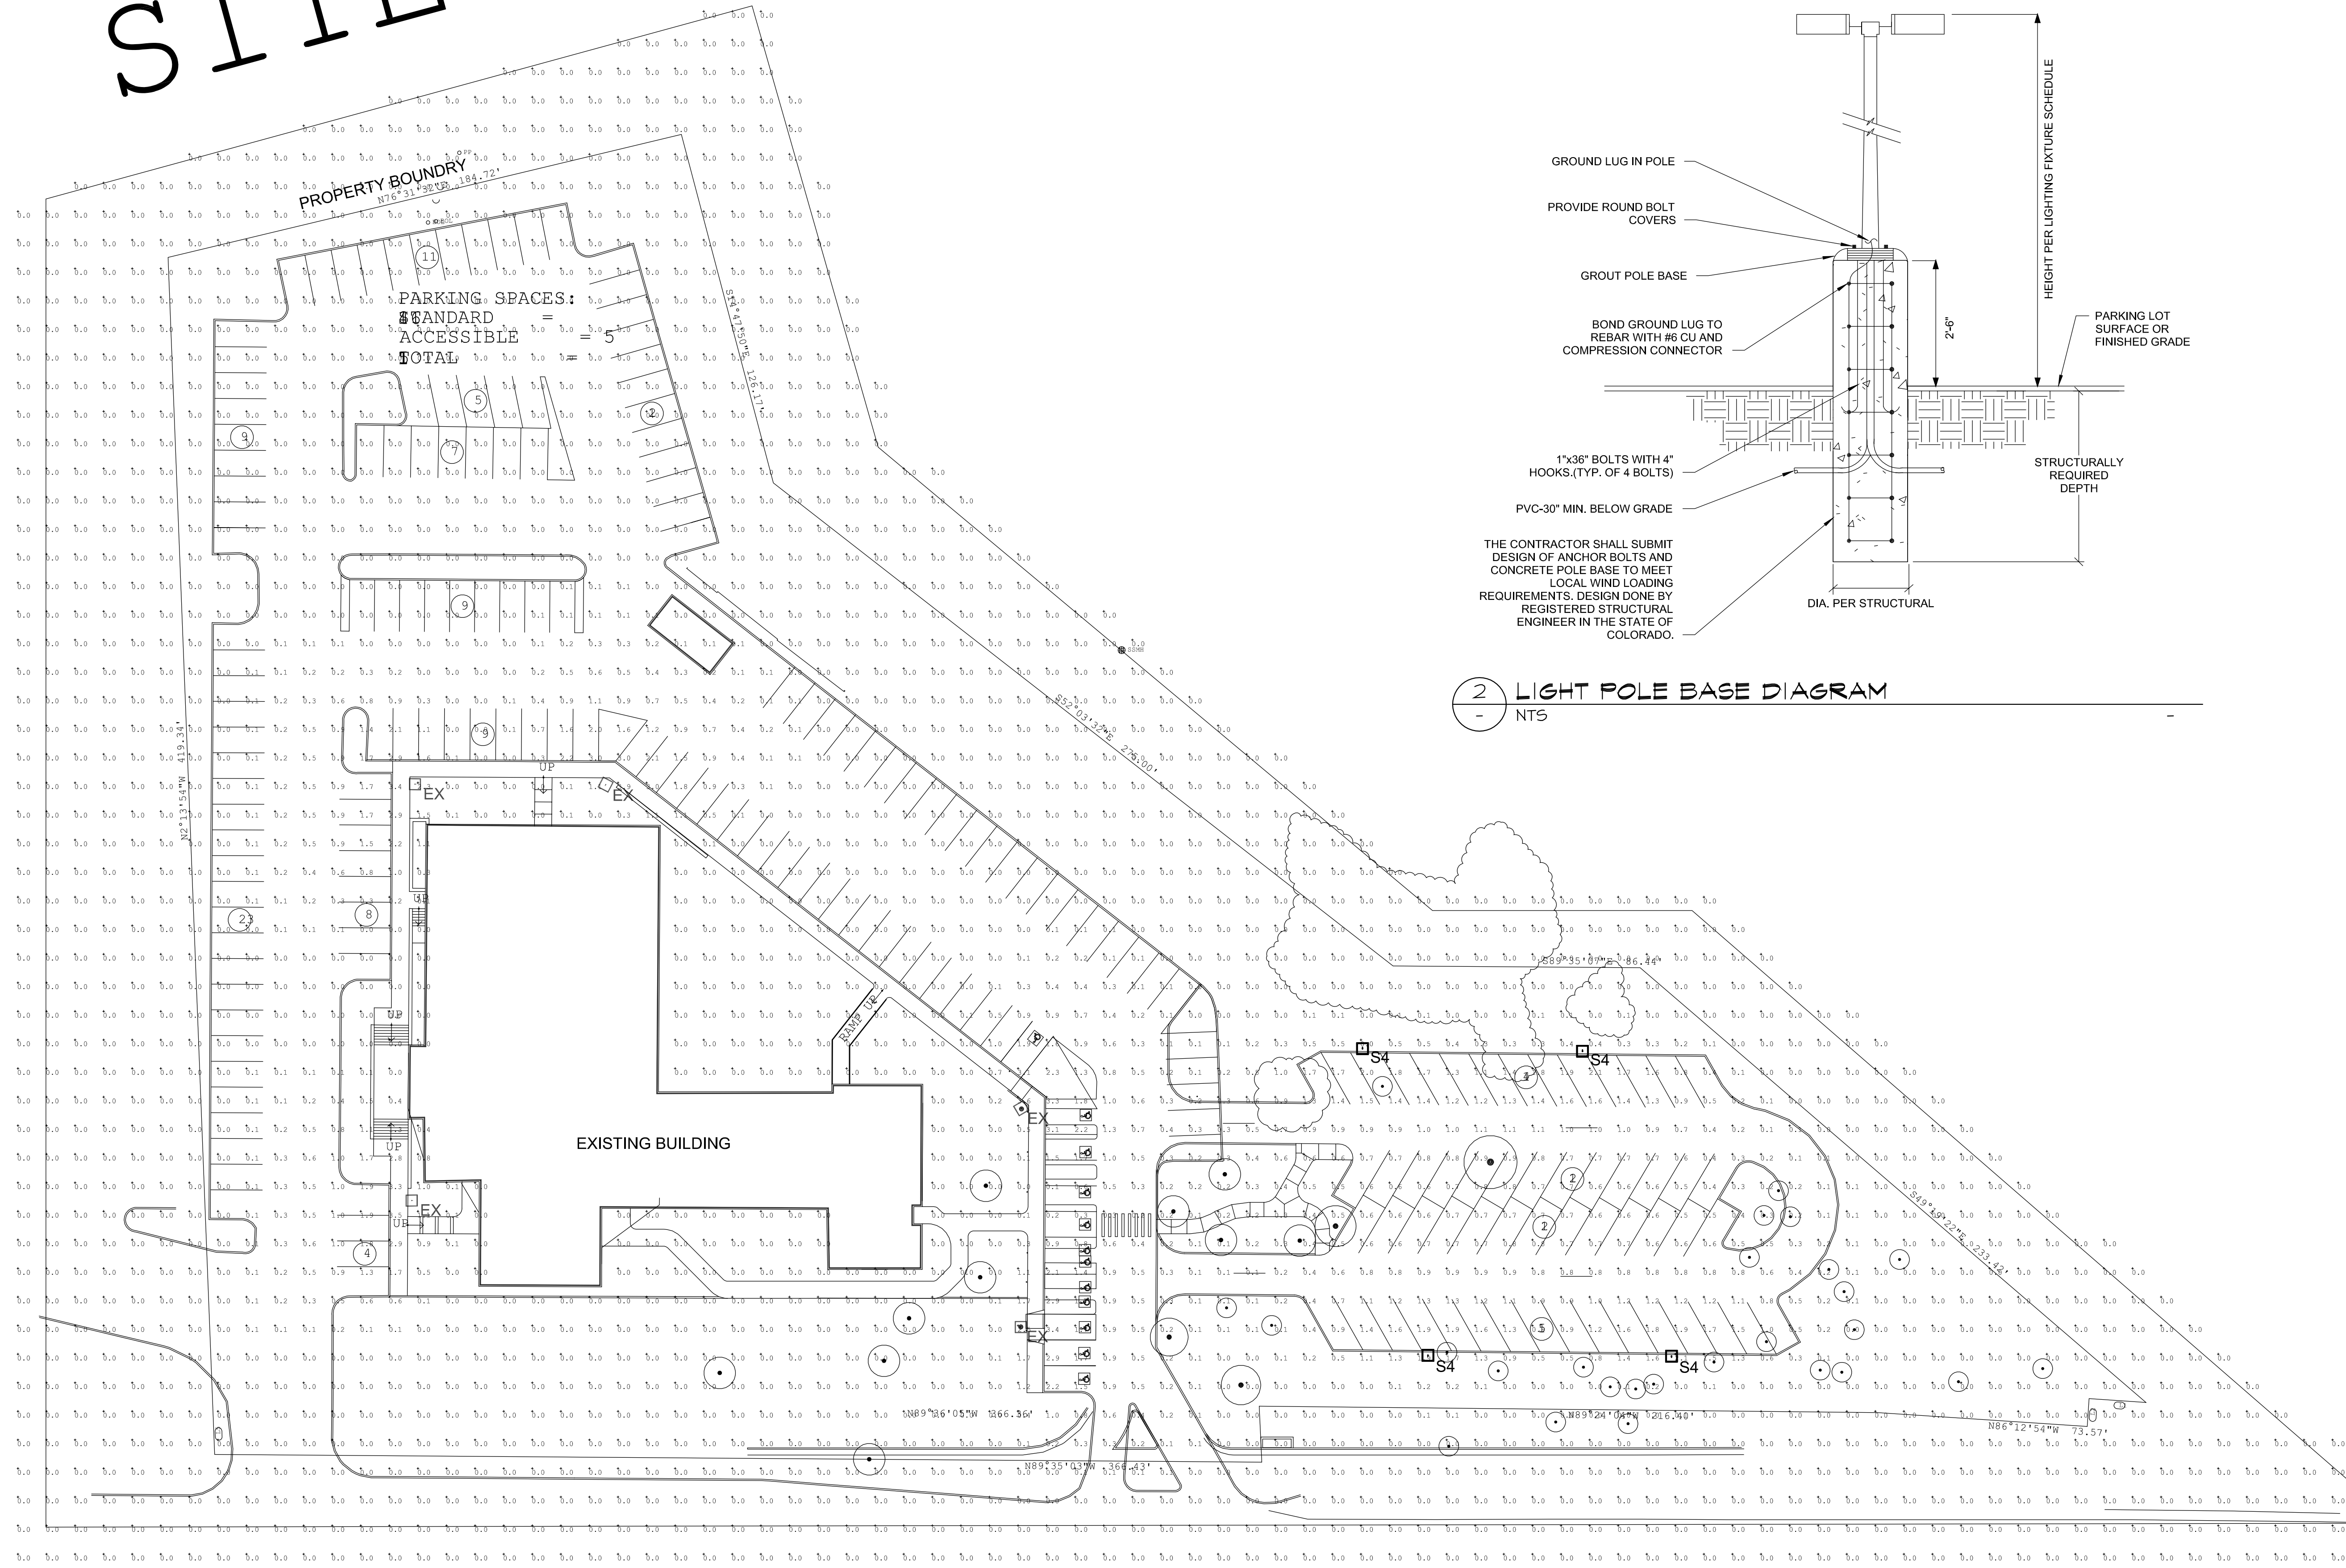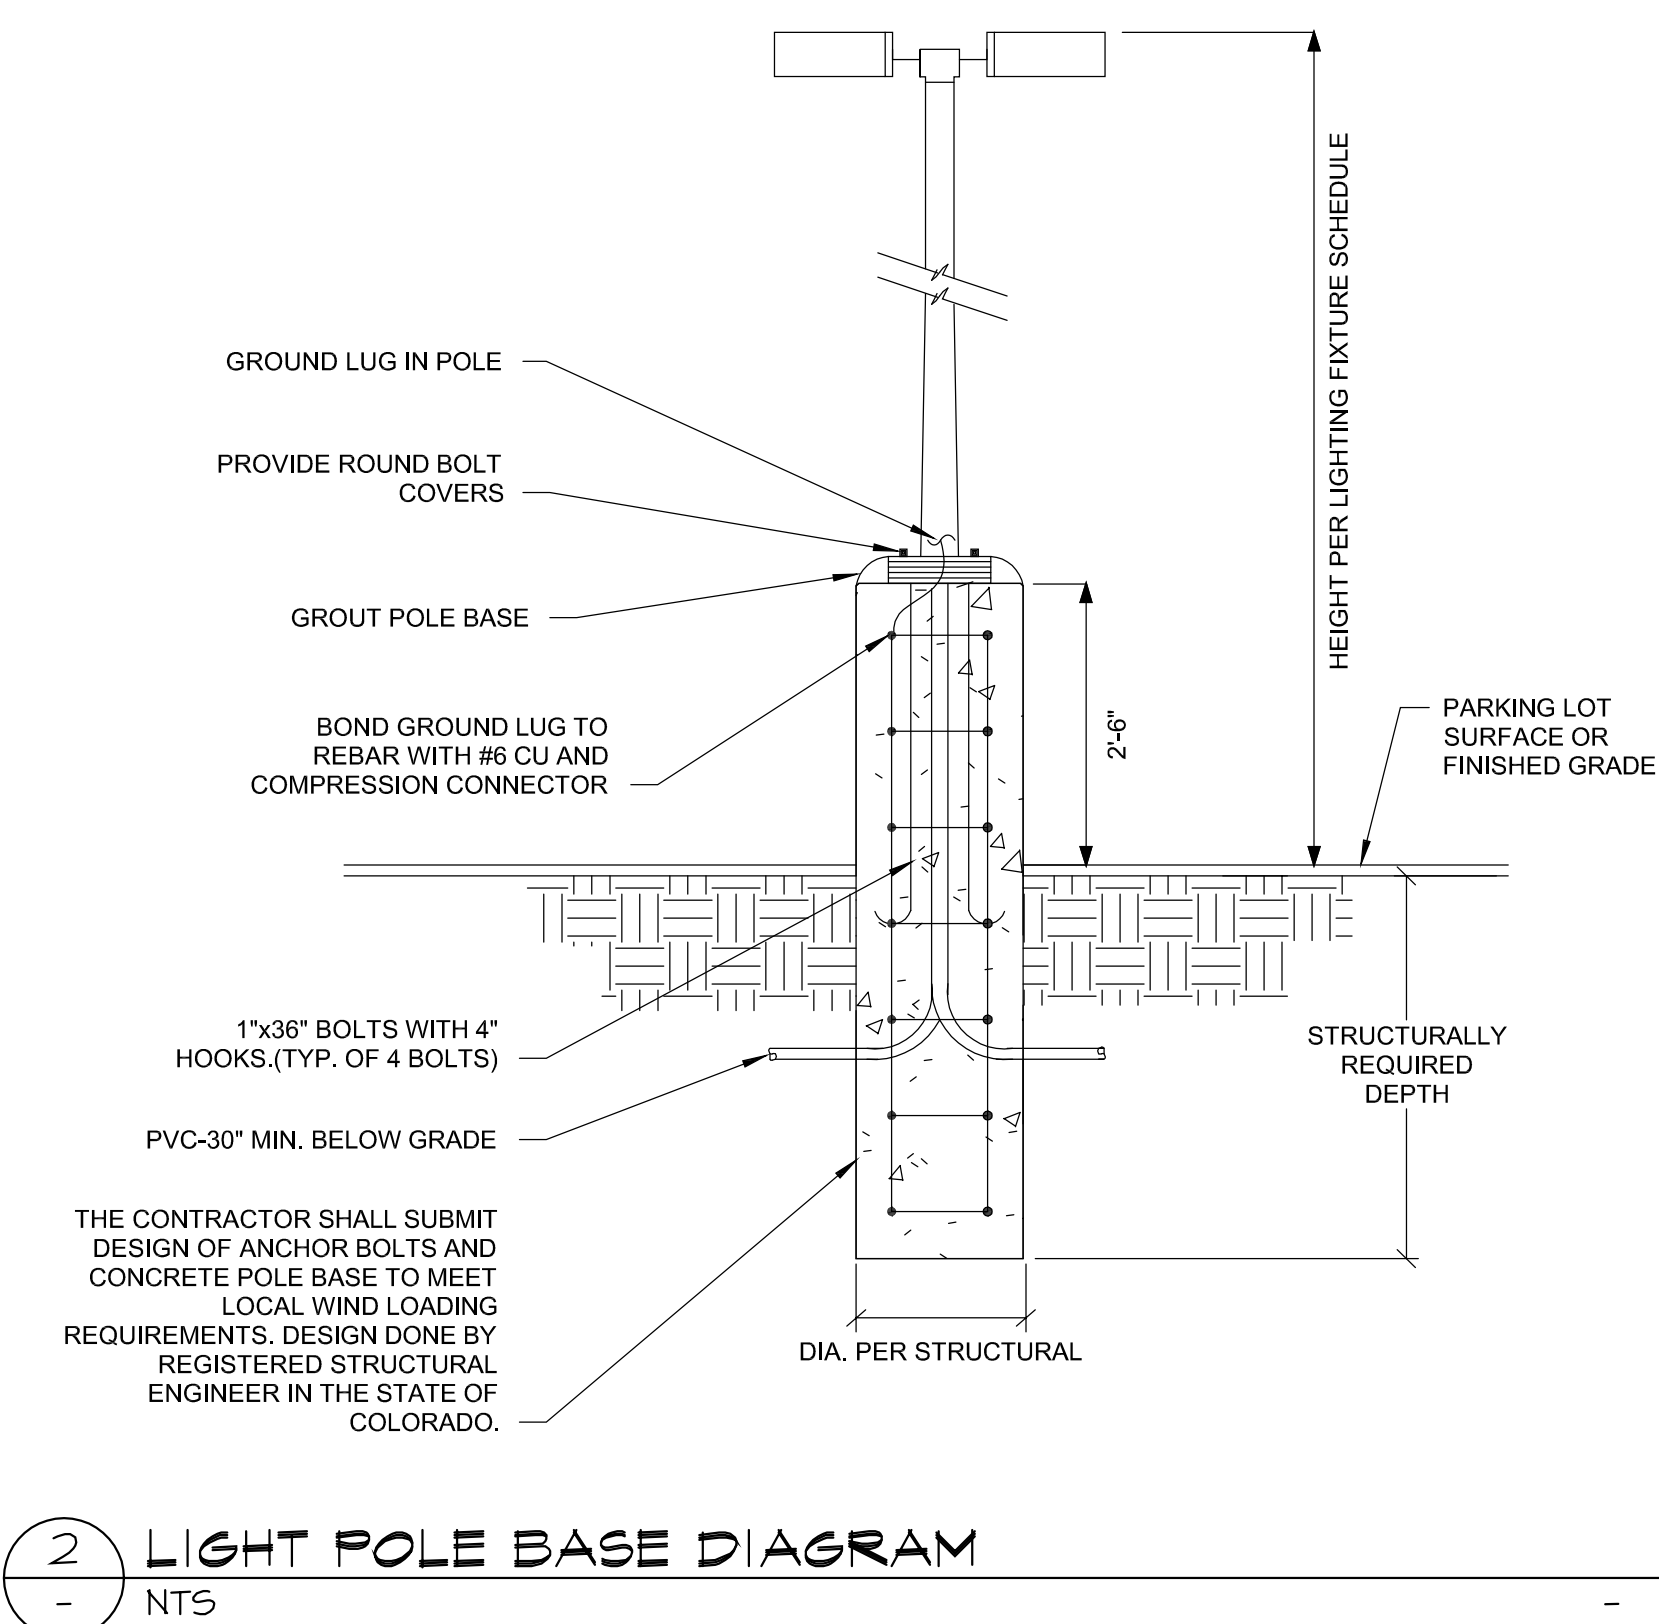

Luminaire Schedule									
Tag	Symbol	Qty	Label	Description	Arrangement	LLF	Luminaire Lumens	Luminaire Watts	Mounting Height (FT)
EX	□	5	EXISTING	EXISTING LED FIXTURE	SINGLE	0.850	5852	57	15
S4	□	4	GALN-SA1C-740-U-SL4-HSS_5852	GALLEON II, (1) 1000mA SQUARE LED, 70 CRI, 4000K, 120-277V, TYPE IV DISTRIBUTION W/ SPILL CONTROL, HOUSE SIDE SHIELD	SINGLE	0.850	5852	57	20