

#	Date	Issue / Description	Init.


Project No: HPT01
 Drawn By: ASA/MRK
 Checked By: CRD
 Date: AUGUST 2023



AUSTIN BLUFFS PARKWAY (PARKWAY)
120' CITY OF COLORADO SPRINGS RIGHT-OF-WAY

1 PHOTOMETRIC PLAN
SCALE: 1"=20'-0"

LUMINAIRE SCHEDULE									
SYMBOL	QTY	LABEL	MOUNTING HEIGHT	COLOR	LF	MODEL NUMBER	DESCRIPTION	WATTS	LUMENS
[Symbol]	3	SP	15'-0" A.F.G.	BLACK	1.0	DSX0-LED-P6-40K-70CRI-T3M-MVOLT-SPA-HS-DBLXD	LITHONIA LIGHTING, D-SERIES SIZE 0 LED AREA LUMINAIRE, FULL CUT-OFF, 3000K CCT, BLACK COLOR, P2 OPTICS, TYPE TSM DISTRIBUTION, WITH REAR MOUNTED SHIELD, MOUNTED ON 12'-0" POLES WITH 3'-0" CONCRETE BASE. TOTAL MOUNTING HEIGHT=15'-0"	46	5,140

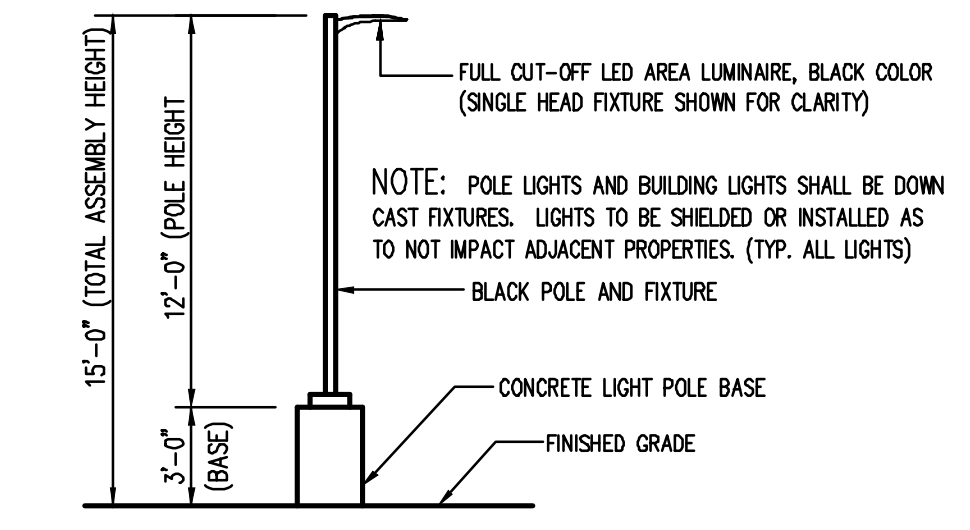

2 AREA LIGHT DETAIL
SCALE: NOT TO SCALE

D-Series Size 0 LED Area Luminaire

Specifications

EPA: 0.68 ft (203mm)
 Length: 26.18" (670mm)
 Width: 14.06" (357mm)
 Height H1: 2.26" (58mm)
 Height H2: 7.66" (195mm)
 Weight: 2.2 lbs (1kg)

Introduction

The modern styling of the D-Series features a highly refined aesthetic that blends seamlessly with its environment. The D-Series offers the benefits of the latest in LED technology into a high performance, high efficacy, long-life luminaire.

The photometric performance results in sites with excellent uniformity, greater pole spacing and lower power density. D-Series outstanding photometry aids in reducing the number of poles required in area lighting applications, with typical energy savings of 70% and expected service life of over 100,000 hours.

Ordering Information

EXAMPLE: DSX0 LED P6 40K 70CRI T3M MVOLT SPA NLTAR2 PIRHN DBXBD

Series	Units	Color Temperature	Color Rendering Index	Manufacturer	EMF	Type of luminaire	Shipped	Mounting
DSX0 LED	Forward optics FF1 P5 FF2 P6 FF3 P7 FF4 P8 Reverse optics RR1 P5 RR2 P6 RR3 P7 RR4 P8	(5000K CCT) 40K 5000K 5000K 5000K 5000K 40K 5000K 5000K 5000K 5000K	(90) 90 90 90 90 90 90 90 90 90 90	(TSM) TSM TSM TSM TSM TSM TSM TSM TSM TSM TSM	ASR TSM TSM TSM TSM TSM TSM TSM TSM TSM TSM	Type II medium Type II medium Type II medium Type II medium Type II medium Type II medium Type II medium Type II medium Type II medium Type II medium Type II medium	DBXBD (DBX) DBXBD (DBX) DBXBD (DBX) DBXBD (DBX) DBXBD (DBX) DBXBD (DBX) DBXBD (DBX) DBXBD (DBX) DBXBD (DBX) DBXBD (DBX) DBXBD (DBX)	SPA SPA SPA SPA SPA SPA SPA SPA SPA SPA SPA

LITHONIA LIGHTING, D-SERIES SIZE 0 LED AREA LUMINAIRE, FULL CUT-OFF, 3000K CCT, BLACK COLOR, P2 OPTICS, TYPE TSM DISTRIBUTION, WITH REAR MOUNTED SHIELD, MOUNTED ON 12'-0" POLES WITH 3'-0" CONCRETE BASE. TOTAL MOUNTING HEIGHT=15'-0"