


A1 ELECTRICAL SITE PLAN
 1" = 30'-0"
 0' 4' 8' 16'
 PLAN NORTH

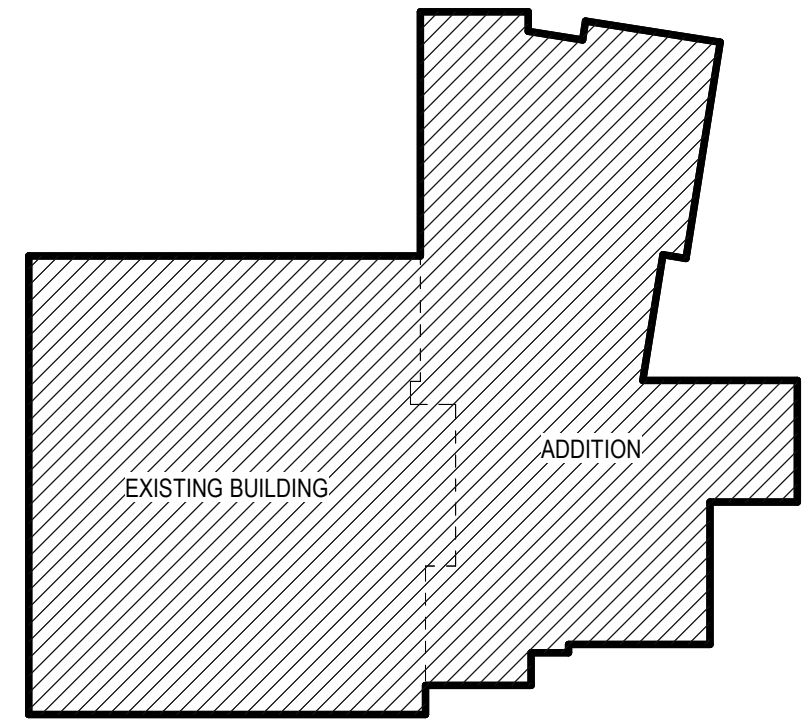

KEY PLAN

PRAIRIE HEIGHTS ELEMENTARY SCHOOL
 7830 INDIAN VILLAGE HEIGHTS, FOUNTAIN, CO

NOT FOR CONSTRUCTION

REVISION	DATE
DESIGN DEVELOPMENT	
Project Number	024159.00
Date	JANUARY 20, 2025
Drawn By	ESD
Checked By	SMB
Copyright:	
ALL DRAWN AND WRITTEN INFORMATION APPEARING HEREIN SHALL NOT BE DUPLICATED, DISCLOSED OR OTHERWISE USED WITHOUT THE WRITTEN CONSENT OF MOA ARCHITECTURE	

Sheet Name
 ELECTRICAL SITE PLAN
 PHOTOMETRICS