



**GENERAL NOTES**

SHEET SPECIFIC GENERAL INFORMATION AND/OR INSTRUCTION

1. PROVIDE SEALED EXPANSION JOINT AT ALL INTERNAL CORNERS.
2. ELEVATIONS OF CURVED WALLS HAVE BEEN 'FLATTENED' FOR CLARITY.

**REFERENCE KEYNOTES**

SHEET SPECIFIC IDENTIFICATION OF ITEMS DIRECTLY REFERENCED TO CORRESPONDING ARCHITECTURAL SPECIFICATION SECTIONS IN THE PROJECT MANUAL. THE DECIMAL AND SUFFIX NUMBERS / LETTERS ARE NOT IDENTIFIED IN SPECIFICATIONS.


- 05 5000.05 BOLLARD
- 07 6200.2C PRE-FINISHED GALVANIZED STEEL SHEET METAL - COPING
- 07 6200.2DS PRE-FINISHED GALVANIZED STEEL SHEET METAL - DOWNSPOUT ASSEMBLY
- 07 6200.2G PRE-FINISHED GALVANIZED STEEL SHEET METAL - GUTTER ASSEMBLY
- 10 4300 EMERGENCY AID SPECIALTIES

**SHEET KEYNOTES**


NUMBERING IS GROUPED BY TYPE / PHASE OF WORKSHEET OF NON-ARCHITECTURAL ITEMS OR INFORMATIONAL / INSTRUCTIONAL NOTATION. SOME NUMBERS MAY BE SKIPPED ON ANY GIVEN DRAWING SHEET.

- 202 MECHANICAL EQUIPMENT, RE: MECHANICAL DETAILS
- 203 MASONRY VENEER DOWN TO T.O. FOOTING, TYP. RE: FOUNDATION DETAILS
- 206 HSS PIPE COLUMNS - PAINT
- 207 CMU BASE, CMU COLOR 3
- 208 LAMB'S TONGUE ROOF DRAIN DISCHARGES, RE: PLUMBING
- 211 CMU TRASH ENCLOSURE, CMU COLOR 1, RE: SITE PLAN
- 212 GAS PIPING, RE: PLUMBING
- 213 LIGHT FIXTURE, RE: ELECTRICAL


**MP1 PATTERN LEGEND** 1/2" = 1'-0"

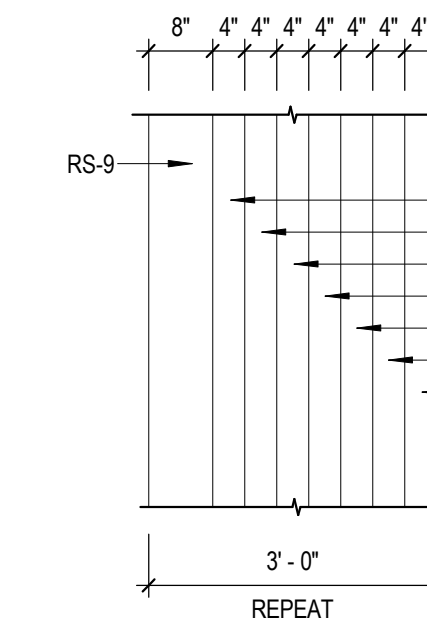

**CV1 CORNER LEGEND** 1/4" = 1'-0"

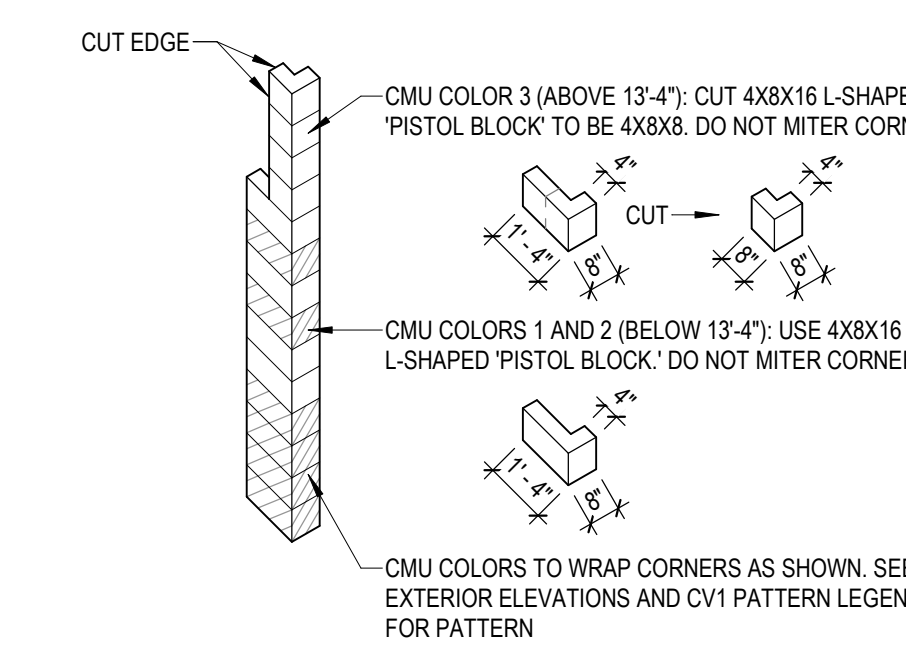


**CV1 PATTERN LEGEND** 1/4" = 1'-0"

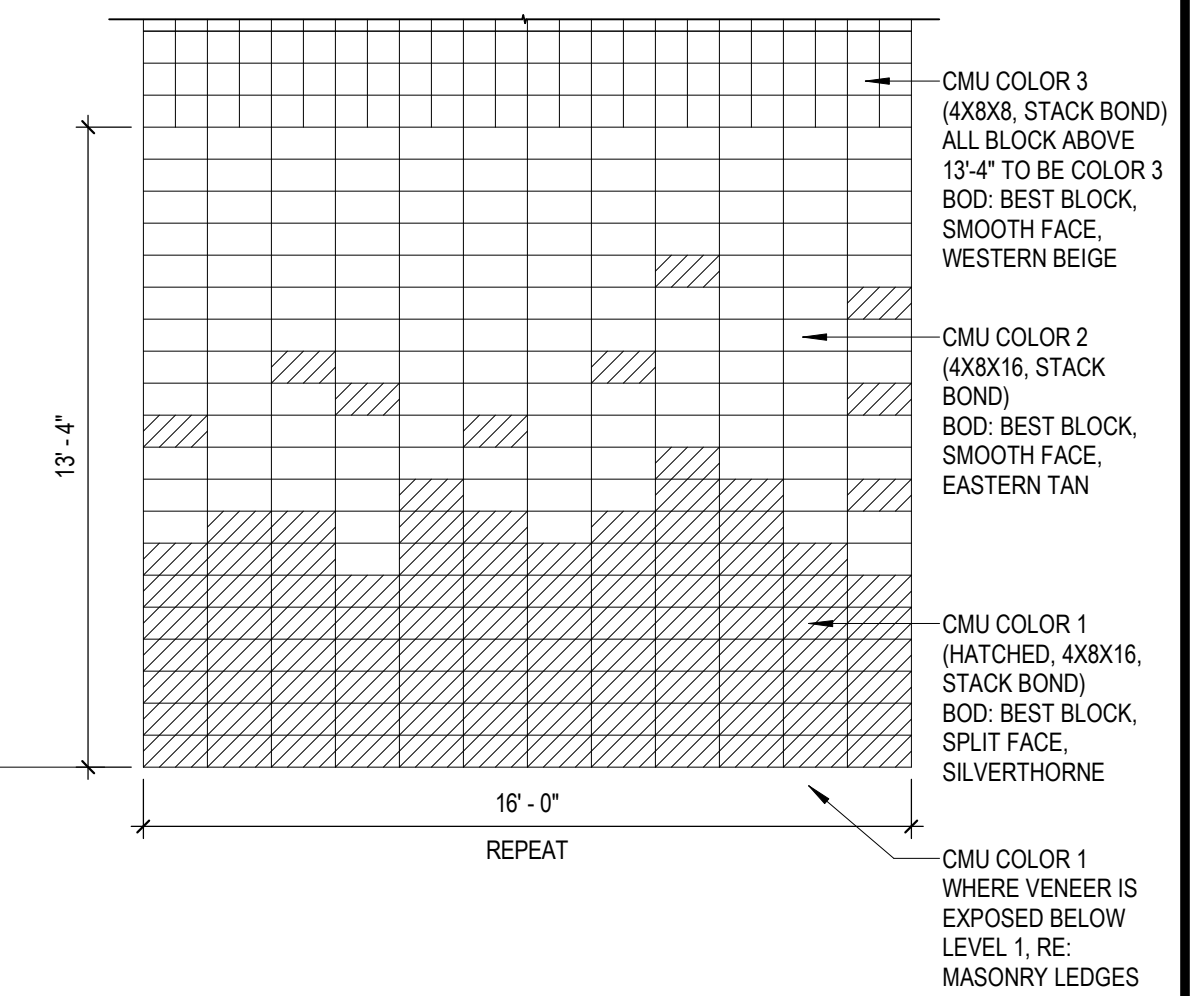


**WALL CLADDING LEGEND**


- CV1 - CMU VENEER - SEE LEGEND ABOVE
- CV2 - CMU VENEER
- CMU COLOR 1, 4X8X16
- MP1 - METAL WALL PANEL BASIS OF DESIGN: BERRIDGE REVEAL SERIES, RS-725 AND RS-9
- MP2 - METAL FASCIA PANEL BASIS OF DESIGN: BERRIDGE FW-1025, COLOR TO MATCH STANDING SEAM ROOF

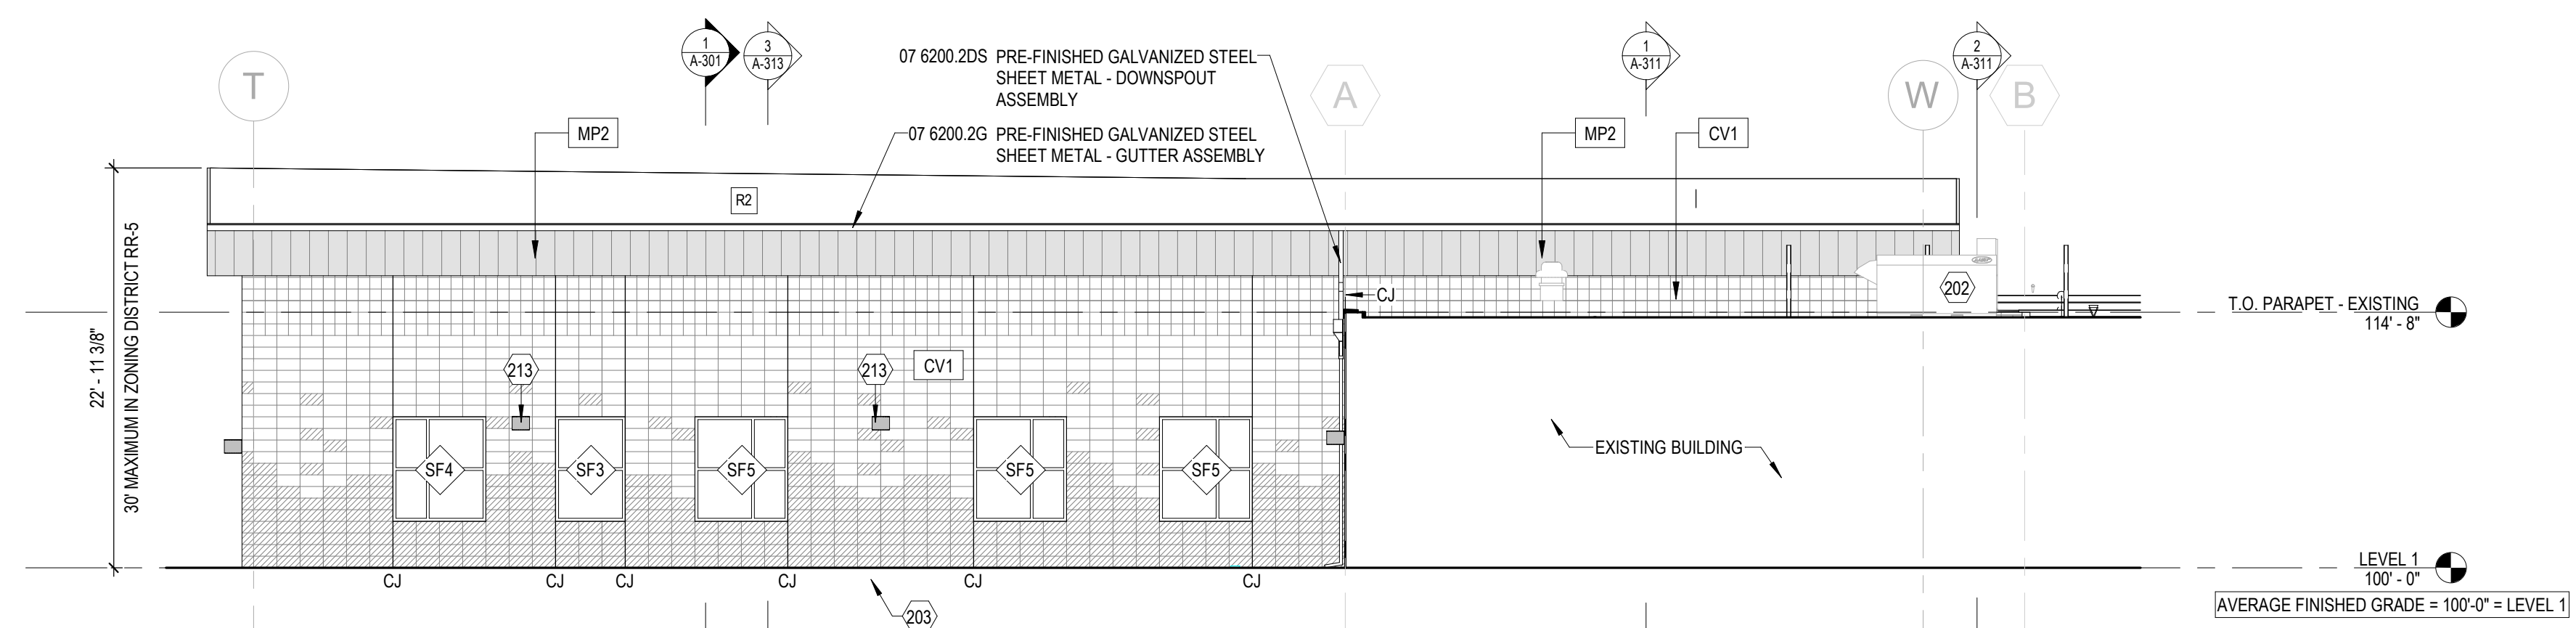


5 WEST ELEVATION  
1/8" = 1'-0"

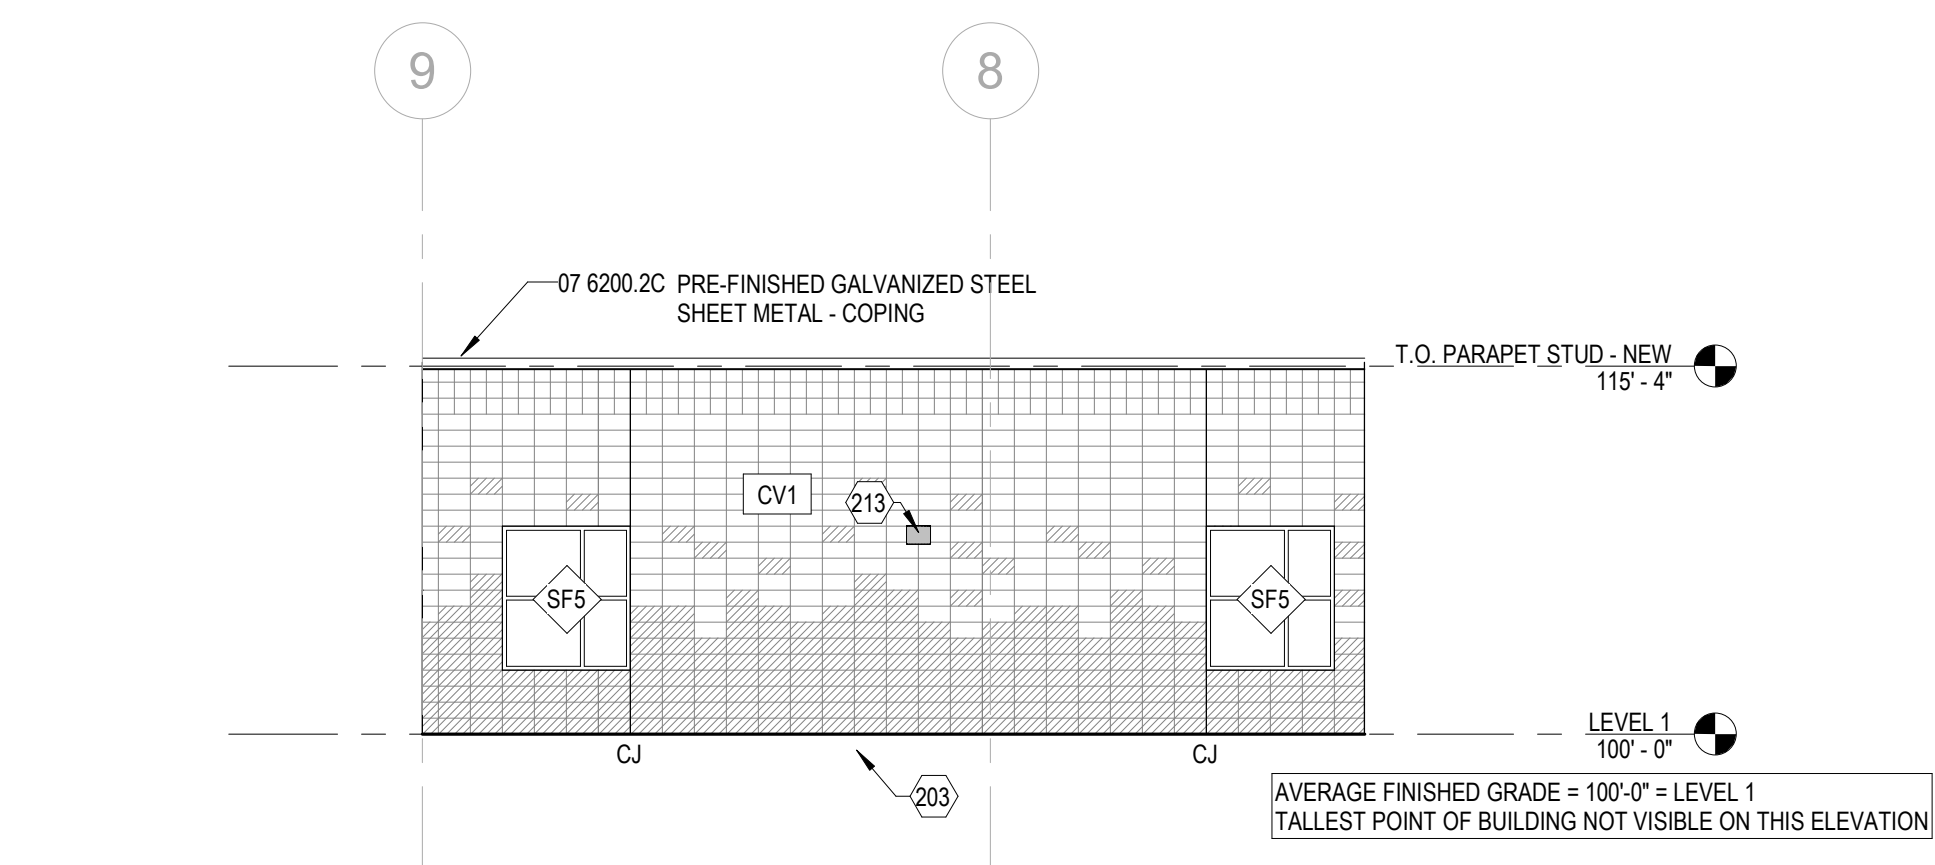


3 NORTH ELEVATION - OUTDOOR CLASSROOM  
1/8" = 1'-0"

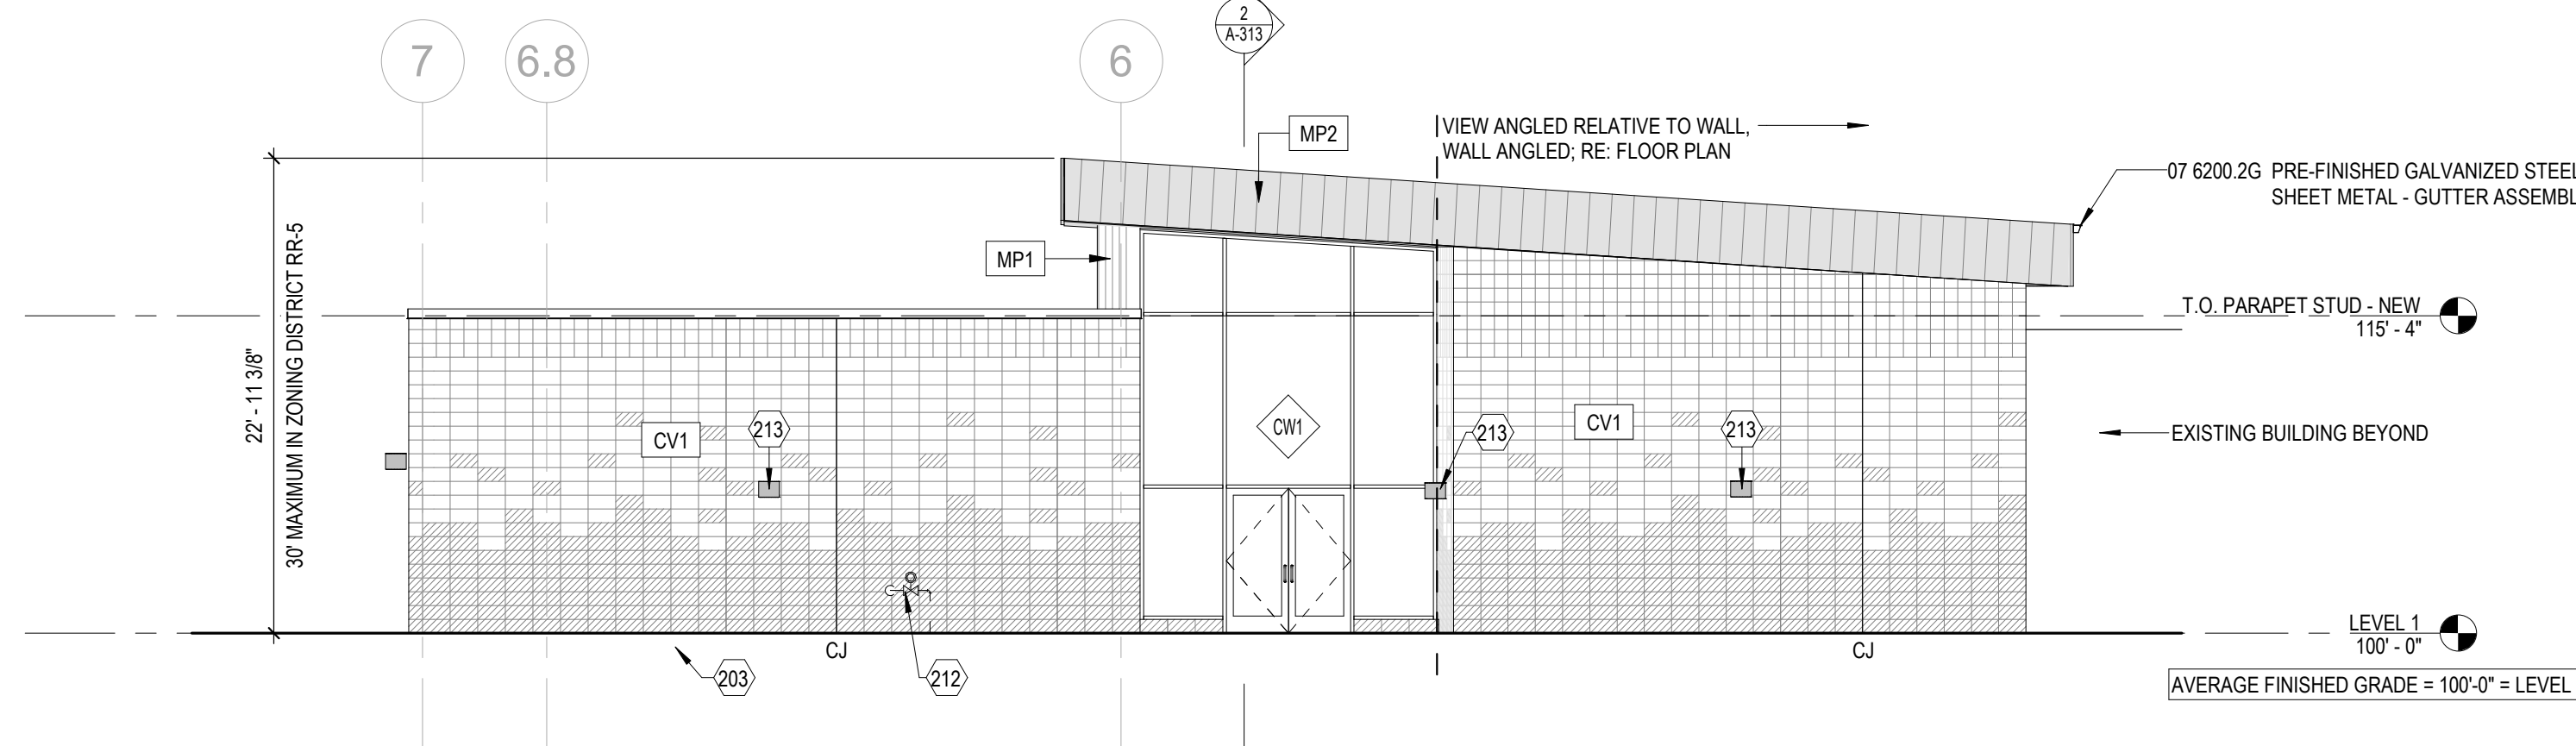


4 NORTH ELEVATION  
1/8" = 1'-0"

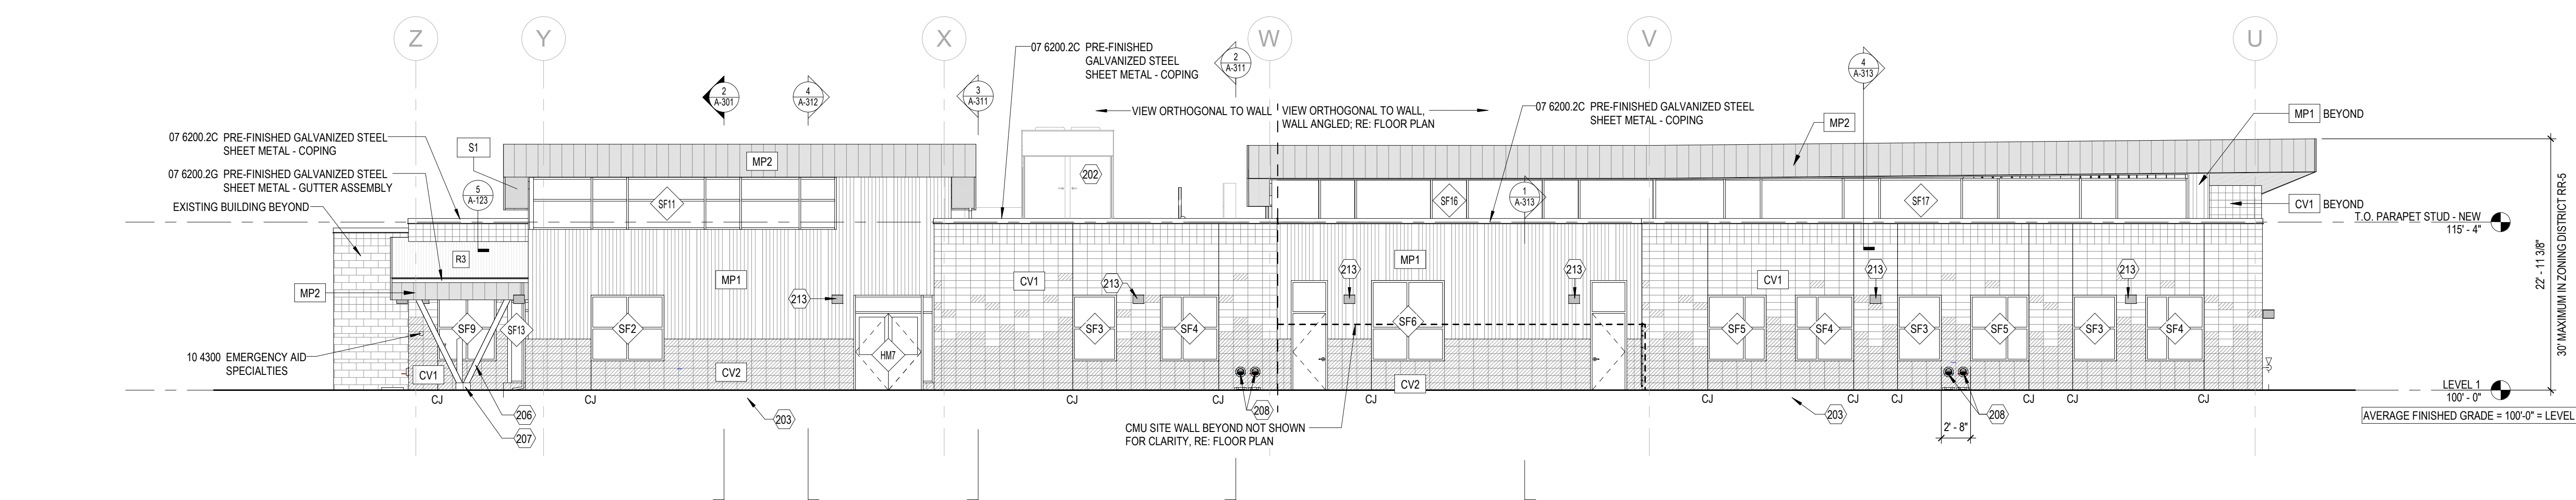

2 EAST ELEVATION  
1/8" = 1'-0"

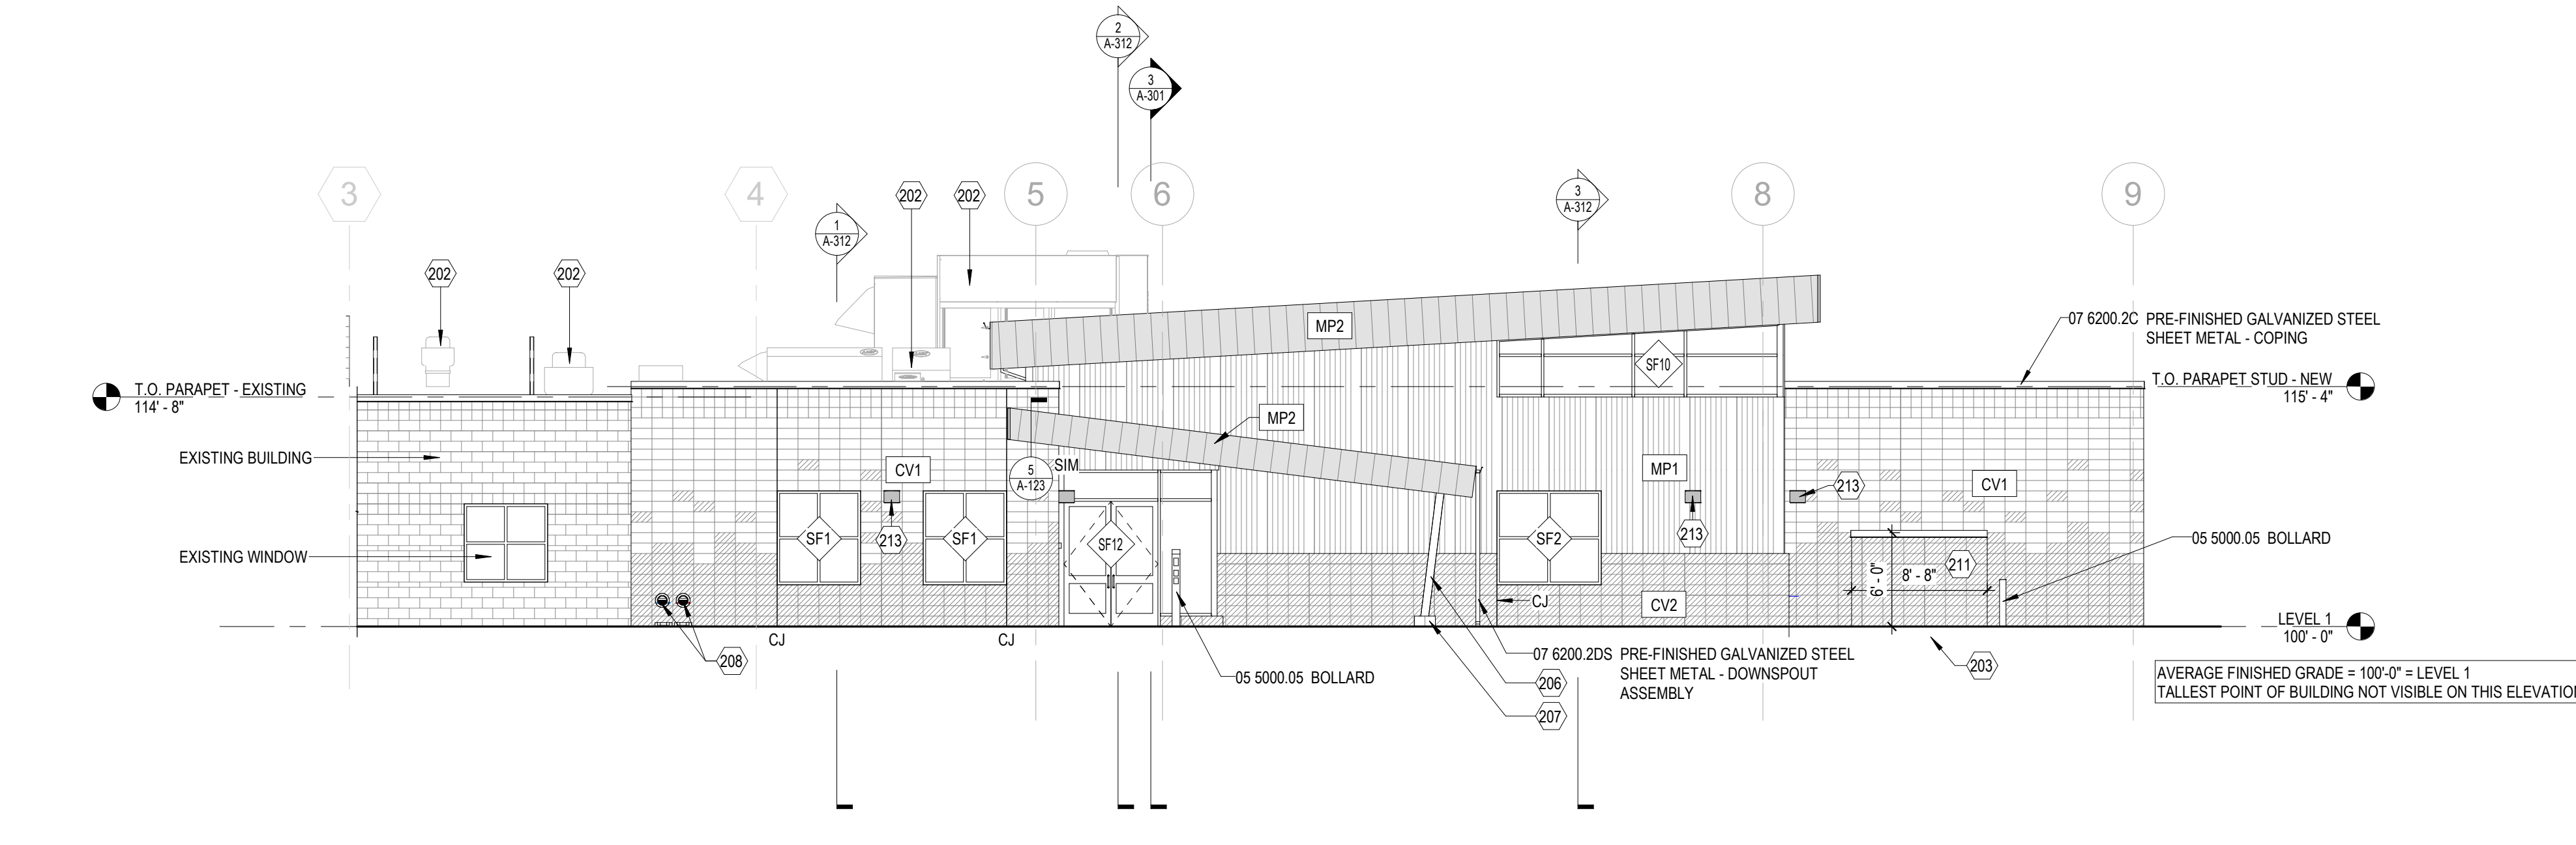

1 SOUTH ELEVATION  
1/8" = 1'-0"

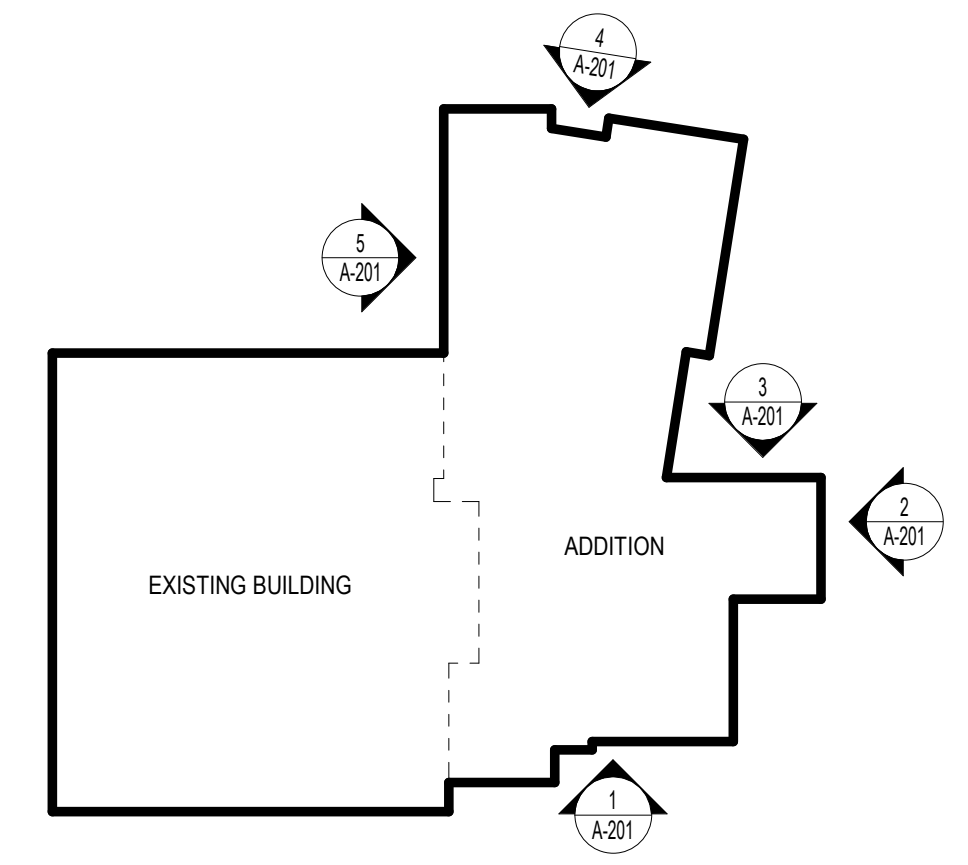

KEY PLAN

NOT FOR CONSTRUCTION

REVISION	DATE
DESIGN DEVELOPMENT	
Project Number	024159.00
Date	JANUARY 10, 2025
Drawn By	Author
Checked By	Checker
Copyright:	
ALL DRAWN AND WRITTEN INFORMATION APPEARING HEREIN SHALL NOT BE DUPLICATED, DISCLOSED OR OTHERWISE USED WITHOUT THE WRITTEN CONSENT OF MOA ARCHITECTURE	

Sheet Name  
EXTERIOR BUILDING ELEVATIONS