




PRAIRIE HEIGHTS ELEMENTARY SCHOOL
 7830 INDIAN VILLAGE HEIGHTS, FOUNTAIN, CO

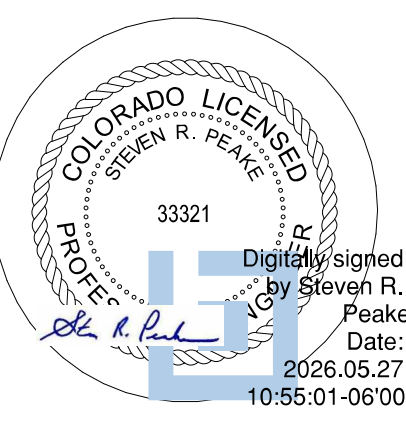


PG 19	5222926
REVISION	DATE
CONSTRUCTION DOCUMENTS	
Project Number	024159.00
Date	MARCH 14, 2025
Drawn By	ESD
Checked By	SMF
Copyright:	
ALL DRAWN AND WRITTEN INFORMATION APPEARING HEREIN SHALL NOT BE DUPLICATED, DISCLOSED OR OTHERWISE USED WITHOUT THE WRITTEN CONSENT OF MOA ARCHITECTURE	

Sheet Name
 ELECTRICAL SITE PLAN
 PHOTOMETRICS

ES102

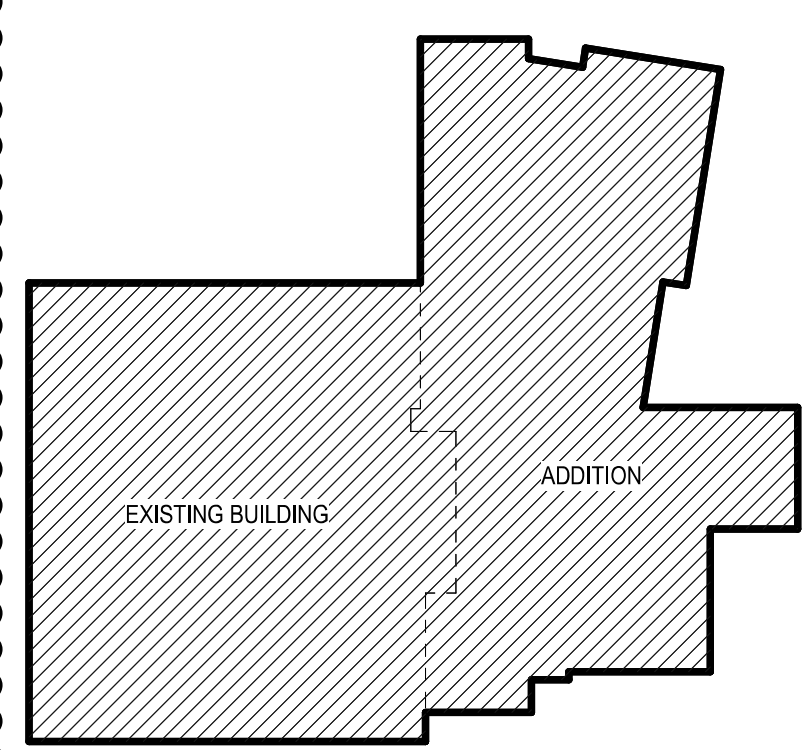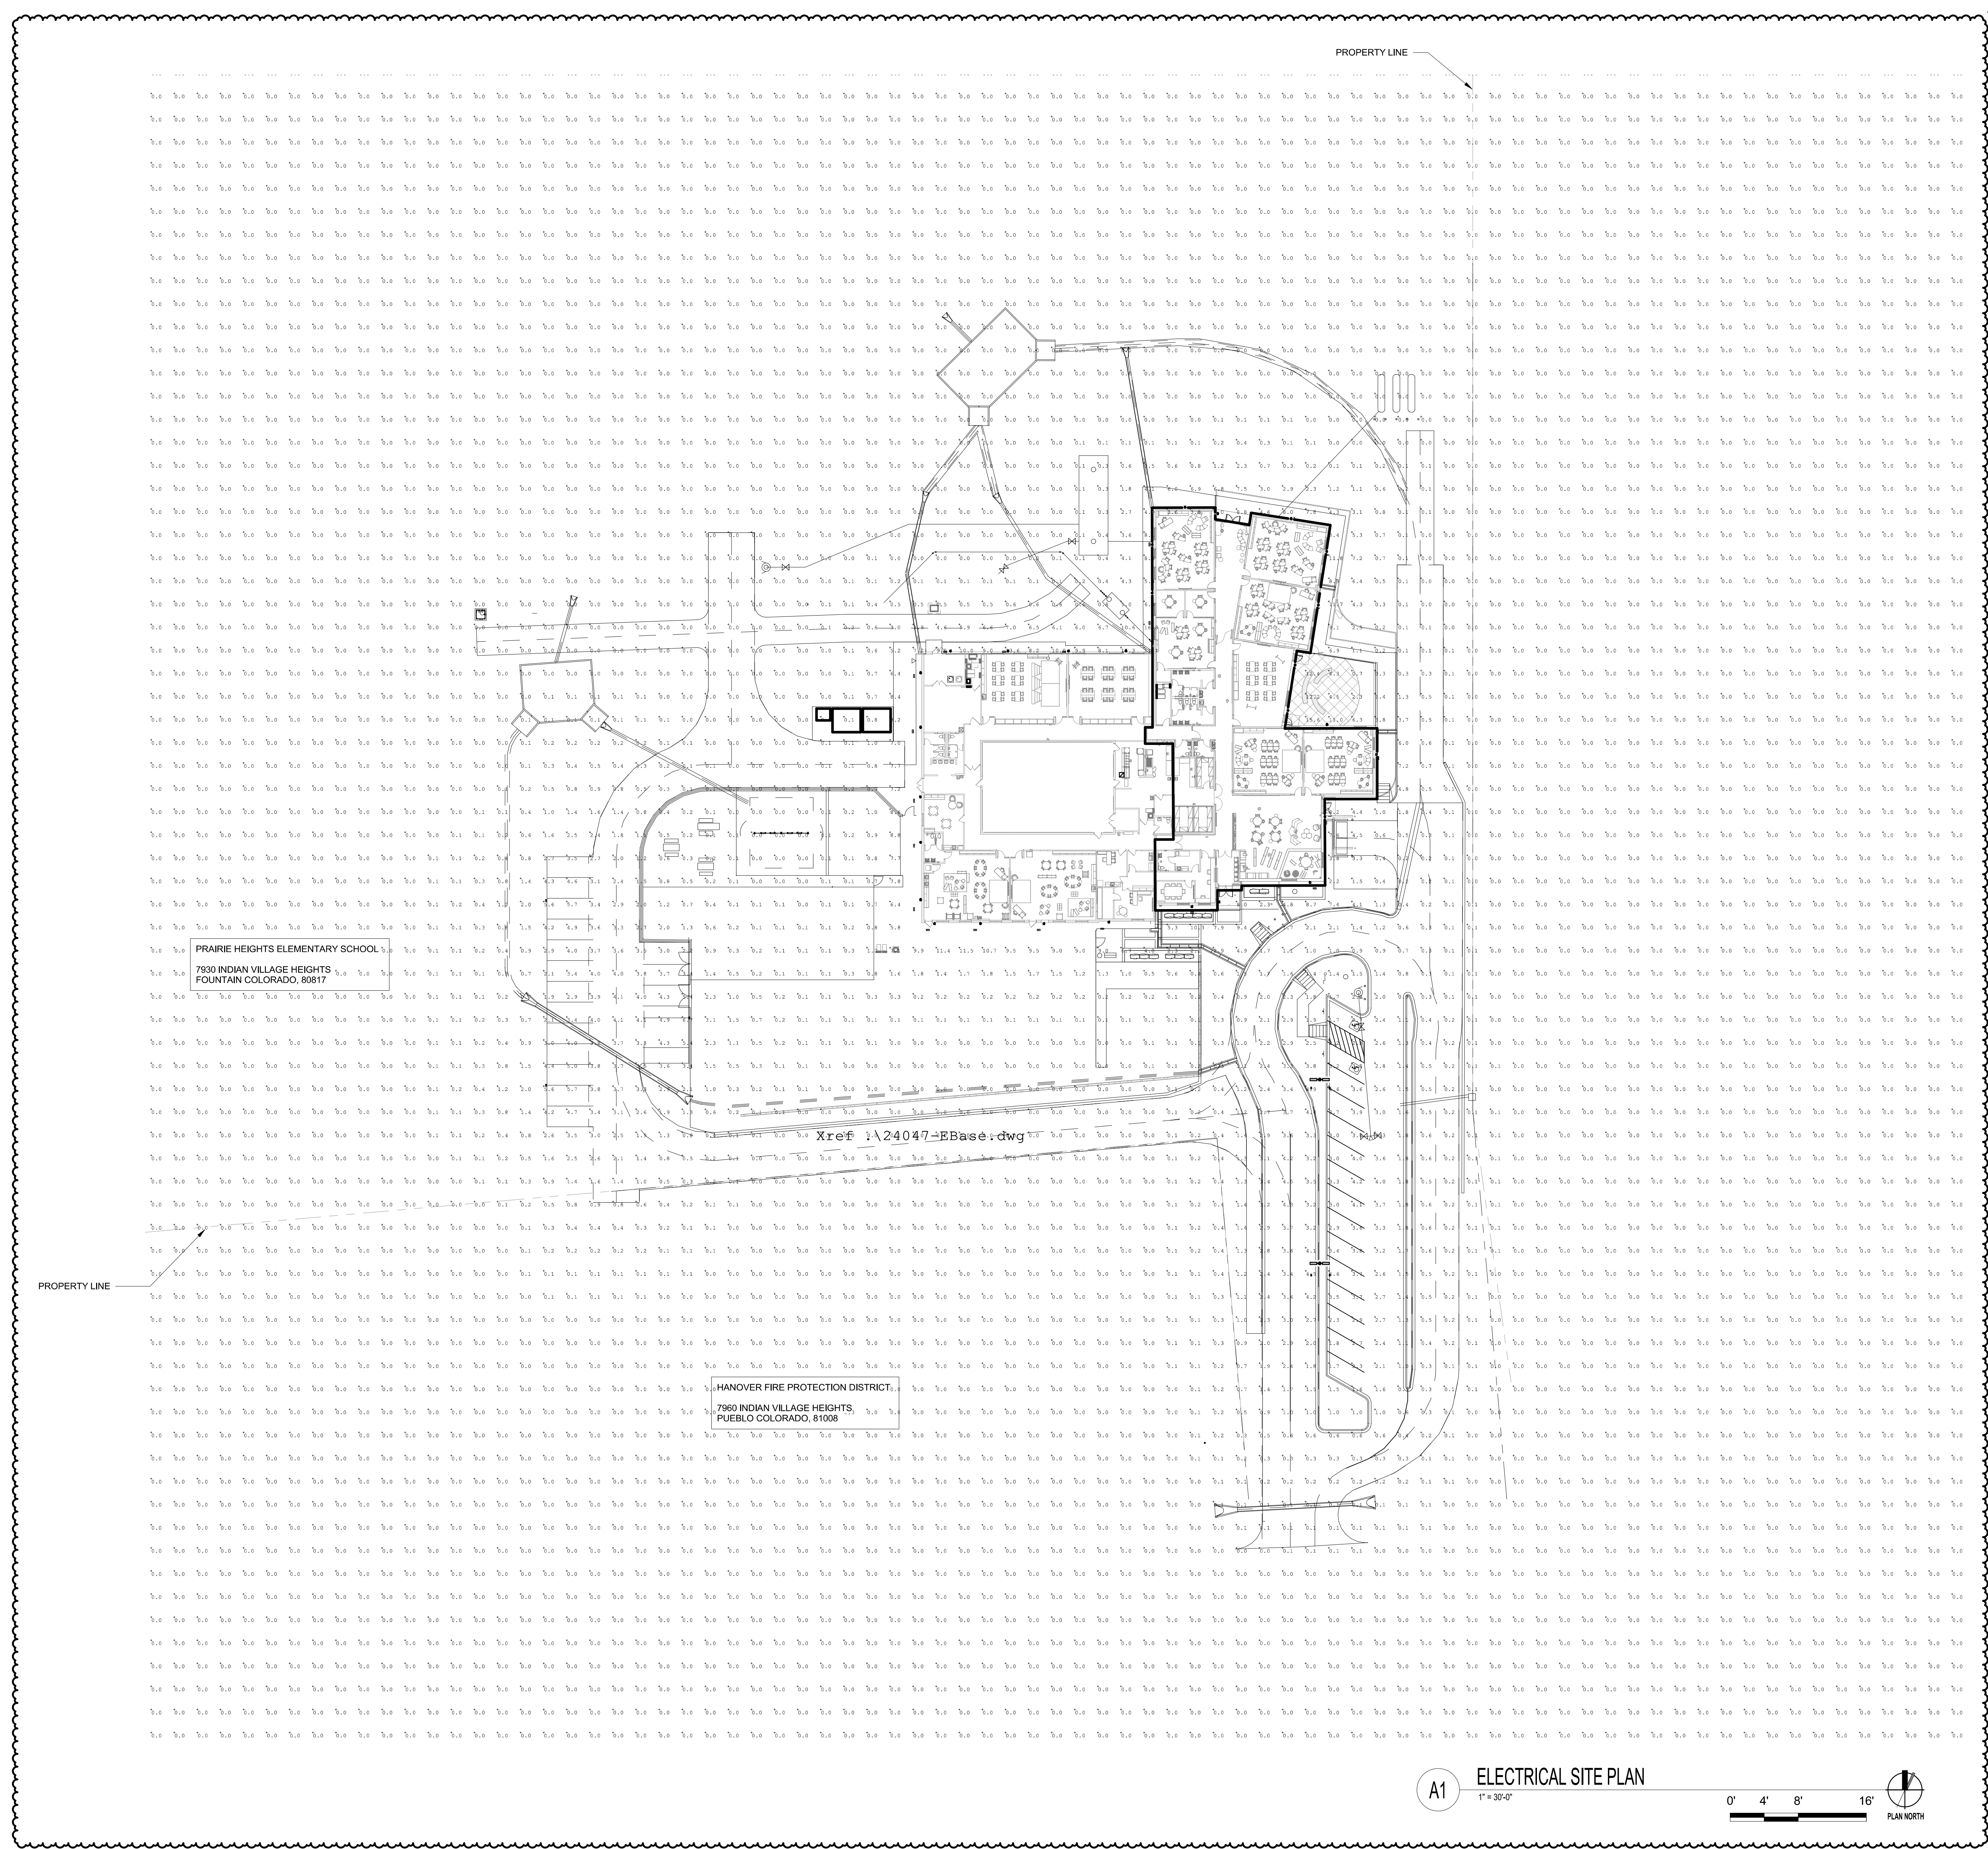

A1 ELECTRICAL SITE PLAN
 1" = 30'-0"

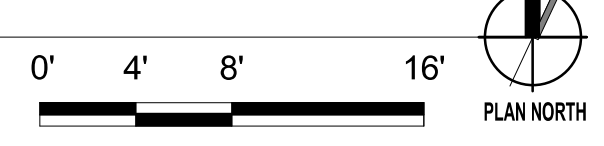

Autodesk Docs://HSD Prairie Heights/007_MEP_Hanover District 28 Prairie Heights ES.rvt
 5/27/2025 9:04:04 AM
 Bridgers & Paxton Project No. 9027