

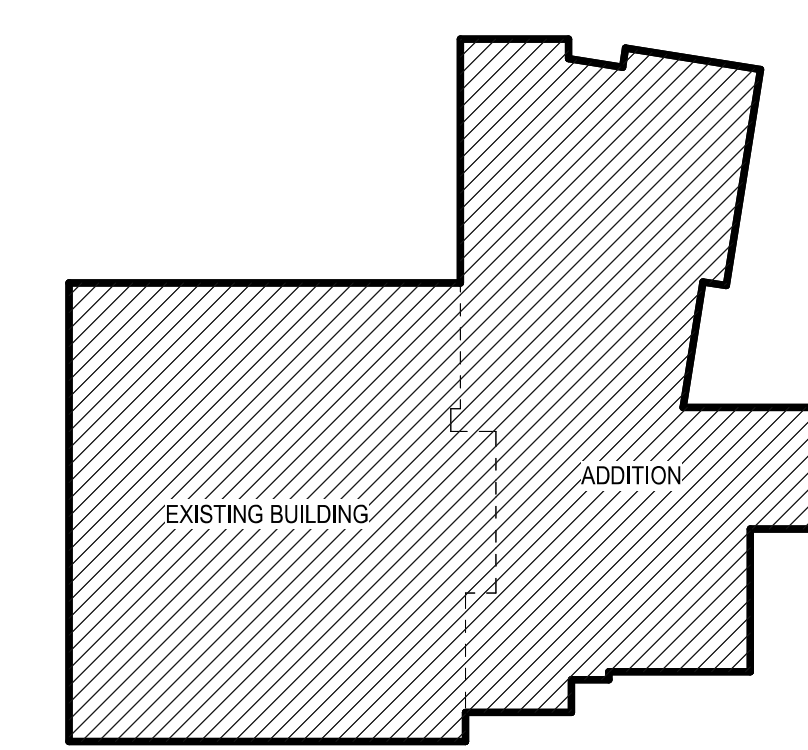


PRAIRIE HEIGHTS ELEMENTARY SCHOOL
 7830 INDIAN VILLAGE HEIGHTS, FOUNTAIN, CO

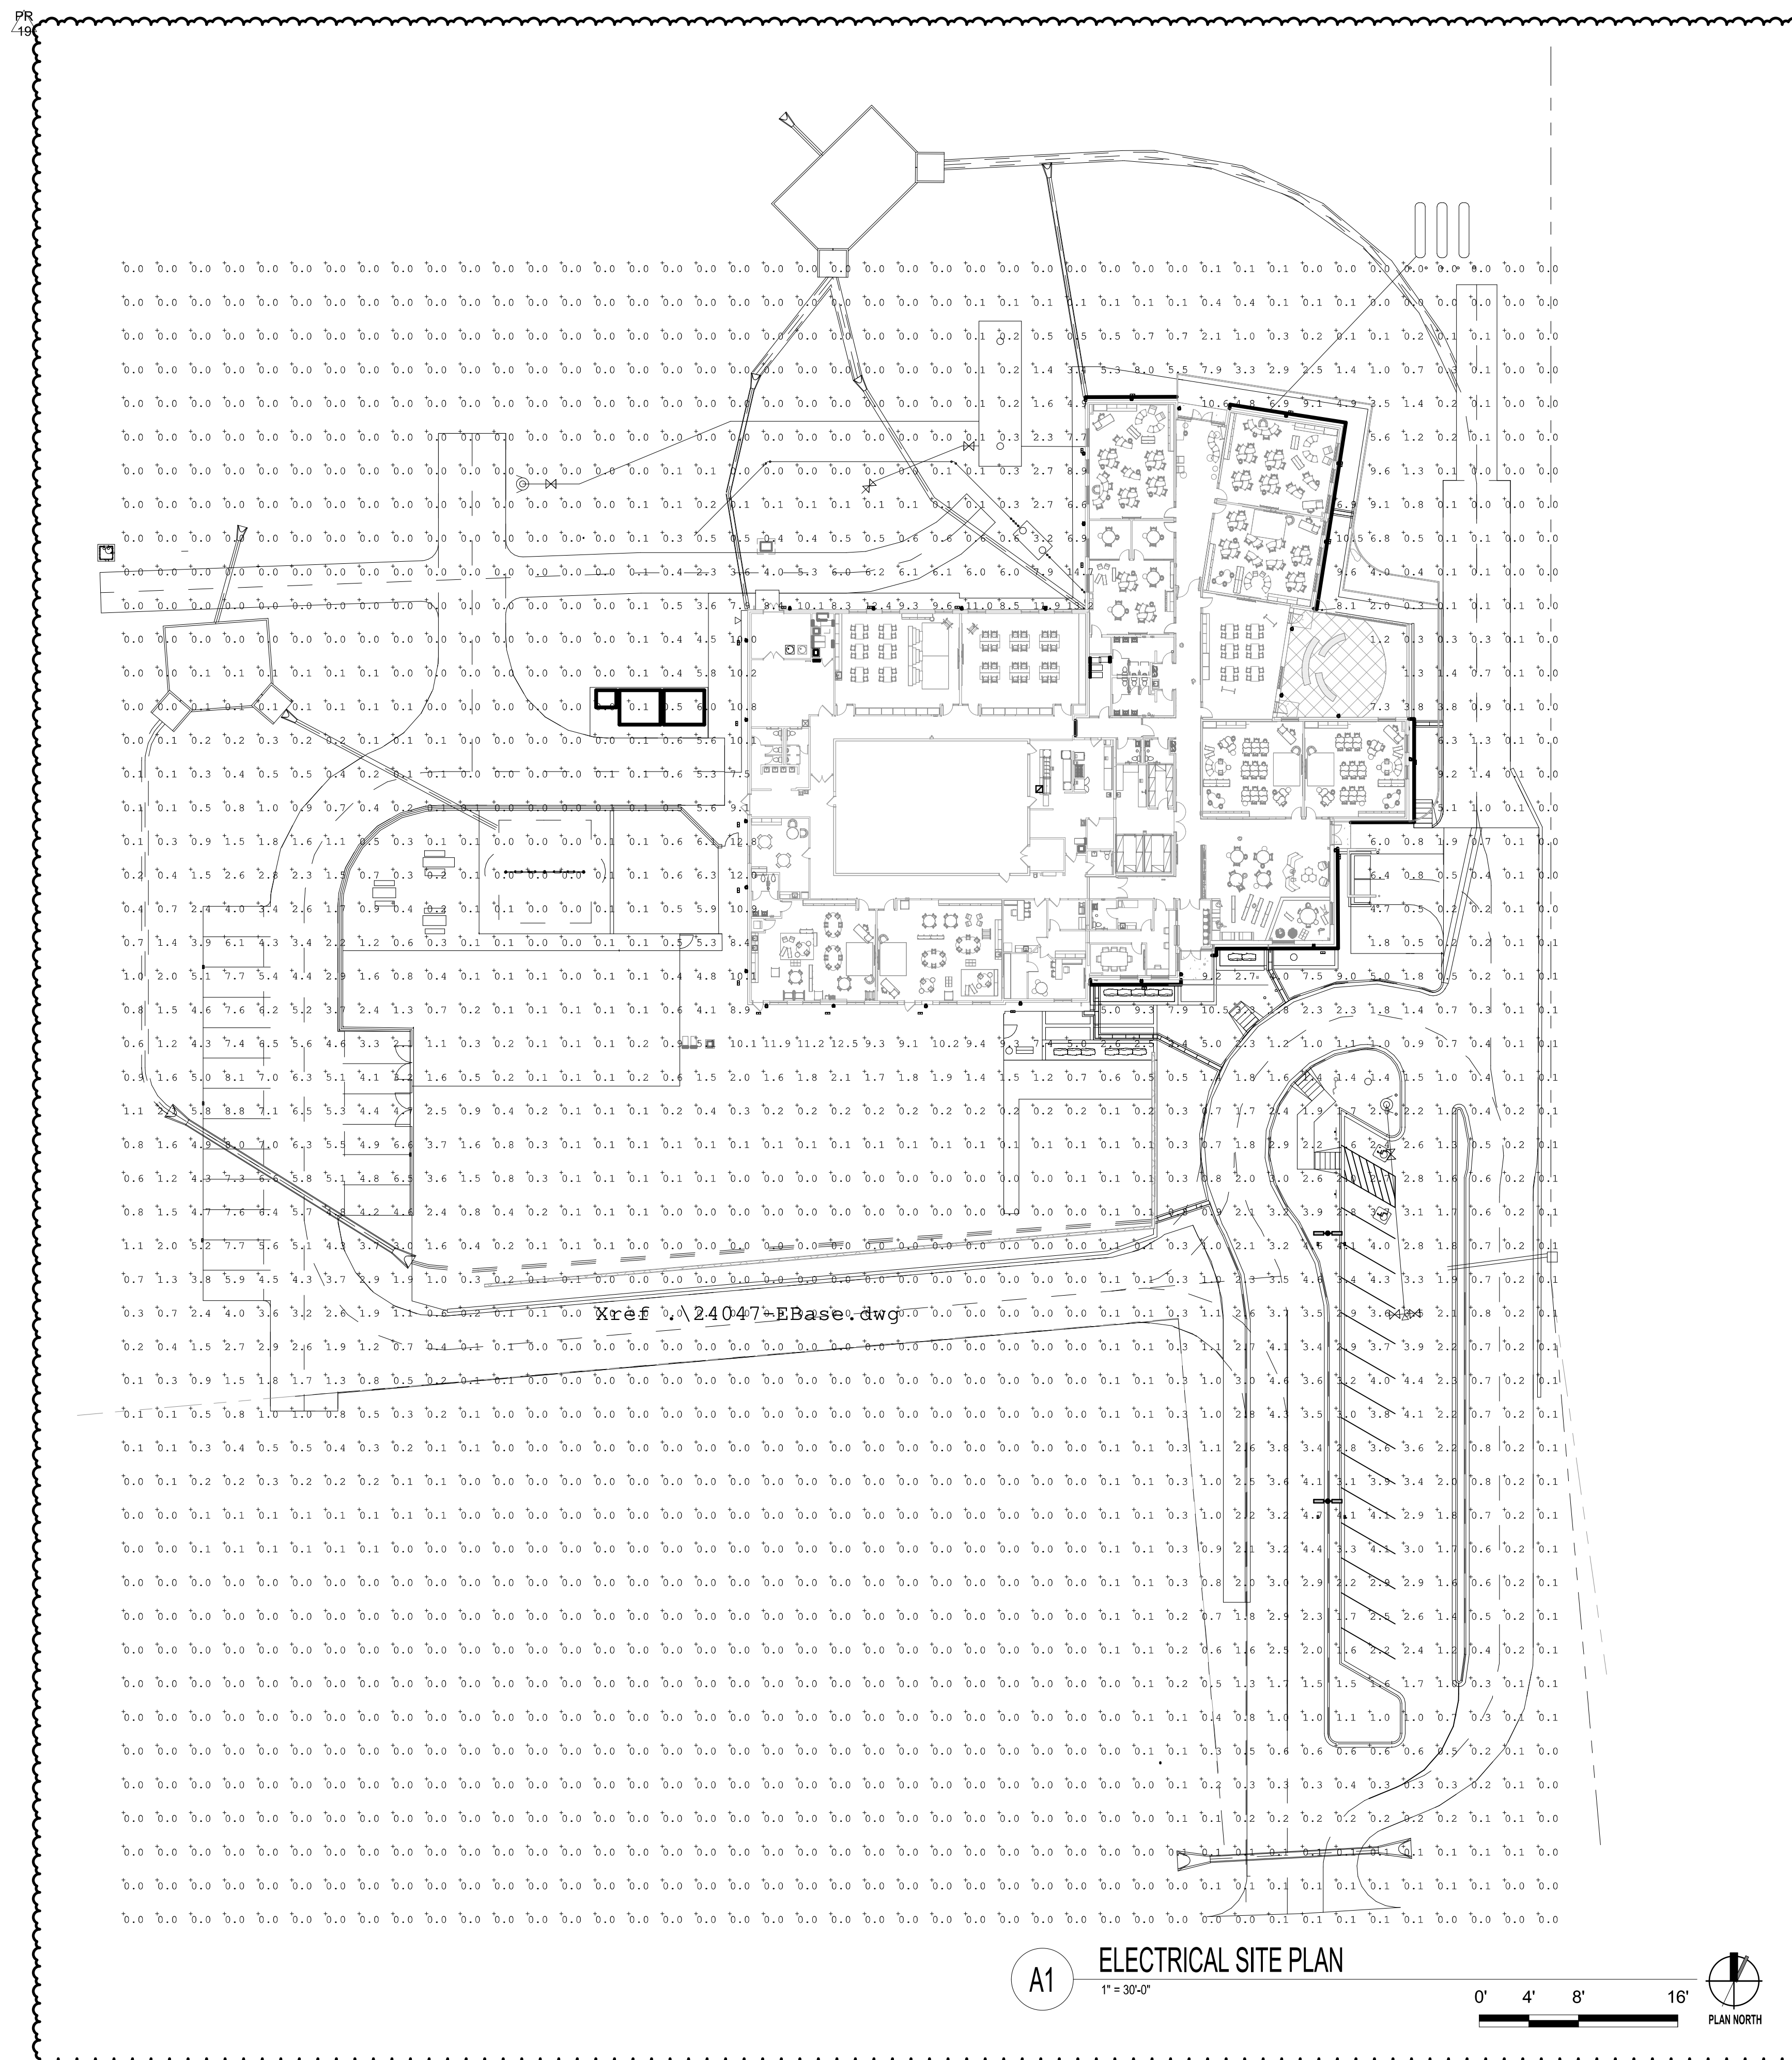

KEY PLAN

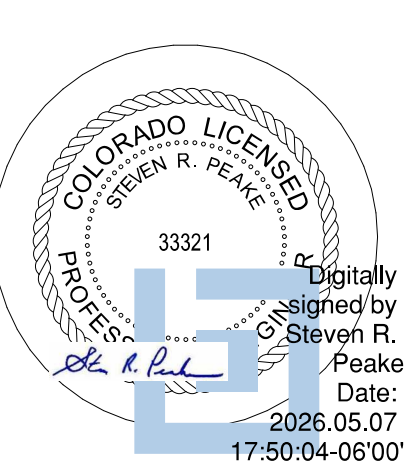

PG 19	5/7/2026
REVISION	DATE
CONSTRUCTION DOCUMENTS	
Project Number	024159.00
Date	MARCH 14, 2025
Drawn By	ESD
Checked By	SMF
Copyright:	
ALL DRAWING AND WRITTEN INFORMATION APPEARING HEREIN SHALL NOT BE DUPLICATED, DISCLOSED OR OTHERWISE USED WITHOUT THE WRITTEN CONSENT OF MOA ARCHITECTURE	
Sheet Name	ELECTRICAL SITE PLAN
	PHOTOMETRICS

ES102